


SITE PLAN AND VICINITY MAP

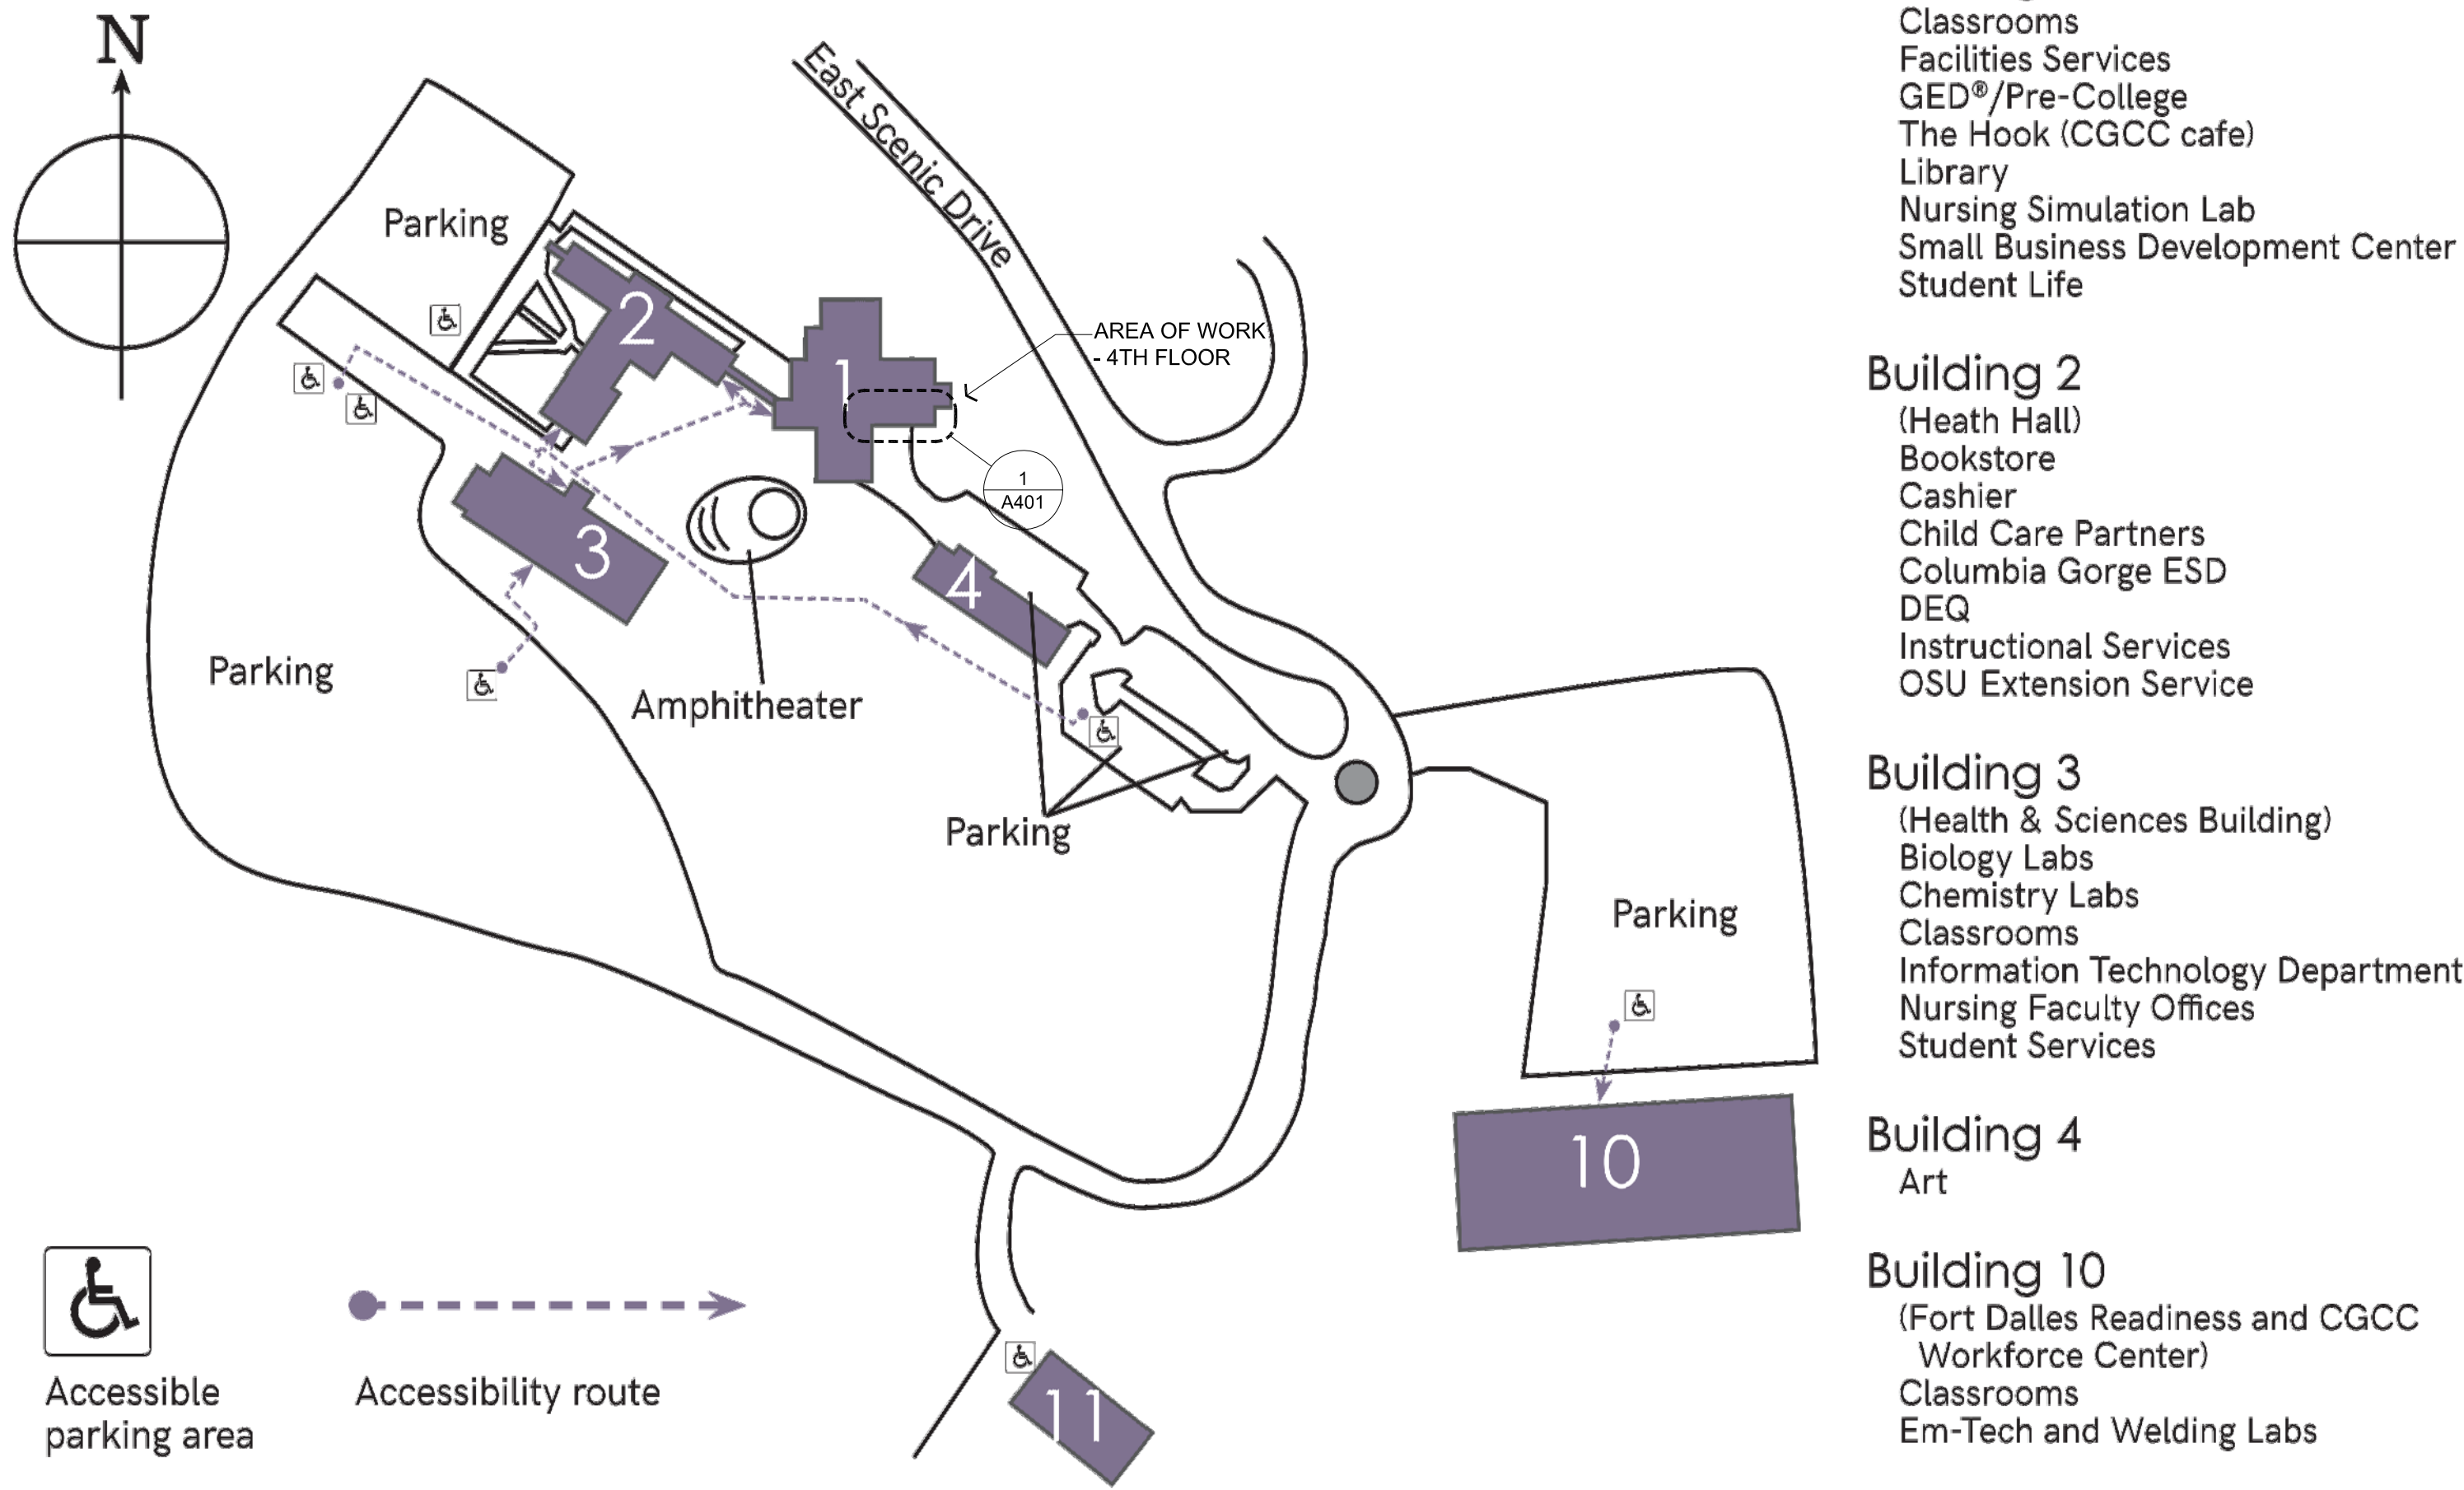

Columbia Gorge Community College
The Dalles Campus
400 East Scenic Drive
The Dalles, OR 97058

Building 1
Classrooms
Facilities Services
GED®/Pre-College
The Hook (CGCC cafe)
Library
Nursing Simulation Lab
Small Business Development Center
Student Life

Building 2
(Heath Hall)
Bookstore
Cashier
Child Care Partners
Columbia Gorge ESD
DEQ
Instructional Services
OSU Extension Service

Building 3
(Health & Sciences Building)
Biology Labs
Chemistry Labs
Classrooms
Information Technology Department
Nursing Faculty Offices
Student Services

Building 4
Art

Building 10
(Fort Dalles Readiness and CGCC Workforce Center)
Classrooms
Em-Tech and Welding Labs

Building 11
Em-Tech Lab

DRAWING INDEX

DWG #	NAME	SD	DD	CD
	GENERAL			
G000	COVER, SITE PLAN, VICINITY MAP	X	X	X
	PROJECT TEAM, DRAWING INDEX			
A201	OVERALL FLOOR PLAN & CODE ANALYSIS	X	X	X
A401	ENLARGED DEMO & FLOOR PLANS	X	X	X
A501	INTERIOR ELEVATIONS	X	X	X
A601	REFLECTED CEILING PLAN & DETAILS	X	X	X
A801	SCHEDULES & DETAILS	X	X	X
A802	DETAILS	X	X	X
A901	FINISH FLOOR PLAN	X	X	X
	MECHANICAL			
M001	GENERAL NOTES, ABBREVIATIONS		X	X
M401	PARTIAL MECHANICAL FLOOR PLAN		X	X
M402	PARTIAL MECHANICAL DEMO PLAN		X	X
P001	PLUMBING COVER SHEET		X	X
P401	PARTIAL PLUMBING FLOOR PLAN		X	X
P402	PARTIAL PLUMBING DEMO PLAN		X	X
	ELECTRICAL			
E001	ELECTRICAL ABBREVIATIONS & SYMBOLS LEGEND		X	X
E002	LUMINAIRE SCHEDULE		X	X
ED201	DEMOLITION ELECTRICAL CEILING PLAN		X	X
ED202	DEMOLITION ELECTRICAL FLOOR PLAN		X	X
E201	LIGHTING PLAN		X	X
E202	POWER FLOOR PLAN		X	X
E203	LOW VOLTAGE FLOOR PLAN		X	X
E204	FIRE ALARM FLOOR PLAN		X	X
E300	PANEL SCHEDULES		X	X

GENERAL NOTES:

- PROJECT CONSISTS OF A 1785 SF INTERIOR REMODEL ON THE 4TH FLOOR CONVERTING CLASSROOM SPACE INTO NURSING SIMULATION LABS.
- WORK INCLUDES FINISHES, NEW PARTITIONS, DOORS, CEILINGS, LIGHTING & POWER, WITH ALTERED LOCATIONS OF HVAC GRILLES AND SPRINKLER HEADS

PLANNING INFORMATION

LEGAL DESCRIPTION: LOT 1 OF MINOR PARTITION PLAT FILED DECEMBER 31, 1990 AS FILE NO. MP 900022, LOCATED IN A PORTION OF SECTIONS 4, 9 AND 10 IN TOWNSHIP 1 NORTH, RANGE 13 EAST OF THE WILLAMETTE MERIDIAN, WASCO COUNTY, STATE OF OREGON.

ZONING:

APPLICABLE CODES

2022 OREGON STRUCTURAL SPECIALTY CODE
2022 OREGON MECHANICAL SPECIALTY CODE
2021 OREGON ELECTRICAL SPECIALTY CODE
2021 OREGON PLUMBING SPECIALTY CODE
2021 OREGON ENERGY EFFICIENCY SPECIALTY CODE
2022 OREGON FIRE CODE

DEFERRED SUBMITTALS

- FIRE PROTECTION
- FIRE ALARM SYSTEM
- PLUMBING & MECHANICAL PERMIT APPLICATIONS TO BE MADE BY PLUMBING & MECHANICAL CONTRACTORS

CODE SUMMARY

CONSTRUCTION TYPE 1
OCCUPANCY: B

PROJECT TEAM

OWNER

Columbia Gorge Community College
400 E. Scenic Drive
The Dalles, OR 97058
Contact: Danny Dehaze
dkehaze@cgcc.edu

ARCHITECT

Soderstrom Architects, Ltd
11331 NW Lovejoy St, Suite 775
Portland, Oregon 97209
Contact: Mike Shea
(503) 964-4329
michaels@sdra.com

MECHANICAL ENGINEER

Arris Consulting
2622 SE 25th Ave, Suite A
Portland, OR 97202
(503) 309-6335
Contact: Brian Butler
brian@arris-consulting.com

ELECTRICAL ENGINEER

Landis Consulting
5335 Meadows Rd, #388
Lake Oswego, OR 97035
Contact: Michael Henning
(503) 413-0658
michael_henning@landisconsulting.com

Soderstrom
Architects

1331 NW Lovejoy St., Suite 775
Portland, OR 97209

T 503-228-5617
F 503-227-8584

sdra.com

Nursing Simulation Lab
Building 1 - Columbia Gorge Community College
400 East Scenic Drive
The Dalles, OR 97058



Project

Consultant

Revisions

No. Description Date

Stamp



Issuance

100% CD

Date

7.28.23

Project Number

22093
EDA Award Number 07-79-07767
URI 116720

Drawing Title

GENERAL
INFORMATION

Sheet No

G000



Consultant

Revisions		
No.	Description	Date



Issuance
100% CD


Date
7.28.23

Project Number
22093
EDA Award Number 07-79-07767
URI 116720

Drawing Title
**OVERALL FLOOR
PLAN & CODE
ANALYSIS**

Sheet No
A201

LEGEND

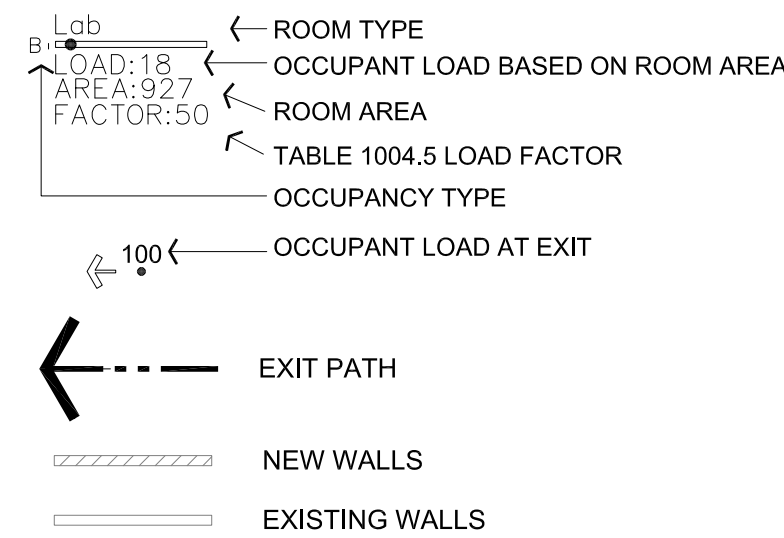


CODE ANALYSIS

2022 OREGON STRUCTURAL SPECIALTY CODE
2022 OREGON MECHANICAL SPECIALTY CODE
2021 OREGON ELECTRICAL SPECIALTY CODE
2021 OREGON PLUMBING SPECIALTY CODE
2021 OREGON ENERGY EFFICIENCY SPECIALTY CODE
2022 OREGON FIRE CODE


- FOURTH FLOOR BUILDING AREA: 138,762 SF
- AREA OF WORK FOR THIS TENANT IMPROVEMENT PROJECT IS 1785 SF
- CONSTRUCTION TYPE: I (ASSUMED DUE TO CONCRETE CONSTRUCTION)
- FULL SPRINKLER SYSTEM PROVIDED
- B OCCUPANCY

GENERAL NOTES:



- PROJECT CONSISTS OF A 1785 SF INTERIOR REMODEL ON THE 4TH FLOOR CONVERTING CLASSROOM SPACE INTO NURSING SIMULATION LABS.
- WORK INCLUDES FINISHES, NEW PARTITIONS, DOORS, CEILINGS, LIGHTING & POWER, WITH ALTERED LOCATIONS OF HVAC GRILLES AND SPRINKLER HEADS

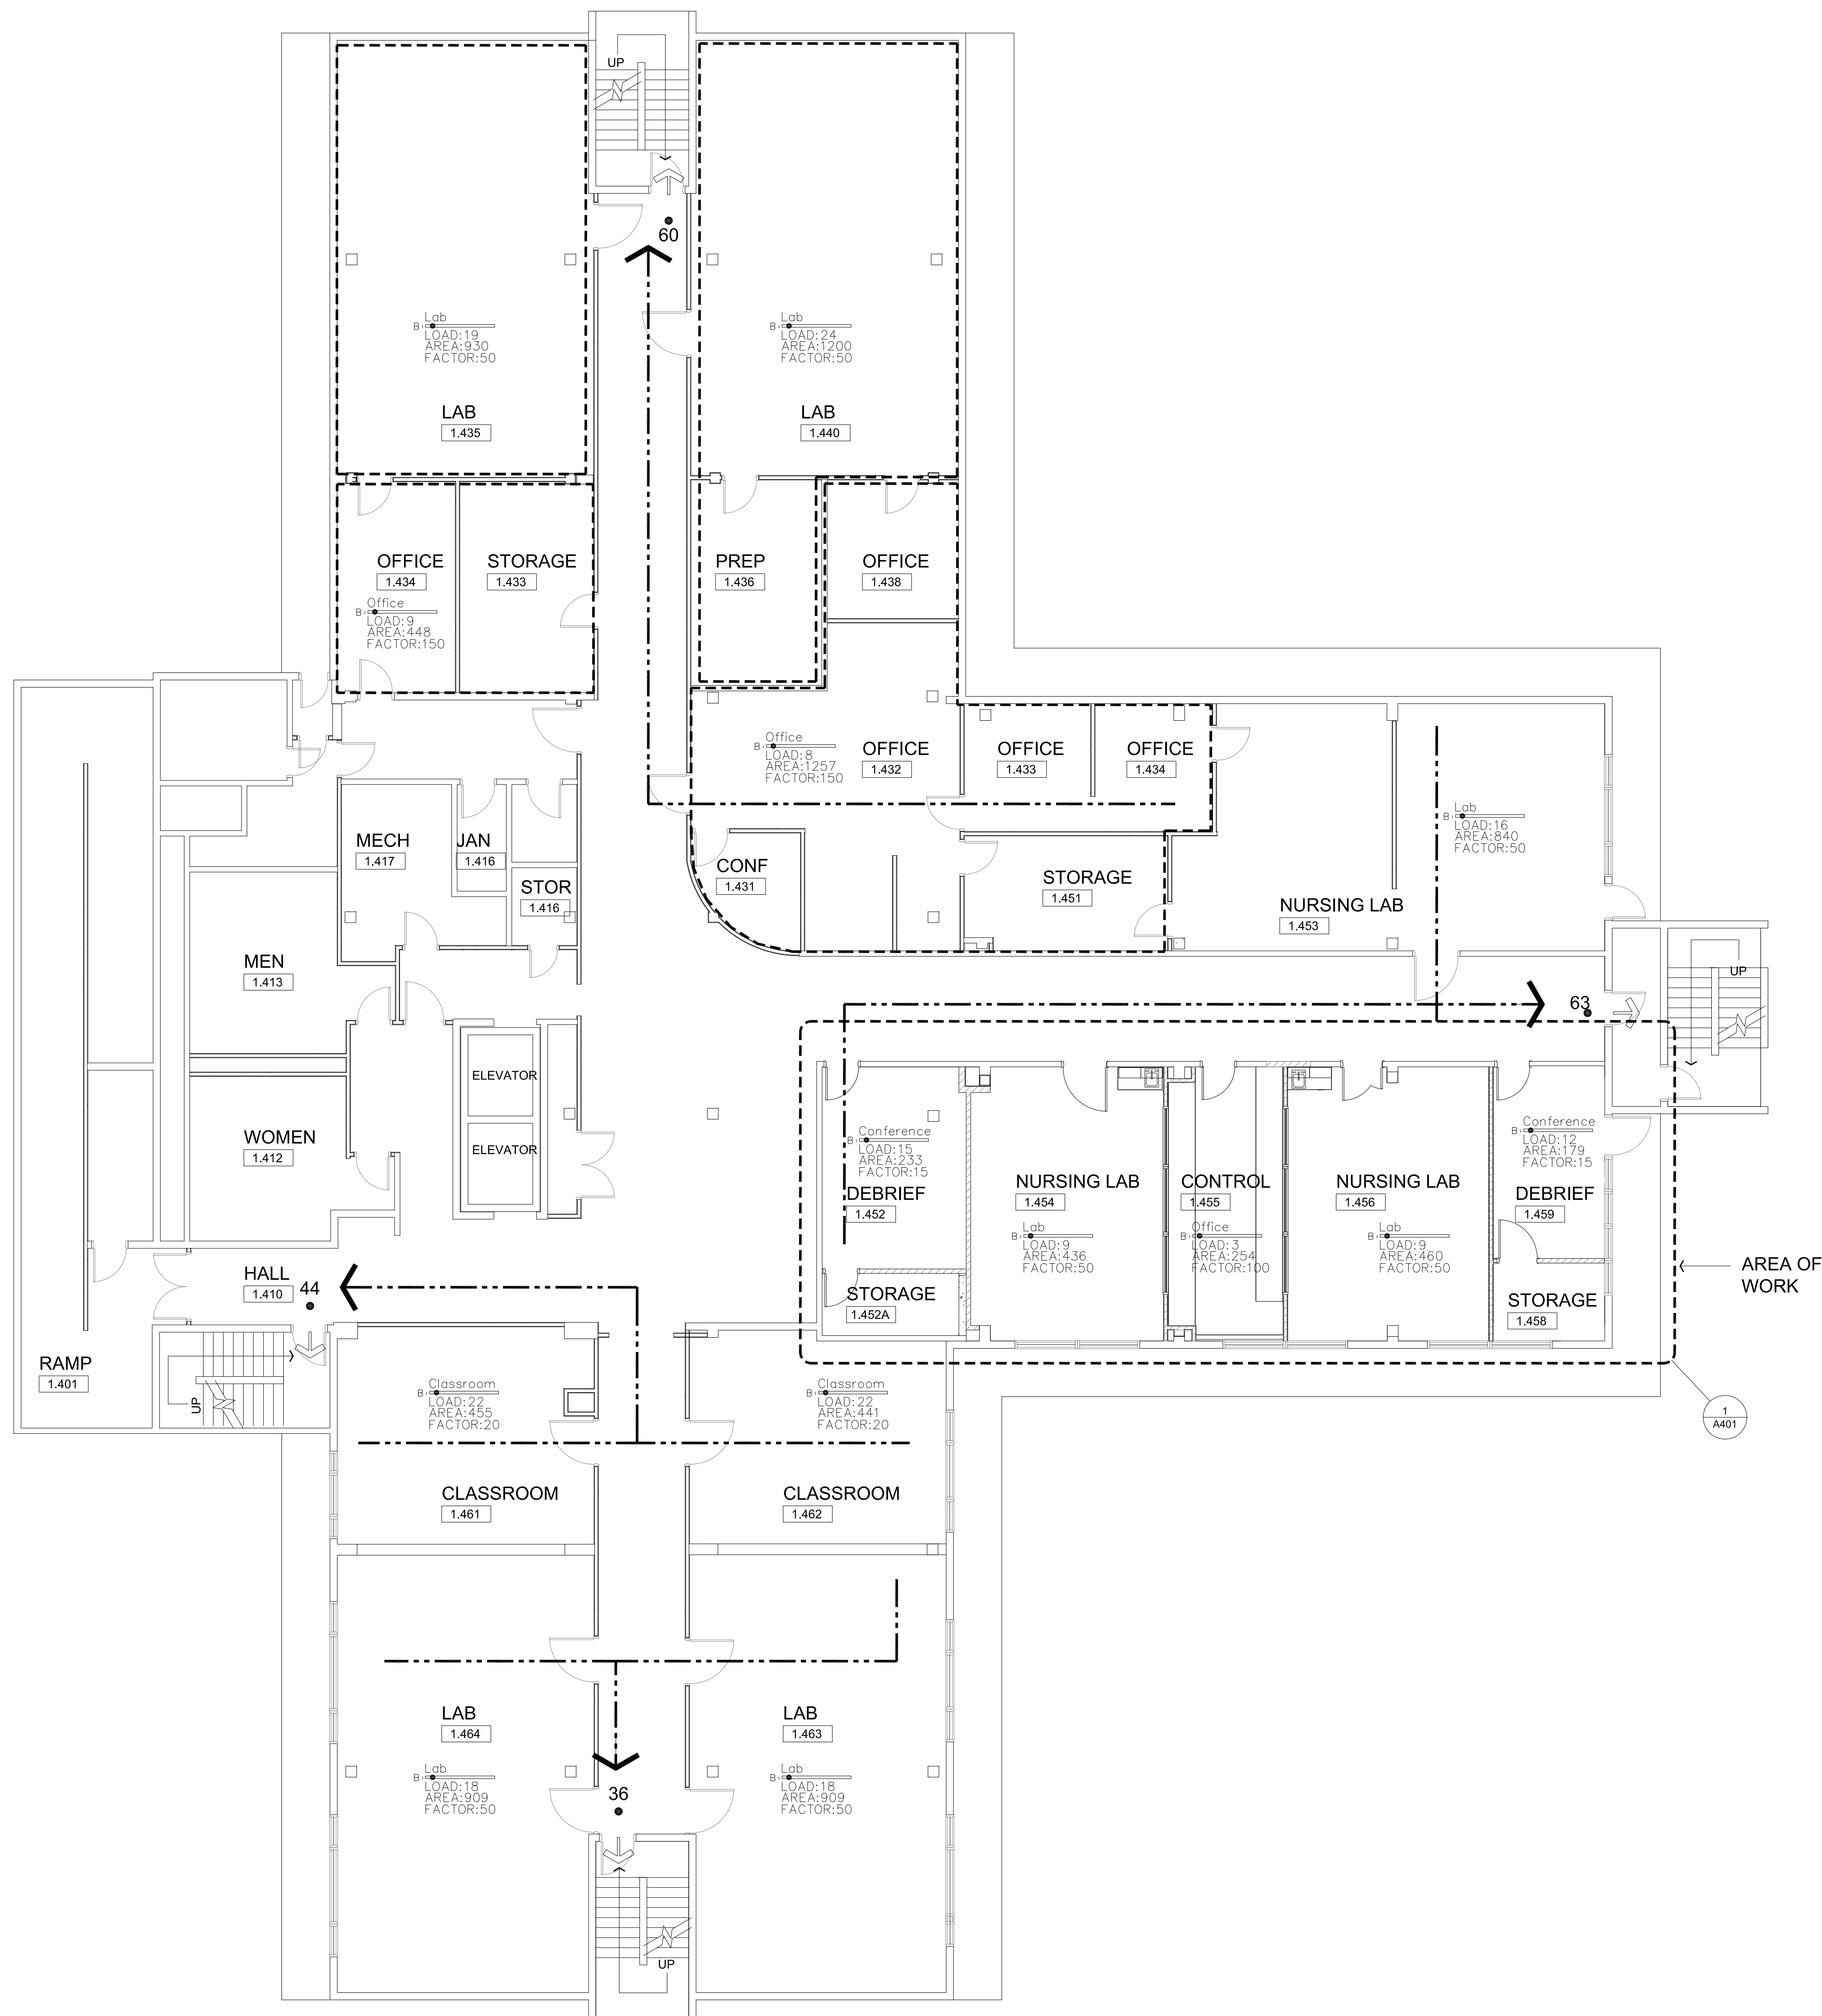

1 OVERALL FOURTH FLOOR PLAN
1/8" = 1'-0"

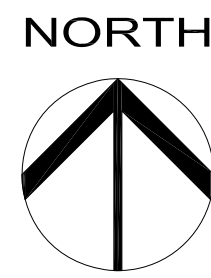

FILE PATH C:\Users\elizabethg\Documents\33.06.05 CGCC-SDRA ver 2022 Central re_elizabethgPSBH1.rvt
copyright © 2018

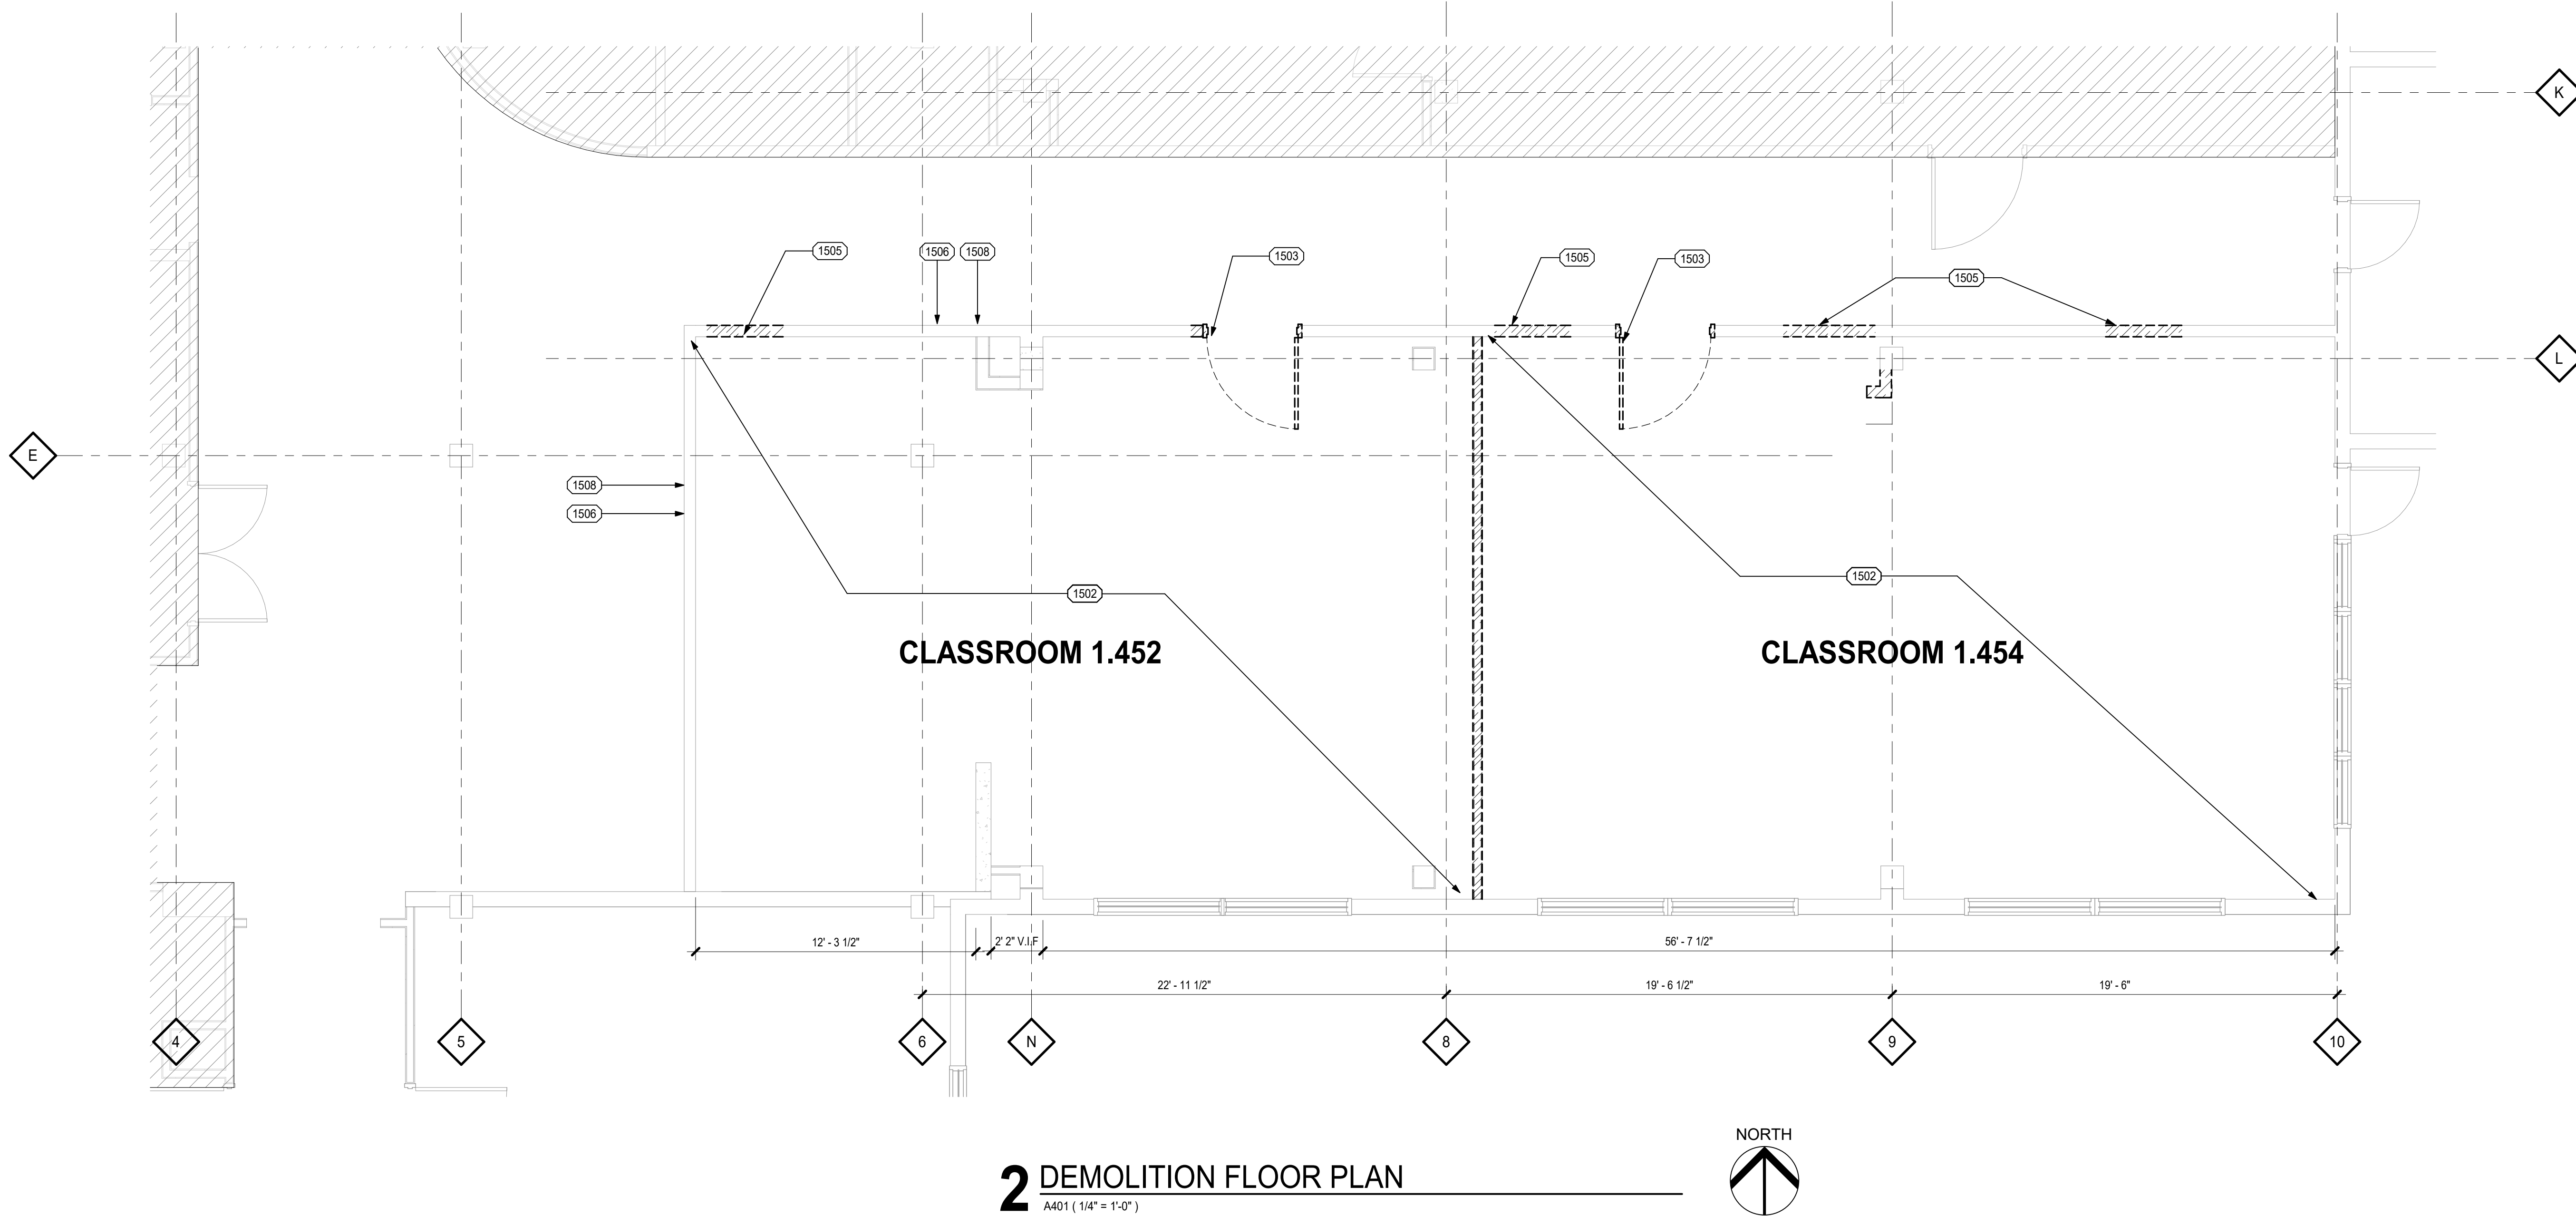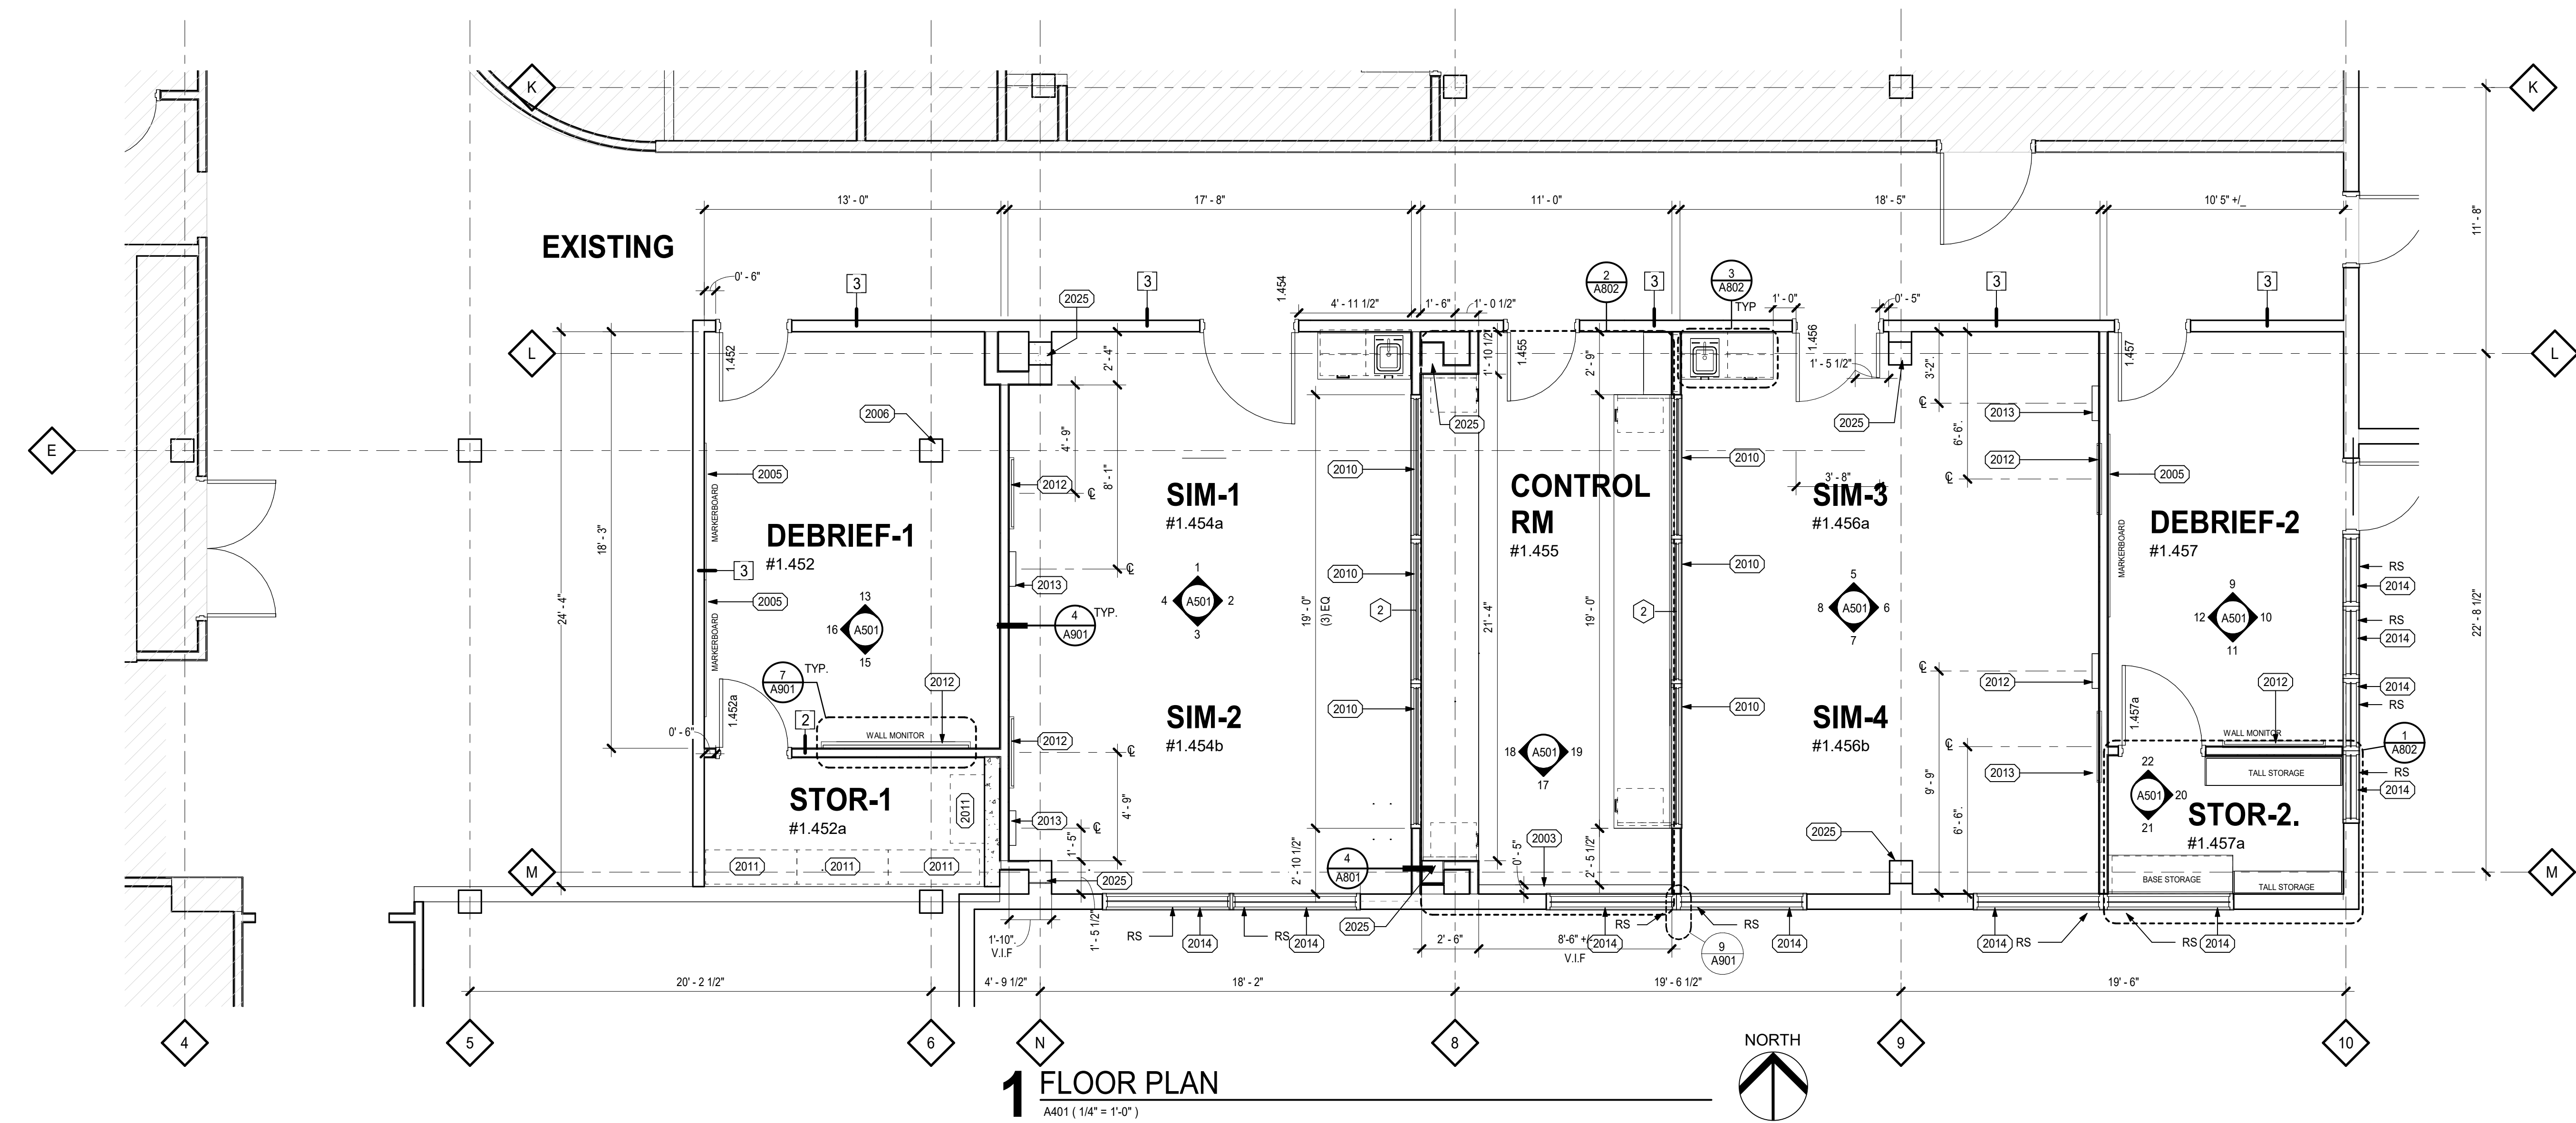

FLOOR PLAN NOTES

1. ALL WALLS EXTEND TO CONCRETE STRUCTURE ABOVE.
2. ALL WALLS ARE TYPE 1, U.O.N. SEE A901.
3. VERIFY DIMENSION IN THE FIELD PRIOR TO CONSTRUCTION.
4. PRIOR TO EQUIPMENT / MATERIAL INSTALLATION PREP WALLS PER MANF. RECOMMENDATIONS.
5. PROVIDE BACKING @ ALL EQUIPMENT AND FIXTURES TO BE WALL MOUNTED.
6. REMOVE / RELOCATE, THERMOSTATS, SWITCHES, HVAC GRILLS ETC PER NEW CONSTRUCTION.

LEGEND

- ENLARGED VIEW MARK
1=SECTION NO.
A101= SHEET NO.
- DOOR TAG
#1.XXX
- FRAMED WALL
- EXISTING WALL TO REMAIN
- WALL TO BE DEMOLISHED
- AREA OF NO WORK
(NOT IN CONTRACT)
- EQUIPMENT
- ROLLER SHADE
RS
- WALL TYPE
#
- WINDOW TYPE

LEGEND - KEYNOTES

MARK	DESCRIPTION
1502	REMOVE EXISTING FLOOR/BASE MATERIALS. PREP FLOOR FOR NEW FINISHES
1503	DEMOLISH DOOR, FILL WALL, REFINISH EXISTING SURFACE
1505	DEMOLISH WALL, PREP FOR NEW DOOR
1506	REMOVE BASE
1508	PREP WALL FOR NEW PAINT
2003	FUR WALL, BELOW WINDOW, CHANNEL ELEC. WIRES FOR CONTROL TOWER.
2005	TACKBOARD / MARKERBOARD, SEE ELEVATION
2006	EXISTING COLUMNS, P-3
2010	OBSERVATION WINDOW, ONE WAY GLASS MIRROR
2011	4L TO 3' L. SHELVES, OFOI
2012	MONITOR, SEE ELECTRICAL FOR MORE INFO.
2013	32 1/2" W.X. 63" H. VERTICAL HEADWALL, SEE ELECTRICAL FOR ADDITIONAL INFO.
2014	MANUEL ROLLER SHADE, SEE FINISH SUMMARY
2025	EXISTING COLUMN TO MATCH GYP SURFACE. FEATHER ALL TRANSITIONS FOR SEAMLESS EDGE.



Project


Consultant

Revisions

No. Description

Date

Stamp

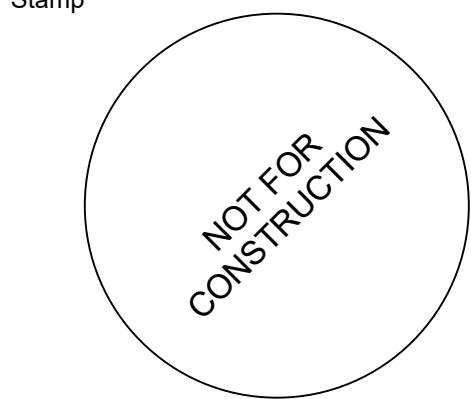

Issuance

95% CD

Date

07.28.23

Project Number

22093

EDA Award Number 07-79-07767


URI 116720

Drawing Title


FLOOR PLAN /
DEMOLITION PLAN

Sheet No


A401

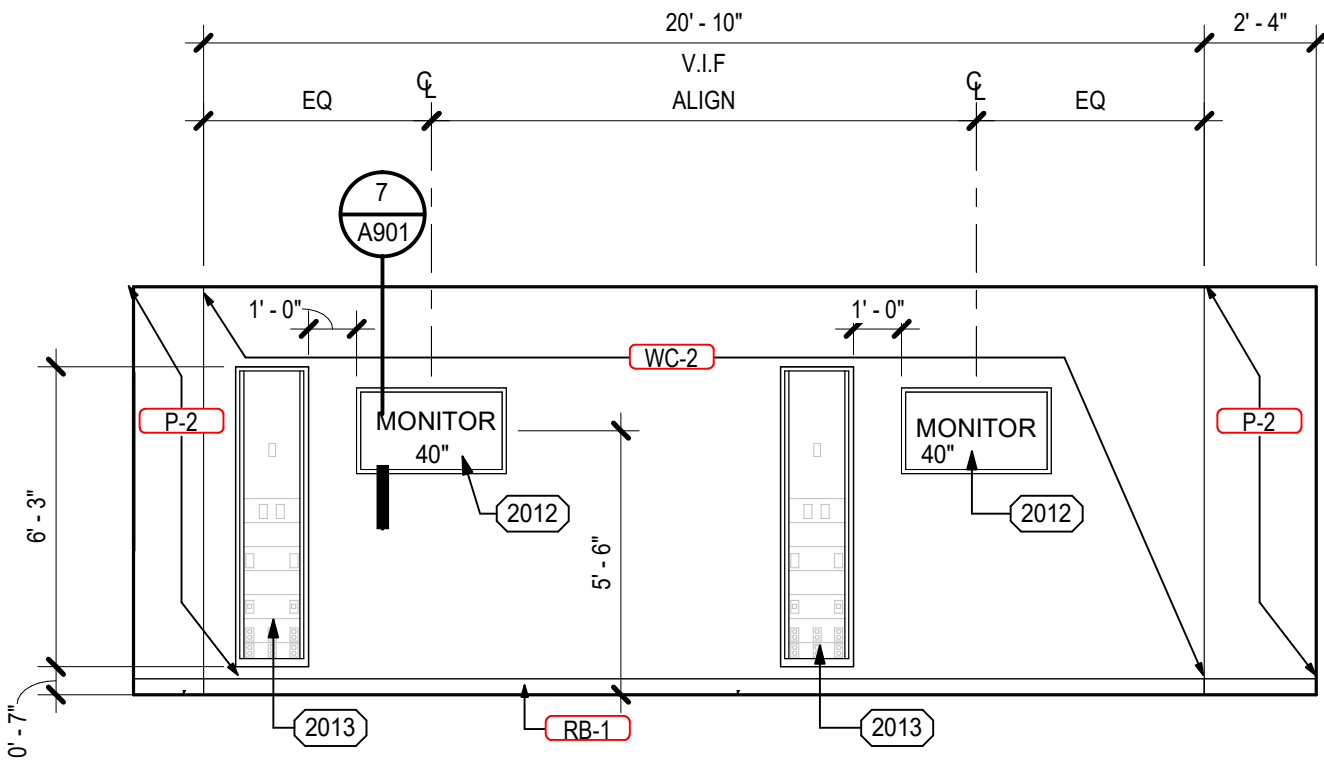


4 SIM 1,2_ WEST ELEVATION

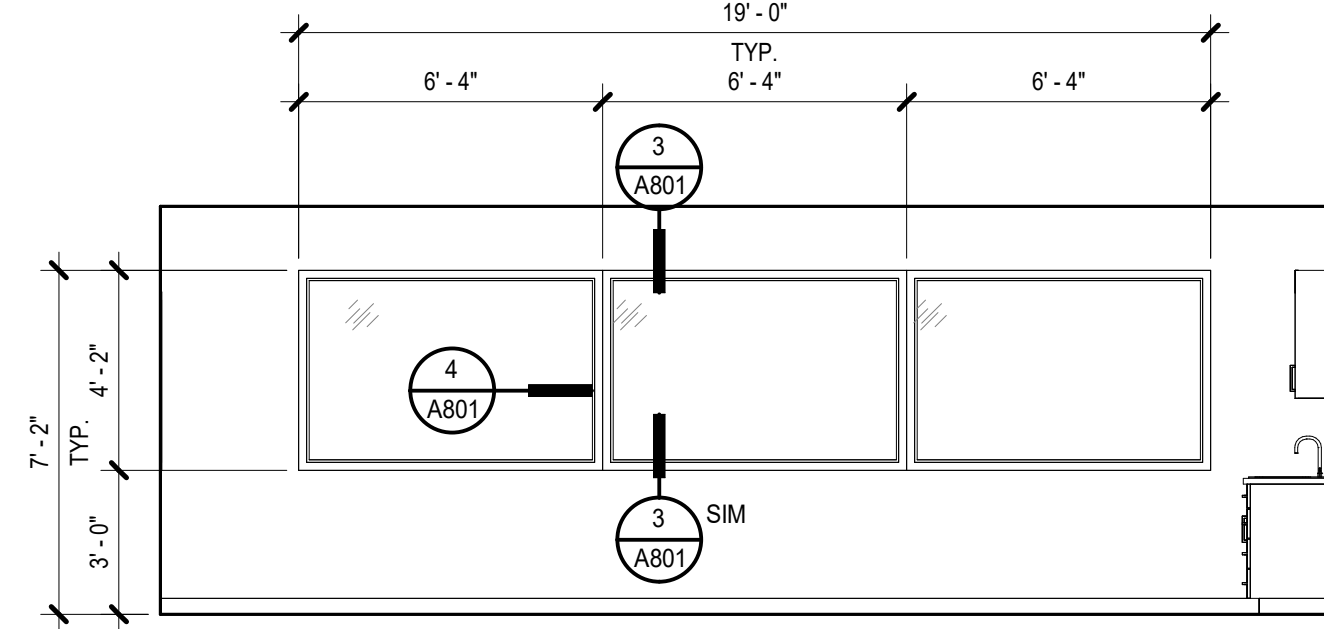


8 SIM 3,4 WEST ELEVATION

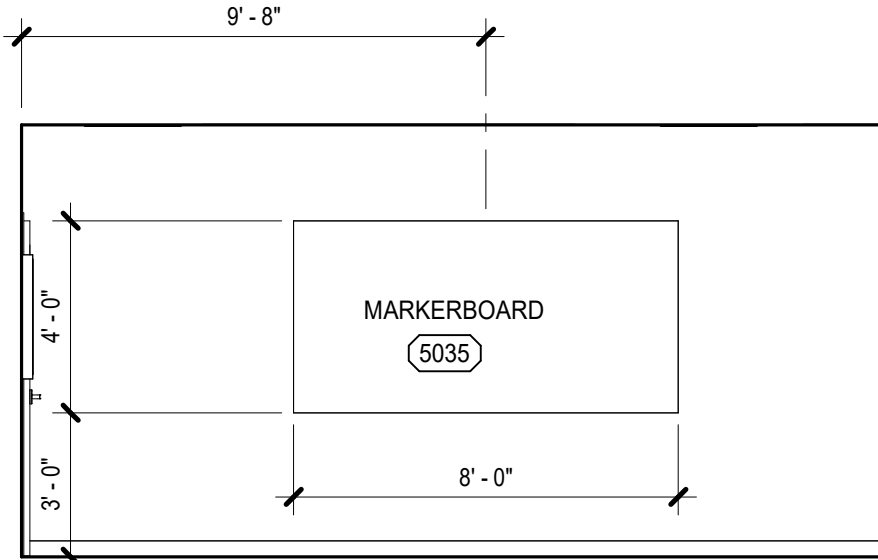

12 DEBRIEF RM 2 WEST

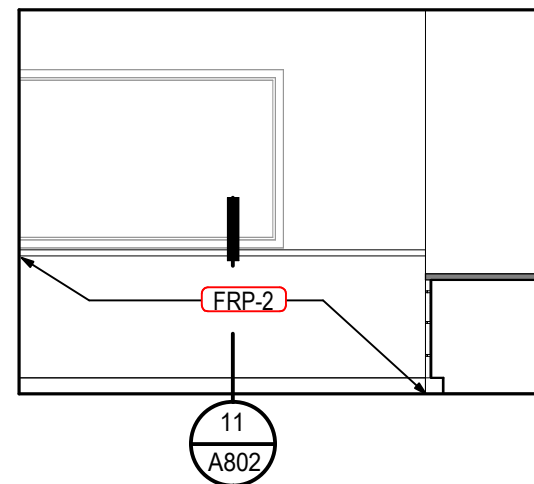

17 CONTROL RM SOUTH
A501 (1/4" = 1'-0")

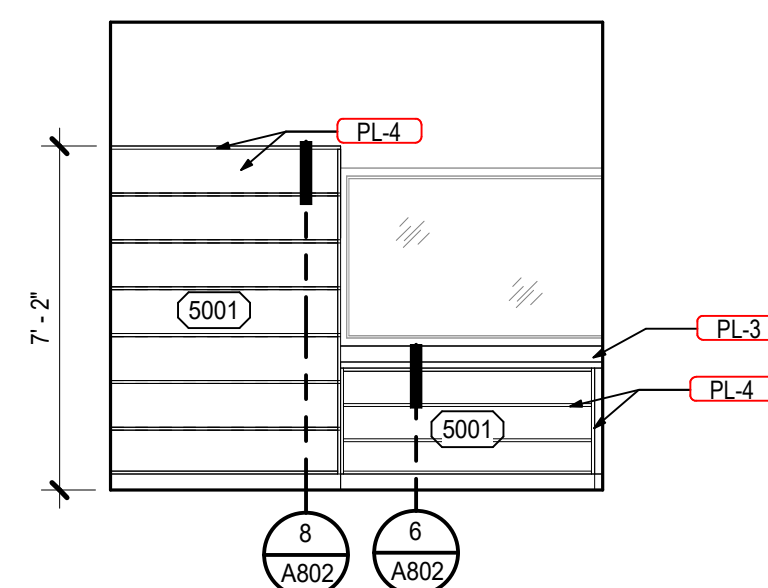

21 STORAGE RM_SOUTH

<u>LEGEND - KEYNOTES</u>	
MARK	DESCRIPTION
2008	EXISTING COLUMNS, P-3
2012	MONITOR, SEE ELECTRICAL FOR MORE INFO.
2013	32 1/2" X 16" X 63" H VERTICAL HEADWALL, SEE ELECTRICAL FOR ADDITIONAL INFO.
5001	OPEN SHELVES, SEE A802 FOR DESIGN INTENT
5003	OPEN COUNTER WIPANEL, SEE A802 FOR DESIGN INTENT
5004	CASEWORK - BOOK SHELF
5020	MARKERBOARD 8X4
5026	MARKERBOARD 8X4
5206	LIGHTING, SEE ELECTRICAL



A501

FILE PATH C:\Users\elizabethg\Documents\23.07.30 CGCC-SDRA ver 2022\Central_ite_detached_elizabethgP5BNH.nt
copyright © 2018




Project

Consultant

Revisions
No. Description Date

Stamp

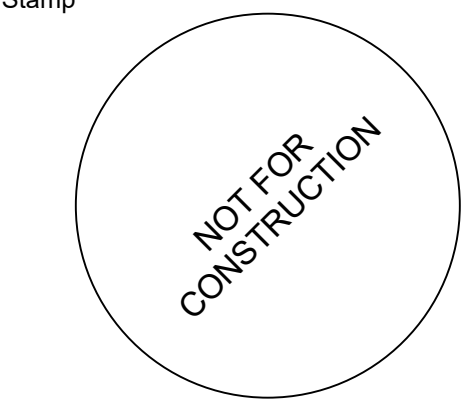

Issuance
100% CD

Date
07.28.23

Project Number
22093
EDA Award Number 07-79-07767
URI 116720

Drawing Title
**RCP / DEMO
REFLECTED CEILING
PLAN**

Sheet No

A601

SHEET NOTES

1. REFER TO ENGINEER'S DRAWINGS FOR LIGHT SWITCHING AND SPECIFICATION, EXIT SIGN LOCATIONS, AND ELECTRICAL AND MECHANICAL SYSTEMS.
2. REPORT TO ARCHITECT ANY CONFLICTS BETWEEN ELECTRICAL, MECHANICAL, OR STRUCTURAL DRAWINGS AND THIS LAYOUT.
3. ALL VISIBLE STRUCTURE, DUCTWORK, PIPES, CONDUITS, AND OTHER ASSOCIATED COMPONENTS NOT FULLY CONCEALED BEHIND A CONTINUOUS CEILING TO BE PAINTED.
4. ALL LIGHTS AND GRIDS ARE TO BE CENTERED IN ROOM, UNO.
5. GENERAL CEILING HEIGHT: 9'-0" U.N.O.

LEGEND

- ACOUSTIC CEILING TILE (ACT)
- OPEN TO STRUCTURE
- SUPPLY AIR GRILL
- RETURN AIR GRILL
- FRAMED WALL
- EXISTING WALL TO REMAIN
- WALL TO BE DEMOLISHED
- AREA OF NO WORK (NOT IN CONTRACT)
- SPRINKLER
- LINEAR PENDANT
- PENDANT
- DOWNLIGHT
- 2X2 TROFFER
- CEILING HEIGHT TAG

LEGEND - KEYNOTES

MARK	DESCRIPTION
1505	DEMOLISH WALL, PREP FOR NEW DOOR
6006	PARTITION CURTAIN WITH TRACK
6007	REMOVE EXISTING BULKHEAD & SOFFIT
6008	REMOVE ALL LIGHTING, CONDUIT, WIRE AND DUCTWORK, BOTH ROOMS
6009	CUT OPENING PREP FOR NEW DOOR
6010	REMOVE EXISTING SPRINKLERS LINES & HEAD INSIDE ROOMS

1 PARTIAL REFLECTED CEILING PLAN

A601 (1/4" = 1'-0")




2 DEMOLITION REFLECTED CEILING PLAN

A601 (1/4" = 1'-0")



FILE PATH C:\Users\elzaberg\Documents\23.06.05 CCCC-SDRA ver 2022 Central re_elzaberg\PSBH1.rvt
copyright © 2018

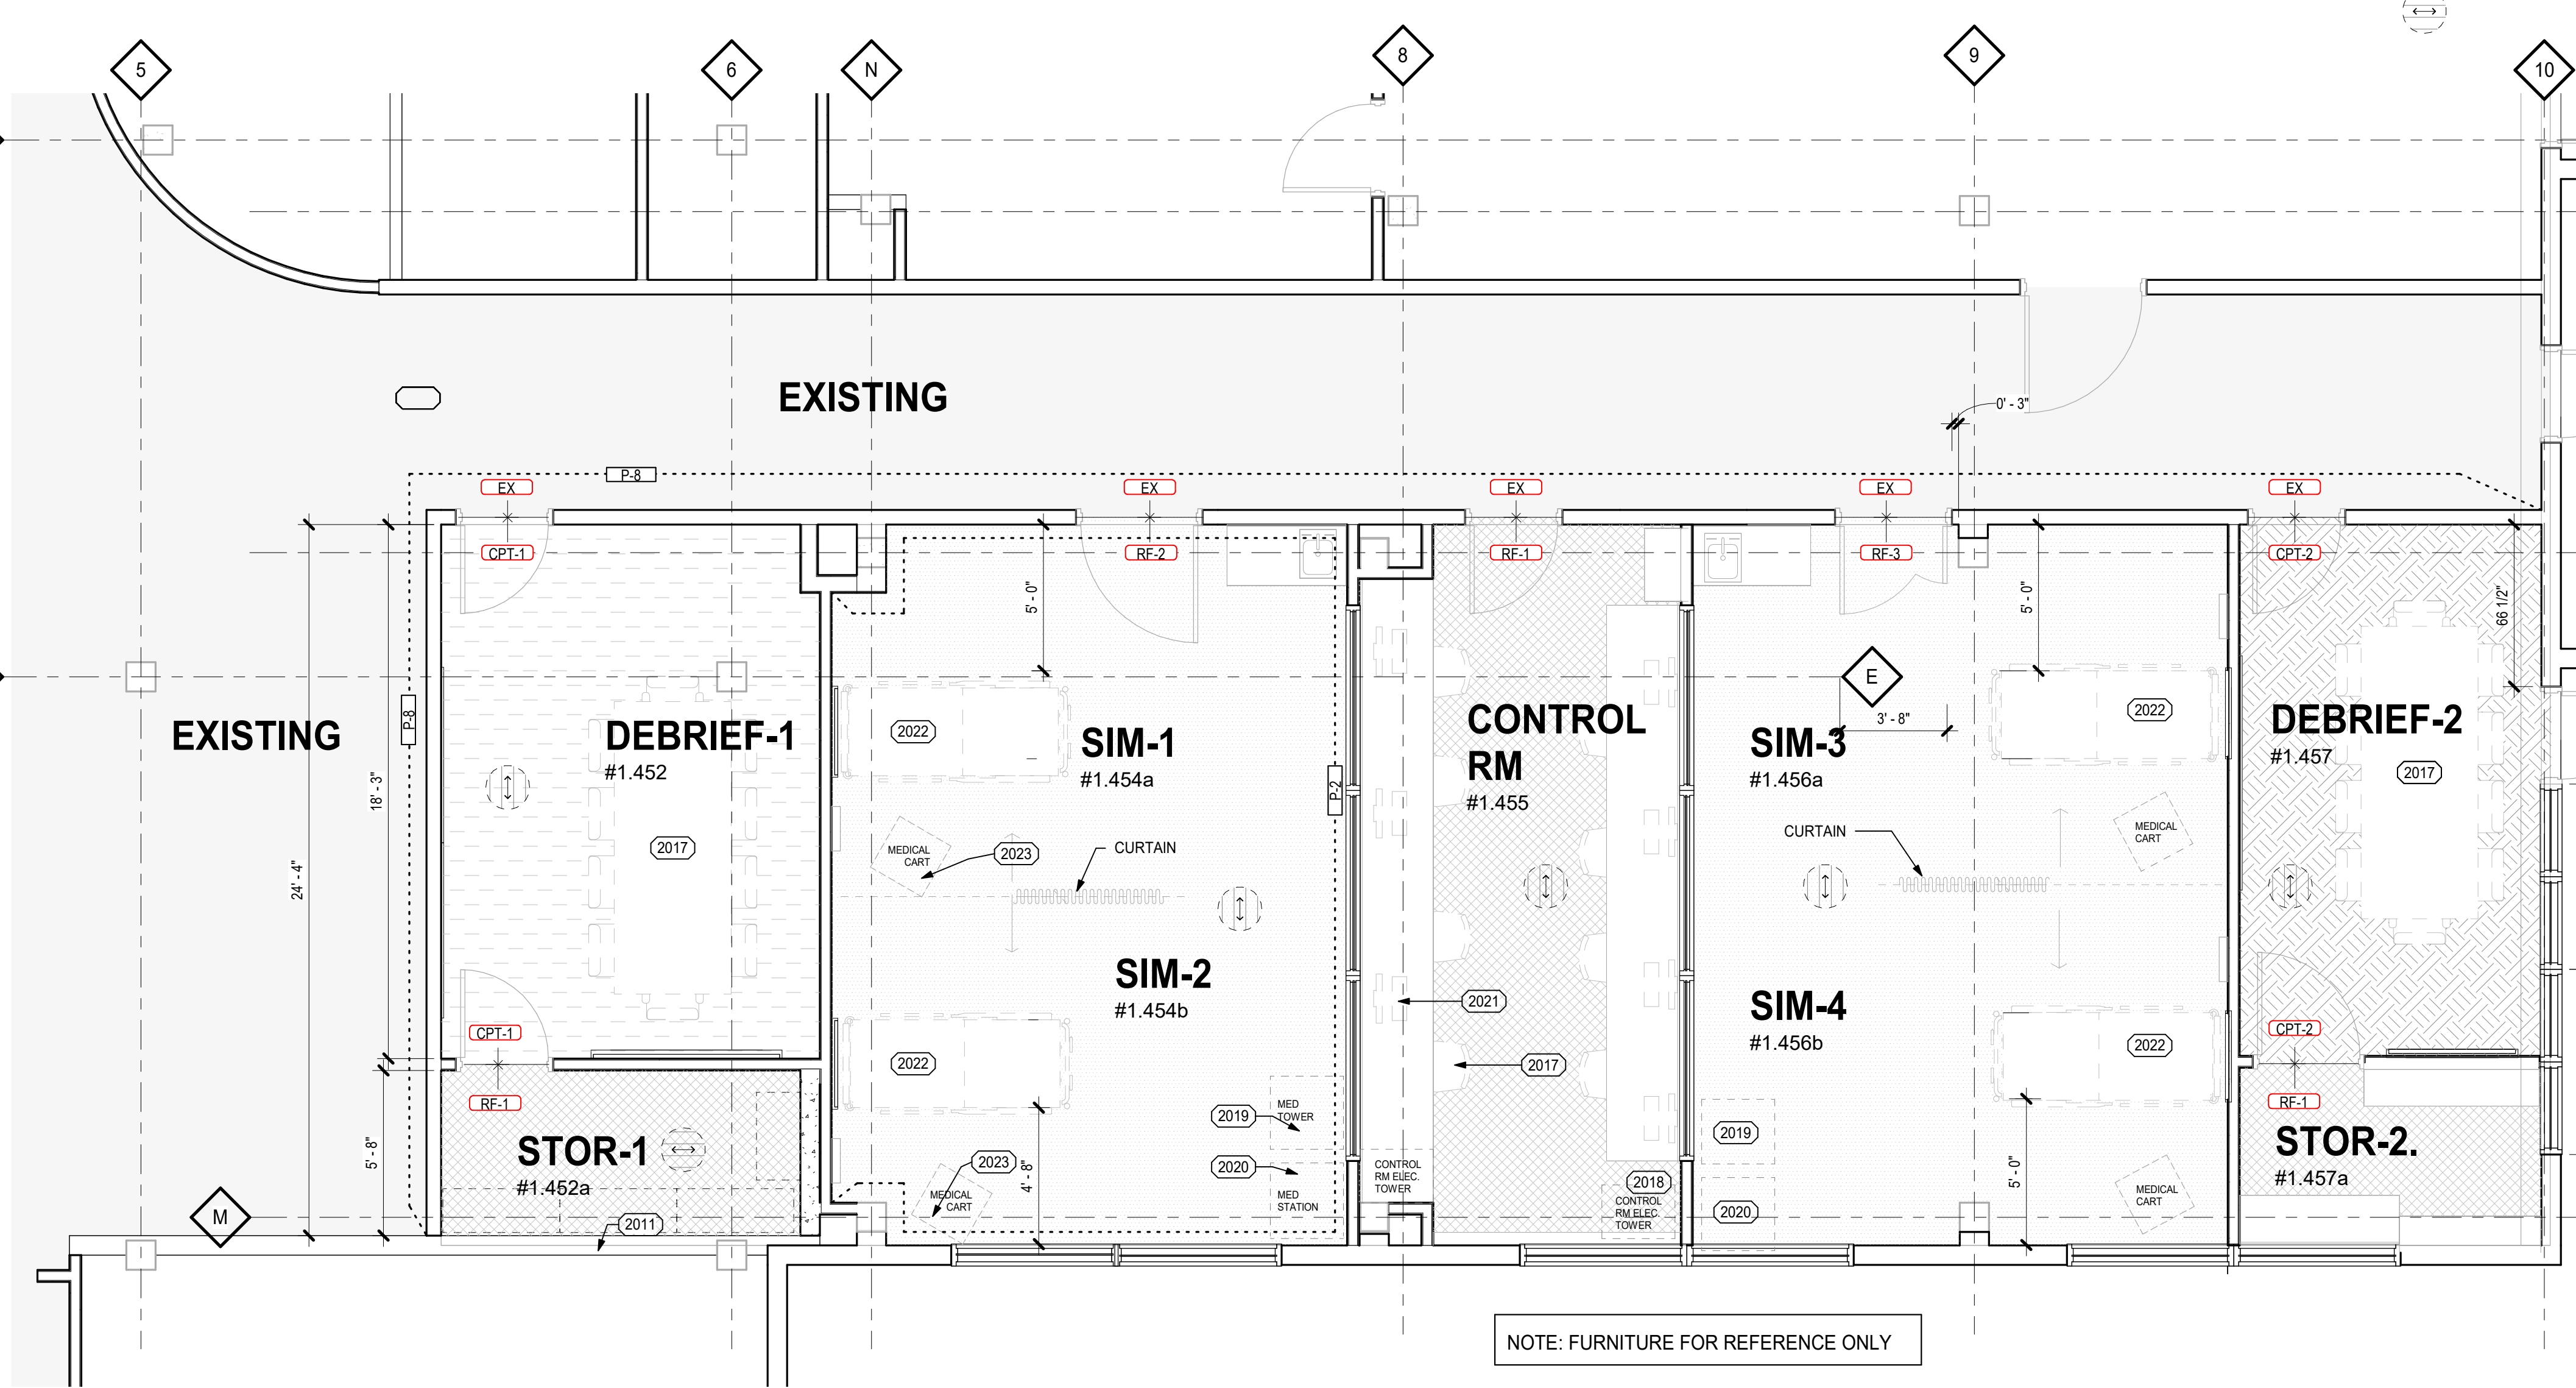

1 FINISH / FURNITURE PLAN

A801 (1/4" = 1'-0")

FINISH LEGEND

FINISH CARPENTRY WINDOW SILLS	SECTION 06 2000
WD-1	MANUFACTURER: REFER TO SPEC FOR ACCEPTABLE SPECIES NOTE: SEE PLASTIC LAMINATE / COUNTERTOPS FOR FINISHES
PL-1	MANUFACTURER: FORMICA PRODUCT: GENERAL PURPOSE GRADE LAMINATE (HGS) PATTERN: FOSSIL FINISH: MATTIE NOTE: WHITE MELAMINE INTERIOR AT ALL EXPOSED SURFACES LOCATION: LOWER VERTICAL CASEWORK
PL-2	MANUFACTURER: FORMICA PRODUCT: GENERAL PURPOSE GRADE LAMINATE (HGS) PATTERN: FOSSIL FINISH: PLEX FINISH NOTE: WHITE MELAMINE INTERIOR AT ALL EXPOSED SURFACES LOCATION: UPPER VERTICAL CASEWORK
PL-3	MANUFACTURER: FORMICA PRODUCT: GENERAL PURPOSE GRADE LAMINATE (HGS) PATTERN: PORTICO MARBLE FINISH: MATTIE NOTE: COUNTERTOP LOCATION: SEE ELEVATIONS
PL-4	MANUFACTURER: FORMICA PRODUCT: GENERAL PURPOSE GRADE LAMINATE (HGS) PATTERN: FDG FINISH: MATTIE LOCATION: SEE ELEVATIONS
WALL PROTECTION	SECTION 10 2600
WC-1	MANUFACTURER: CARNEGIE PRODUCT: XOREL WALL PROTECTION PATTERN: DOVER 8123-11 BACKING: X-PROTECT WALL BACKING SIZE: 54" W SEE ELEVATIONS LOCATION: SIM LABS
WC-2	MANUFACTURER: CARNEGIE PRODUCT: XOREL WALL PROTECTION PATTERN: DOVER 8123-12 BACKING: X-PROTECT WALL BACKING SIZE: 54" W SEE ELEVATIONS LOCATION: SIM LABS
COUNTERTOPS	SECTION 12 3600
CT-1	MANUFACTURER: WILSONART PRODUCT: THINSCAPE - COMPOSITE COUNTERTOP GAUGE: 1/2 THICK EDGE: KNIFE EDGE COLOR: SPANISH LESTONE CORE COLOR: GREY FINISH: SB (SANDBLAST) SIZE: 5X12 SLAB NOTE: CUT SLAB INTO TWO COUNTERTOPS AND BACKSLASH FOR SIM LABS LOCATION: SIM LABS

CARPET	SECTION 09 6813
CPT-1	MANUFACTURER: PATCRAFT PRODUCT: CARPET TILE COLLECTION: COLOUR & TEXTURE FUSION STYLE: 10025 IMMERSIVE COLOR: 00100 MIST SIZE: 24X24 PATTERN: ASHLAR PATTERN LOCATION: DEBRIEF RM NOTE: TRANSITION STRIP - PROFILITEC: SELF ADHESIVE MS 26
CPT-2	MANUFACTURER: PATCRAFT PRODUCT: CARPET TILE COLLECTION: COLOUR & TEXTURE FUSION STYLE: 10025 IMMERSIVE COLOR: 00120 GLAZE SIZE: 24X24 PATTERN: ASHLAR PATTERN LOCATION: DEBRIEF RM NOTE: TRANSITION STRIP - PROFILITEC: SELF ADHESIVE MS 26
RESILIENT FLOORING	SECTION 09 6500
RF-1	MANUFACTURER: INTERFACE PRODUCT: NORA STYLE: NORAMENT 926 PADO COLOR: 5501 NATURAL SIZE: 40X40 TILE THICKNESS: 3.5MM NOTE: COLD WELD 5301 PATTERN: QUARTER TURN LOCATION: SIM LAB
RF-2	MANUFACTURER: INTERFACE PRODUCT: NORA STYLE: NORAPLAN CONVIA COLOR: 7300 STONE KHAKI SIZE: SHEET THICKNESS: 2.0 MM NOTE: COLD WELDING 7053 / HEAT WELD ROD COLOR 7053 LOCATION: STORAGE ROOMS, CONTROL ROOMS
RUBBER BASE AND TREADS	SECTION 09 6500
RB-1	MANUFACTURER: NORA PRODUCT: WALL BASE (THERMOPLASTIC RUBBER) PROFILE: COVE COLOR: DOVE GRAY 6233 SIZE: 4"
RB-2	MANUFACTURER: NORA PRODUCT: WALL BASE (THERMOPLASTIC RUBBER) PROFILE: COVE COLOR: SILVER SIZE: 4"
ACOUSTIC CEILING TILE	SECTION 09 5100
ACT-1	MANUFACTURER: ARMSTRONG PRODUCT: ULTIMA SQUARE LAY IN #1943 NRC: 0.75 & CAC 35 FINISH: FINE TEXTURE SIZE: 24X24 SUSPENSION SYSTEM: PRELUDE XL 5/16" WHITE LOCATION: SEE RCP
FIBER REINFORCED PLASTIC	SECTION 09 9316
FRP-1	MANUFACTURER: INPRO PRODUCT: FRP WALL PANEL STYLE: SMOOTH RATING: CLASS A THICKNESS: 0.075" COLOR: FEATHER SIZE: 48"W PROVIDE MATCHING TOP VINYL TRIM, ADHESIVE TO MATCH AT VERTICAL SEAMS. LOCATION: STORAGE ROOM / HALLWAY

FRP-2 (ALTER FOR WC)

CORNER GUARDS


CG- (TYP-1)	MANUFACTURER: INPRO MODEL: SURFACE MOUNT STAINLESS STEEL CORNER GUARD MOUNTING: CEMENT-ON GAUGE: 16 GA LEGS: 1 1/2" OVERALL HEIGHT: 6" UNO. INSTALL ABOVE BASE NOTE: BASE OF DESIGN
-------------	--

WINDOW SHADES	SECTION 12 2400
---------------	-----------------

RS-1	MANUFACTURER: MECOSYSTEMS PRODUCT: MECOHO S- SINGLE SHADE ROLLER FABRIC: SCHÖ 1600 SERIES OPENESS: 3% COLOR: LIGHT GRAY
------	---

PAINT AND COATINGS	SECTION 09 9123
--------------------	-----------------


P-1	MANUFACTURER: BENJAMIN MOORE TYPE: LATEX COLOR: CASCADE MOUNTAINS FINISH: SATIN LOCATION: GENERAL PAINT COLOR
P-2	MANUFACTURER: BENJAMIN MOORE TYPE: LATEX COLOR: BLUE VEIL FINISH: SATIN LOCATION: SIM LABS
P-3	MANUFACTURER: BENJAMIN MOORE TYPE: LATEX COLOR: ICEBERG FINISH: SATIN LOCATION: DEBRIEF RM 1
P-4	MANUFACTURER: BENJAMIN MOORE TYPE: LATEX COLOR: BUXTON BLUE FINISH: SATIN NOTE: ACCENT PAINT LOCATION: DEBRIEF RM 1
P-5	MANUFACTURER: BENJAMIN MOORE TYPE: LATEX COLOR: SMOKY GREEN FINISH: SATIN LOCATION: DEBRIEF RM 2
P-6	MANUFACTURER: BENJAMIN MOORE TYPE: LATEX COLOR: GRENADEIR POND FINISH: SATIN LOCATIONS: DEBRIEF RM 2
P-7	MANUFACTURER: BENJAMIN MOORE TYPE: LATEX COLOR: TO MATCH WALL PAINT COLOR FINISH: SATIN LOCATIONS: DOOR TRIMS / WINDOW TRIMS @ ALL LOCATION UNO
P-8	MANUFACTURER: BENJAMIN MOORE TYPE: LATEX COLOR: BENNINGTON GRAY HC-82 FINISH: SATIN LOCATIONS: SEE FINISH PLAN

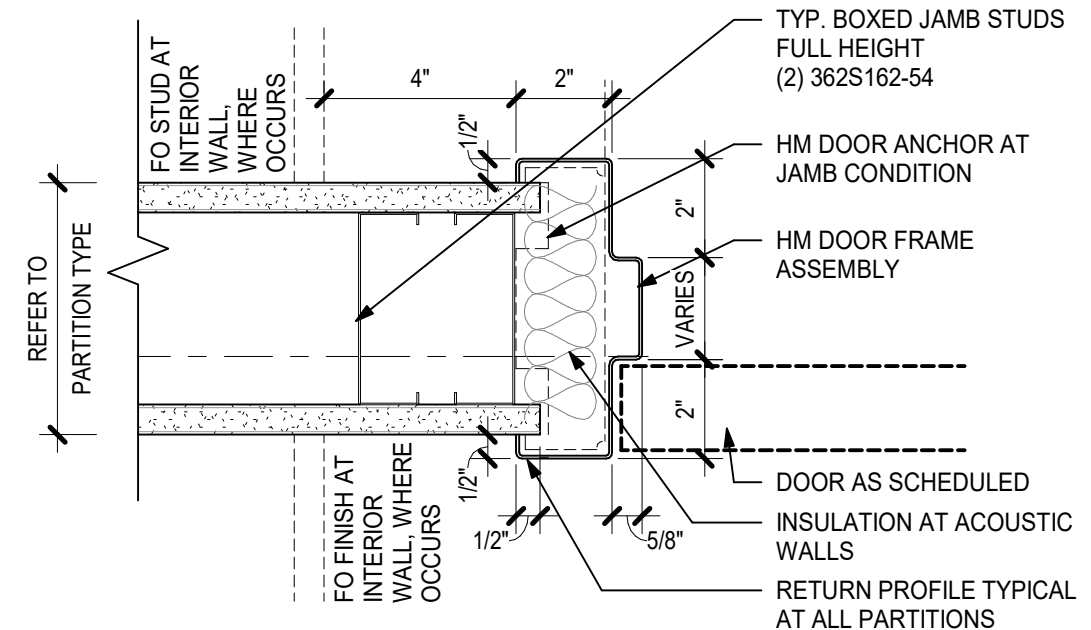

- TYPICAL HOLLOW METAL FRAME INFORMATION:
1. SEE WALL TYPE FOR STUD WIDTH
2. FRAME THROAT IS TO BE SIZED TO RECEIVE FULL PARTITION THICKNESS UNLESS DETAILED OTHERWISE.


2 HM JAMB-DOOR-INT

A801 (3" = 1'-0")

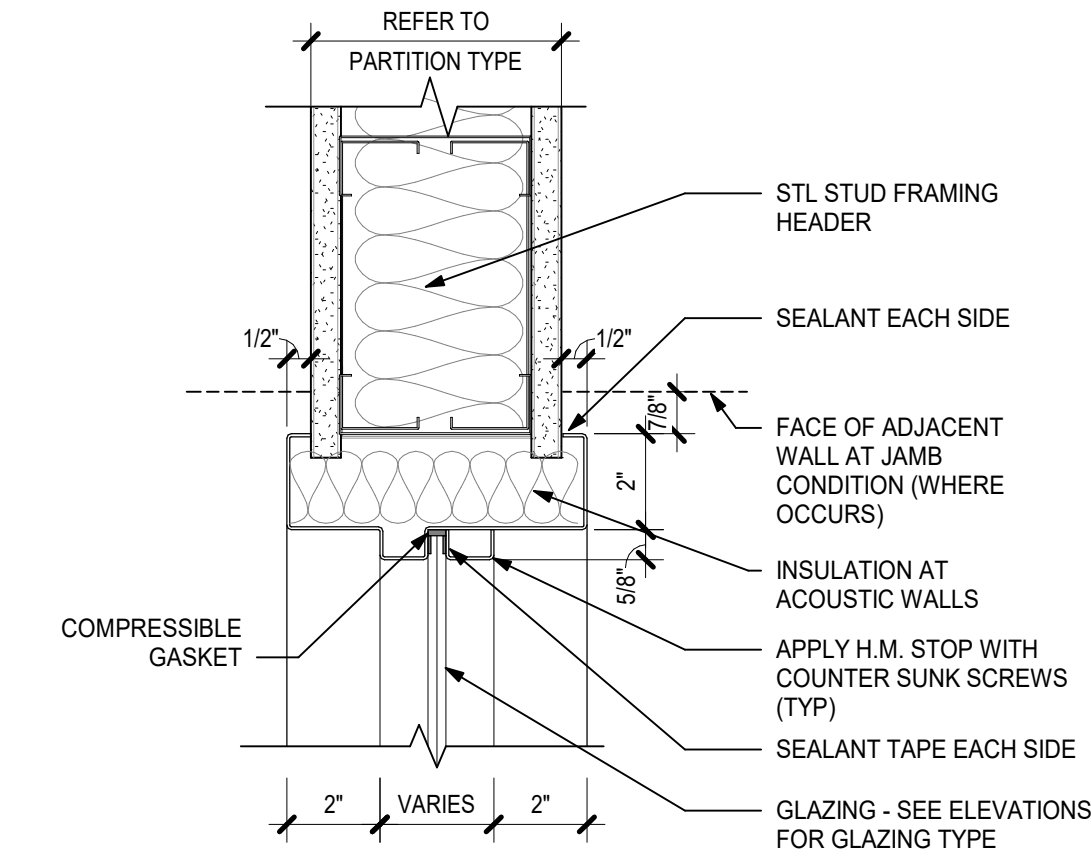

3 HM JAMB-WINDOW-INT

A801 (3" = 1'-0")

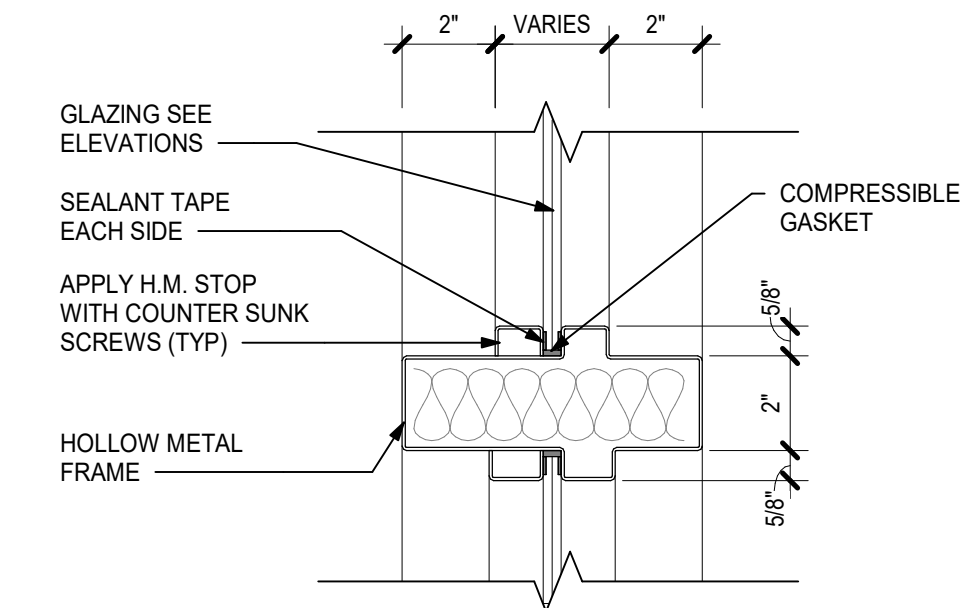

4 HM MULLION-WINDOW-INT

A801 (3" = 1'-0")

SHEET NOTES

- VERIFY IN FIELD ALL ROUGH OPENING DIMENSIONS
- NO FLOOR TRANSITIONS WHERE FLOORING IS LEVEL, BETWEEN DISSIMILAR FLOORING MATERIALS PROVIDE TRASTION STRIP
- WHERE NOT INDICATED, TRANSITION IS TO OCCUR CENTERED UNDER DOOR
- SEE FLOOR PLAN / ELEVATIONS FOR MONITOR, TACKBOARD, AND MARKERBOARD LOCATIONS
- PAINIT ALL EXPOSED SPRINKLES, HVAC WHITE TO MATCH CEILING.
- ALL OUTLETS, SWITCH COVERS, GRILLS FINISH COLORS WHITE.

FINISH ABBREVIATIONS:


ACT	ACOUSTIC CEILING TILE
AP	ACOUSTIC PANEL
CPT	CARPET TILE
CT	COUNTER TOP
FRP	FIBERGLASS-REINFORCED PLASTIC
G	GRAPHIC
GYP	GYPSUM WALL BOARD
LVT	LUXURY VINYL TILE
MM	MELAMINE
P	PAINT
PC	POLISHED CONCRETE
PHEN	PHENOLIC PANEL
PLAM	PLASTIC LAMINATE
PRF	POURED RESINOUS FLOORING / FLUID APPLIED FLOORING
RB	RESILIENT BASE
RF	RESILIENT FLOORING
SC	SEALED CONCRETE
SURF	SOLID SURFACE
ST	STAIR TREAD
SV	SHEET VINYL
TB	TACKBOARD
WD	WOOD GRILLE
WGF	WOOD GYM FLOORING
WOM	WALK-OFF MAT

FINISH SCHEDULE NOTES

- PATTERN - VERTICAL INSTALL
- CPT-1: WALLCOVERING AS PROTECTION @ FULL WALL. OPT-2: COMPARE PRICING FOR 4" FRP W/ WALLCOVERING ABOVE.
- 36" FRP WALL PROTECTION
- WINDOW COVERING @ ALL EXTERIOR WINDOWS. SEE A401 FOR LOCATION.
- REMOVE EXISTING BASE, PREP / REFINISH EXISTING WALL FOR NEW FINISH.

LEGEND


	ORIENTATION OF FLOORING PLANK OR TILE IN ROOM
	CORNER GUARD
	FLOOR TRANSITION
	FLOOR FINISH TAG
	PAINT LINE
	NOT IN SCOPE
	CPT-1
	CPT-2
	RF-1
	RF-2
	RF-3

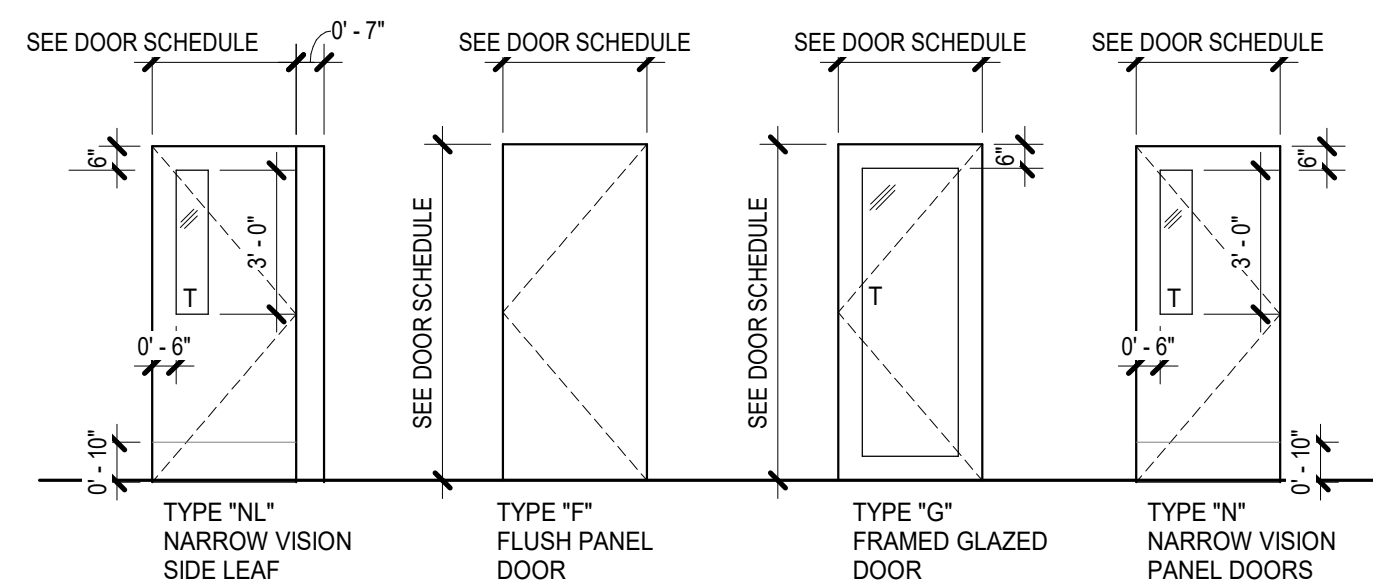

LEGEND - DOOR TYPES


DOOR AND FRAME SCHEDULE														
TO: ROOM NUMBER	MARK	OPENING SIZE		DOORS				FRAMES				HARDWARE SET	DR-Ja mb	NOTES
		WIDTH	HGT.	TYPE	MAT	FIN		TYPE	MAT	FIN				
1.452	1.452	3'-0"	7'-0"	G	WD	P-X	HM	HM	P-X					FULL GLAZE
1.452a	1.452a	3'-0"	7'-0"	N	WD	P-X	HM	HM	P-X					6"W LITE
1.454a	1.454	4'-0"	7'-0"	N	WD	P-X	HM	HM	P-X					8"W LITE
1.455	1.455	3'-0"	7'-0"	F	WD	P-X	HM	HM	P-X					SOLID
1.456a	1.456	3'-0"	7'-0"	NL	WD	P-X	HM	HM	P-X					6"W LITE W SIDE LEAF
1.457	1.457	3'-0"	7'-0"	G	WD	P-X	HM	HM	P-X					FULL GLAZE
1.457	1.457a	3'-6"	7'-0"	N	WD	P-X	HM	HM	P-X					8"W LITE

ROOM FINISH SCHEDULE												
ROOM #	ROOM NAME	FLOOR	BASE	WALLS				CEILING	CASEWORK FINISH CODE* (SEE NOTES)	MISC		
				NORTH	EAST	SOUTH	WEST					
1.452	DEBRIEF-1	CPT-1	RB-1	P-3	P-3	P-4	P-4	ACT-1				
1.452a	STOR-1	RF-2	RB-1	P-1, FRP-1	P-1, FRP-1	P-1, FRP-1	P-1	OTS		3		
1.454a	SIM-1	RF-1	RB-2	P-2	P-2	P-2	WC-2,P-2	ACT-1	PL-2, PL-3, CT-1	1.2		
1.454b	SIM-2	RF-1	RB-2	P-2	P-2	P-2	WC-2,P-2	ACT-1		1.2, 4		
1.455	CONTROL RM	RF-2	RB-1	P-1	P-1	P-1	P-1	ACT-1	CT-1, PL-3	4		
1.456a	SIM-3	RF-1	RB-2	P-2	P-2	P-2	WC-1	ACT-1	PL-1, PL-2, CT-1	1.2		
1.456b	SIM-4	RF-1	RB-2	P-2	P-2	P-2	WC-1	ACT-1		1.2, 4		
1.457	DEBRIEF-2	CPT-2	RB-1	P-5	P-5	P-6	P-6	ACT-1	PL-3, PL-4	3		
1.457a	STOR-2	RF-2	RB-1	P-1	P-1, FRP-1	P-1	P-1, FRP-1	OTS		4		
A178	EXISTING	NOT IN SCOPE	RB-2	---	P-8	P-8	---	NOT IN SCOPE		5		

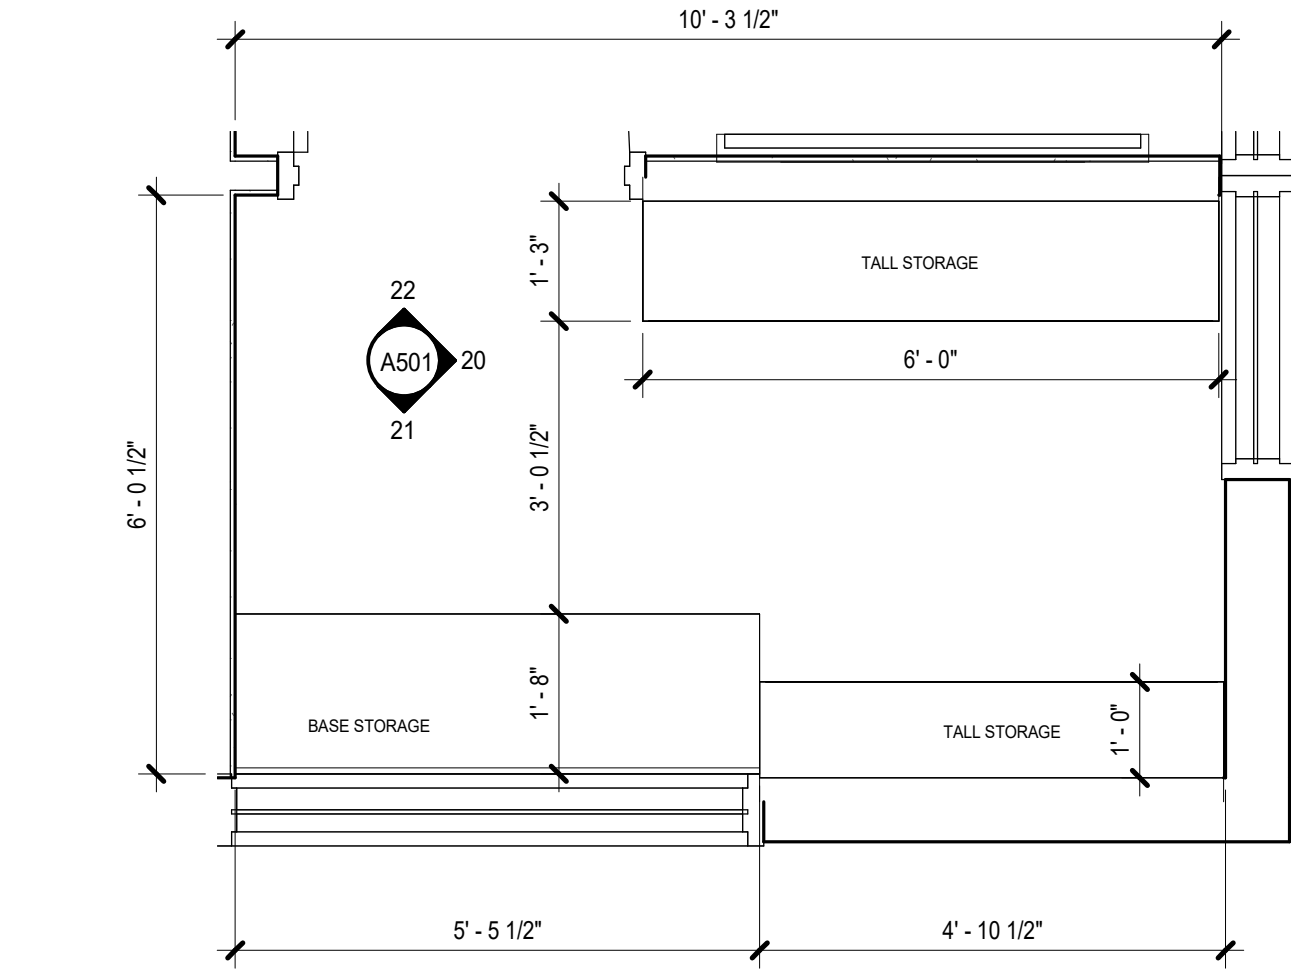


1 STORAGE RM - MED CASEWORK

A802 (1/2" = 1'-0")

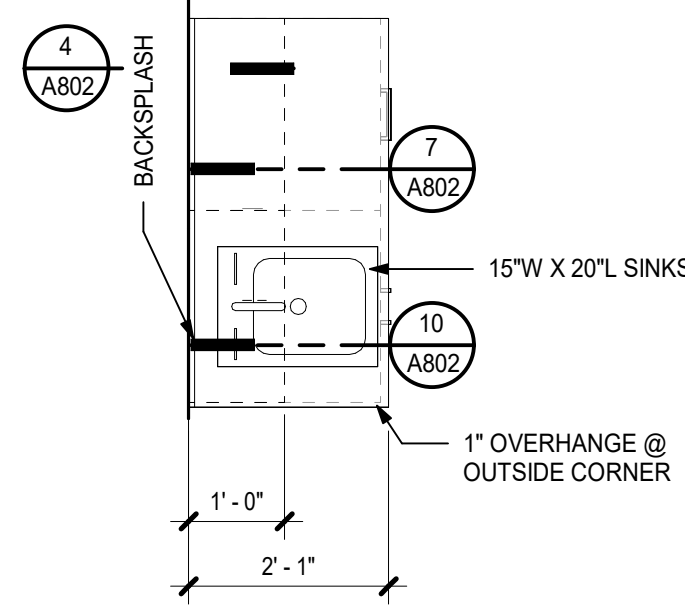


3 TYPICAL CASEWORK PLAN

A802 (1/2" = 1'-0")

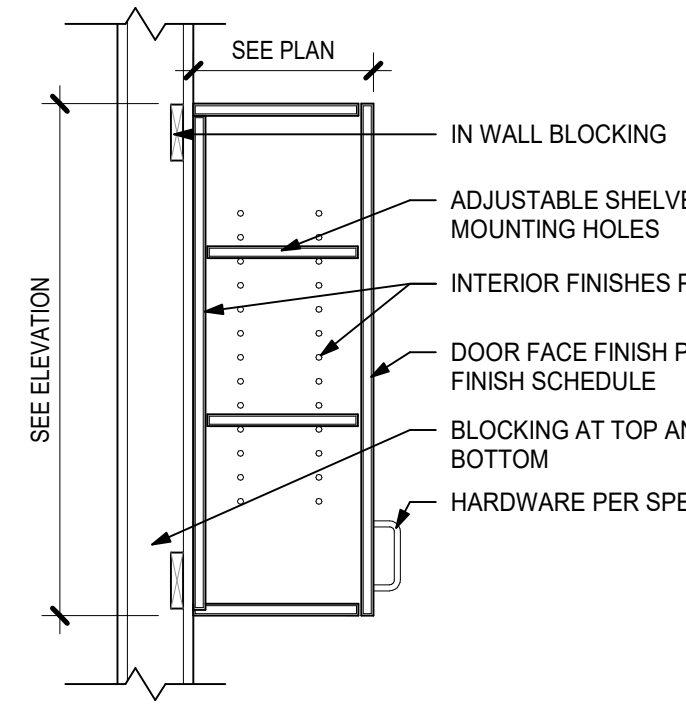


4 WALL CABINET

A802 (1" = 1'-0")

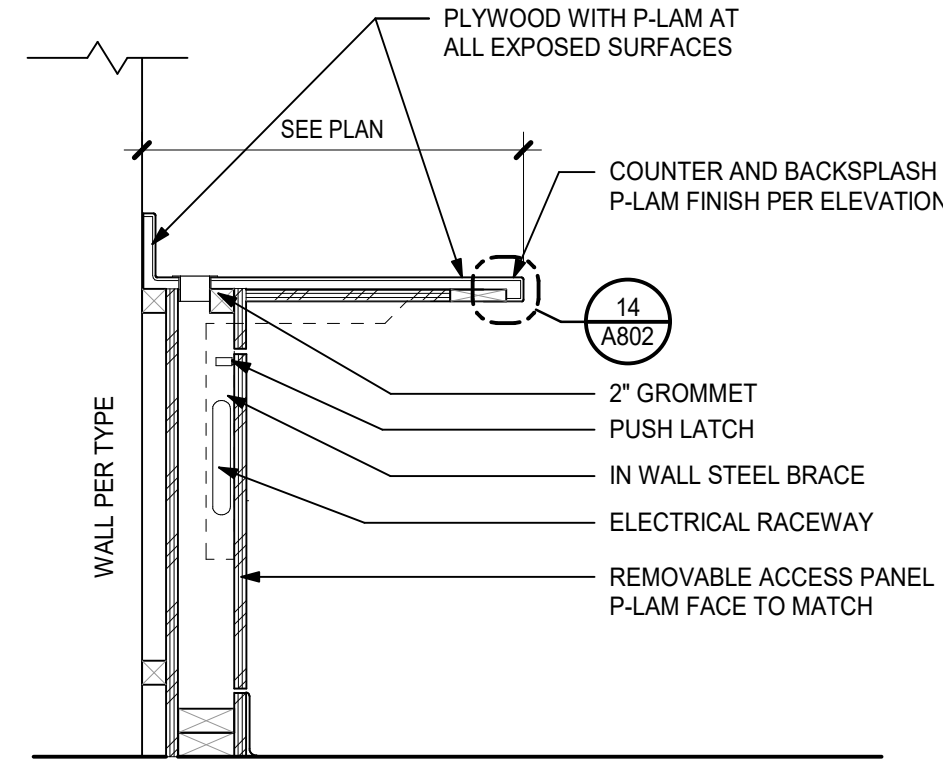


5 OPEN COUNTER

A802 (1" = 1'-0")

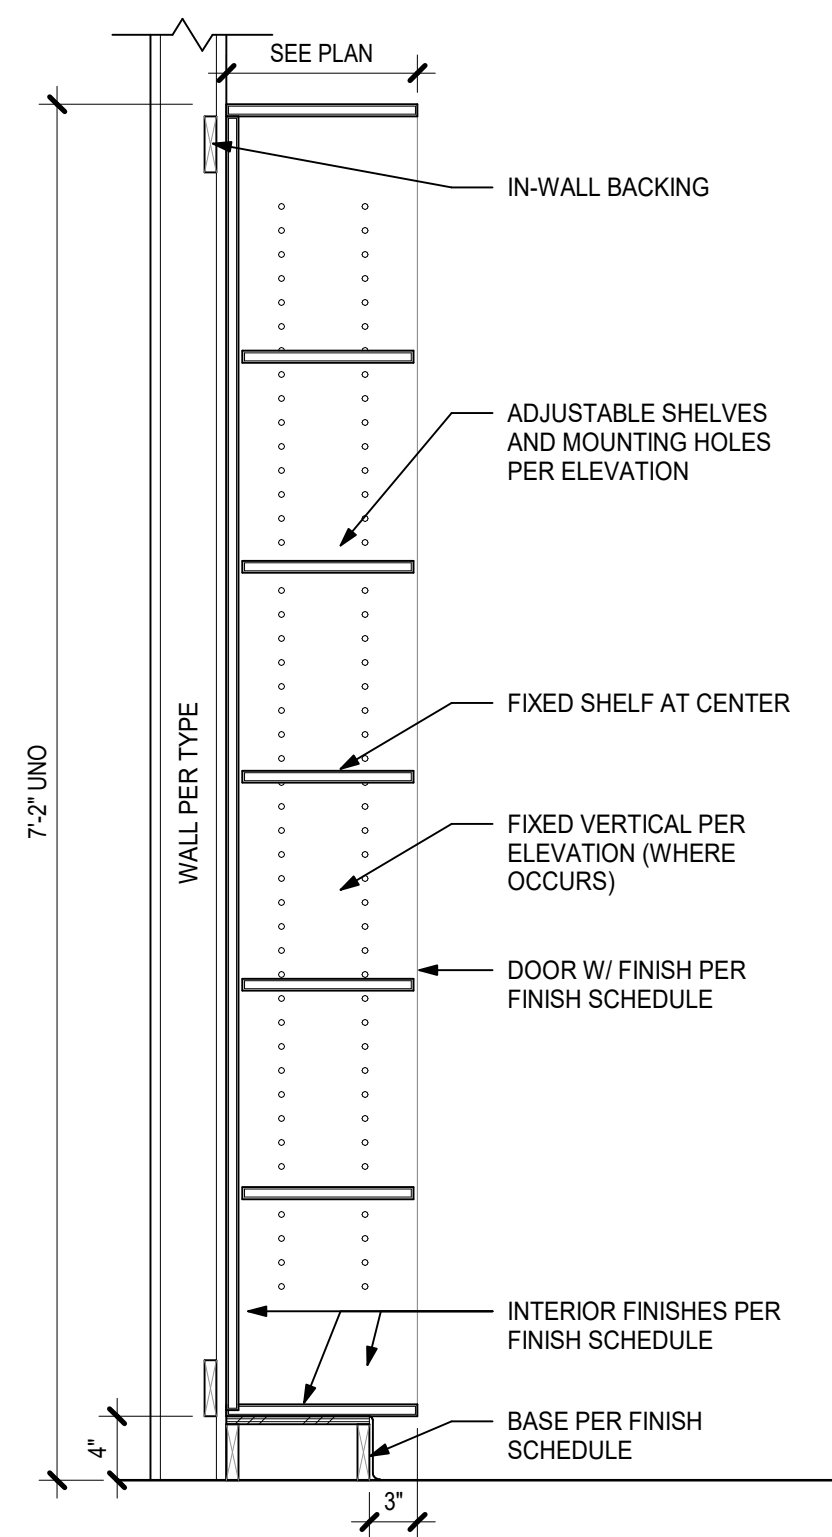


8 TALL CABINET

A802 (1" = 1'-0")

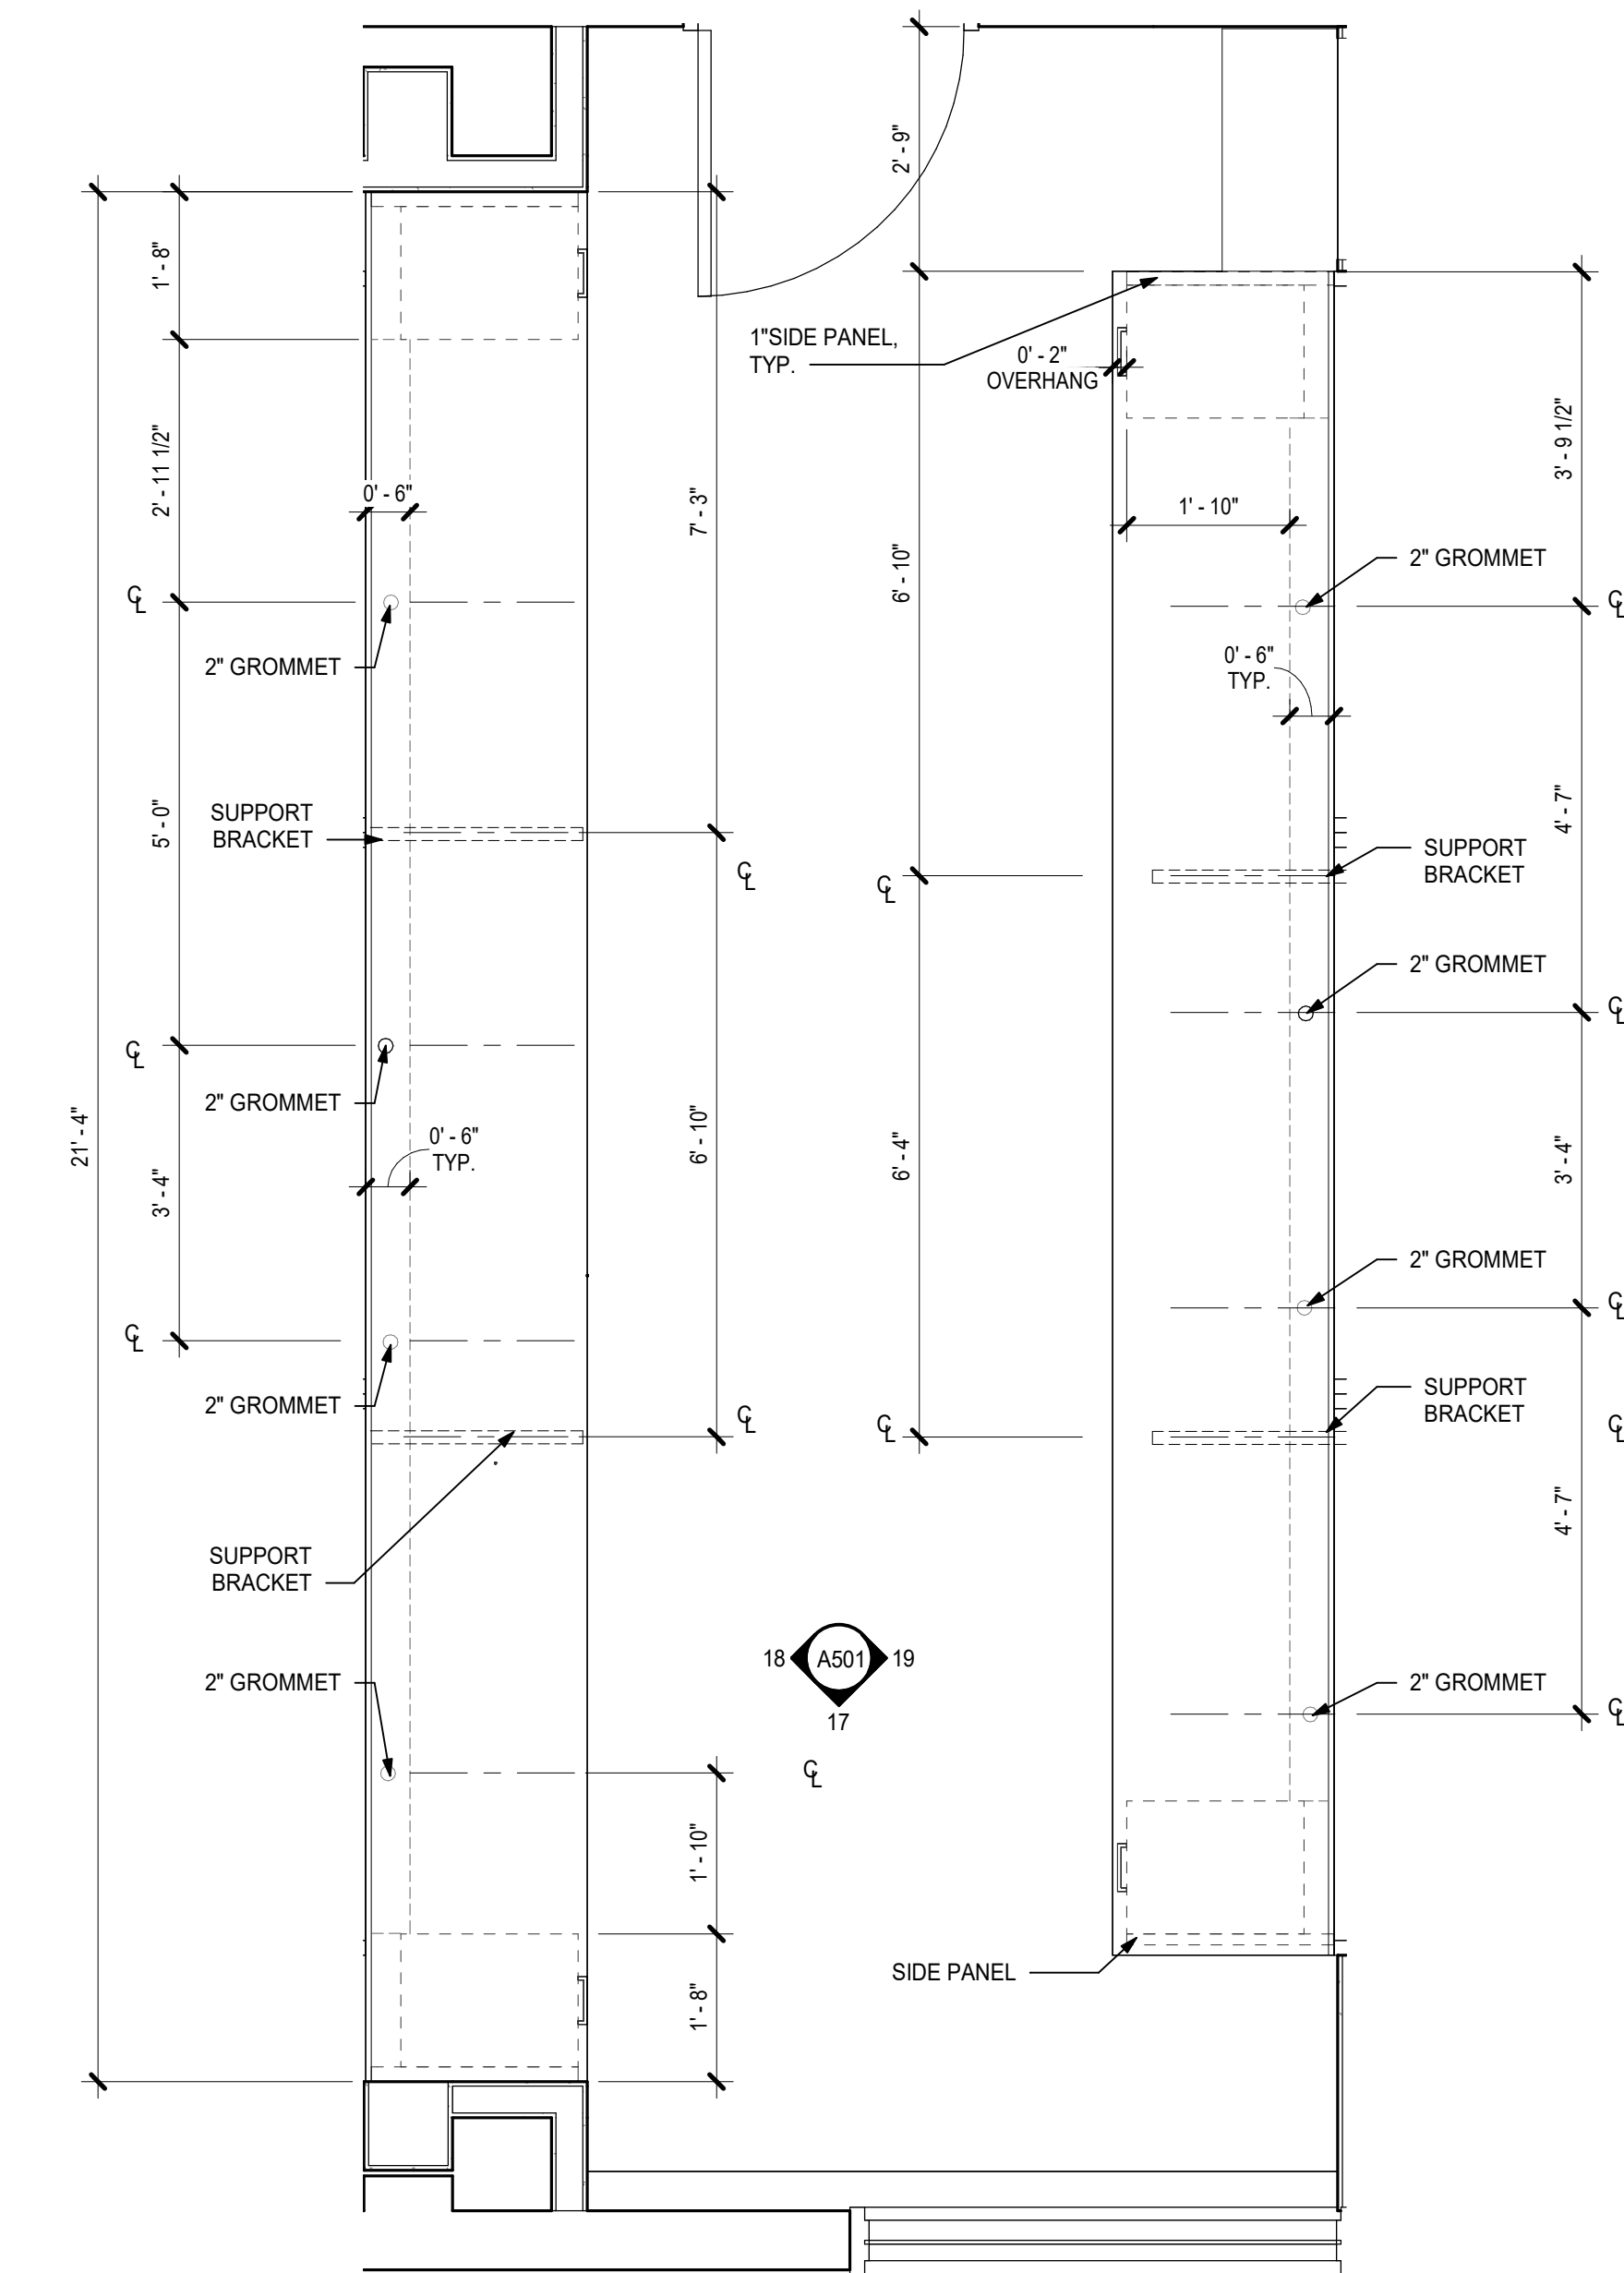


2 CONTROL RM CASEWORK

A802 (1/2" = 1'-0")

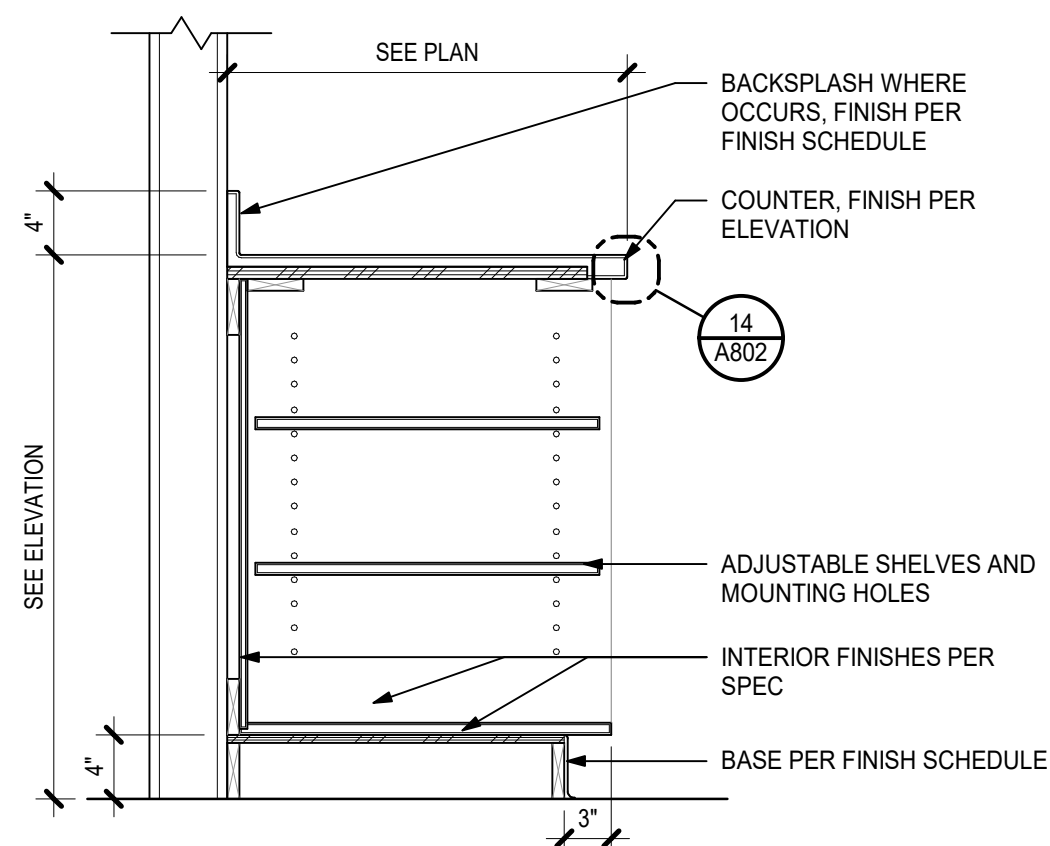


6 OPEN CABINET

A802 (1" = 1'-0")

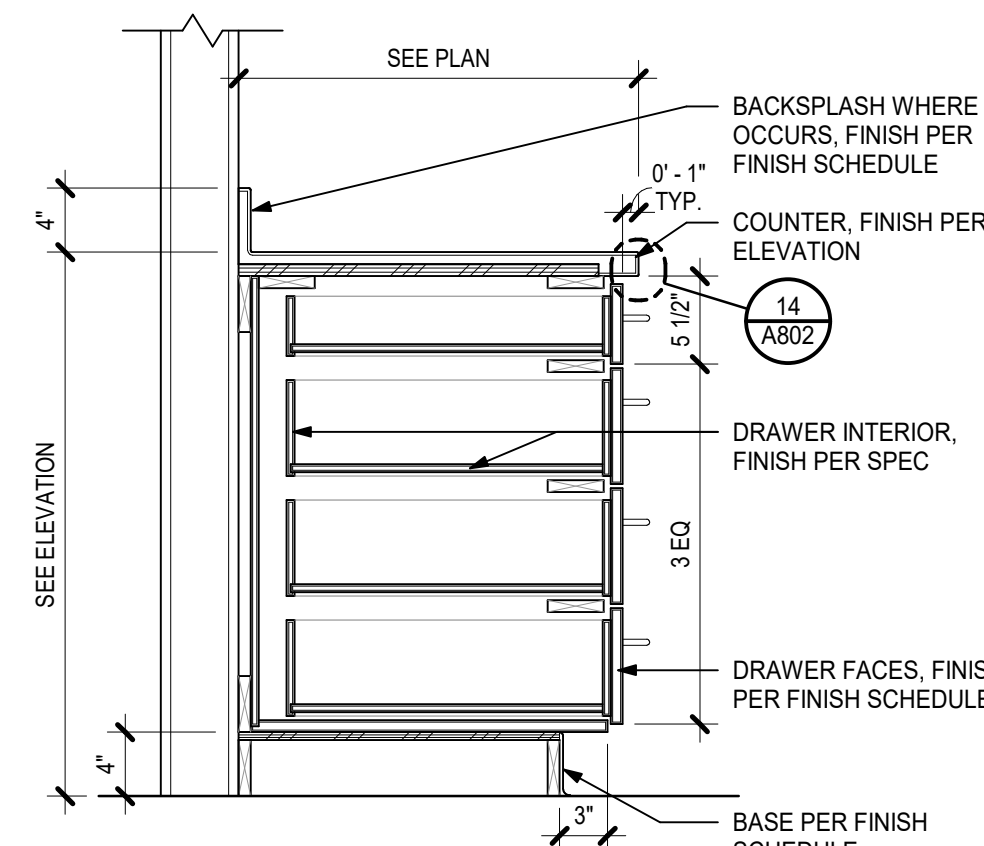


7 4 DRAWER CABINET

A802 (1" = 1'-0")

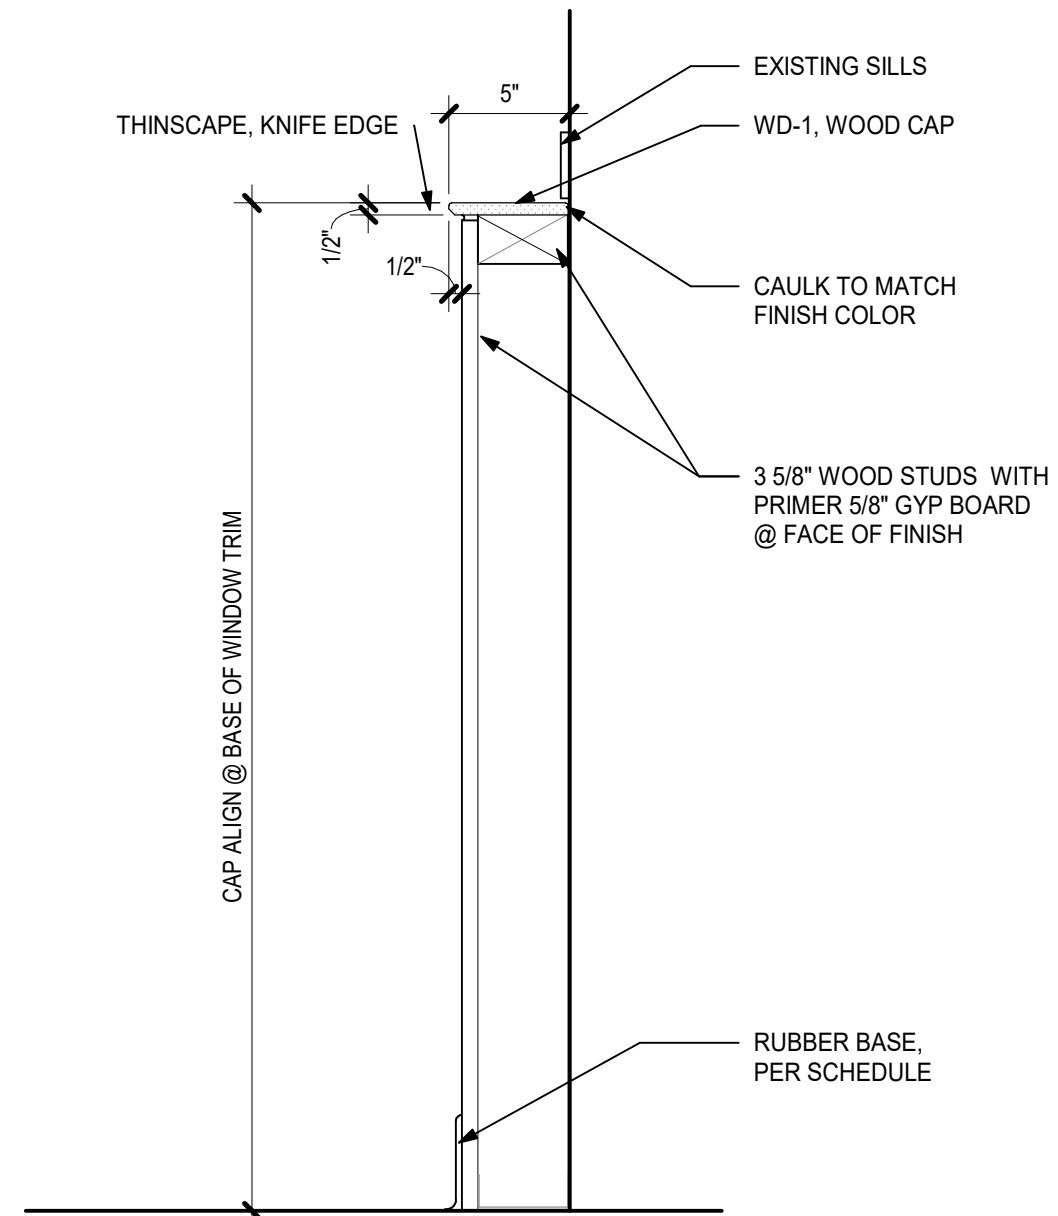


11 WALL CAP

A802 (1 1/2" = 1'-0")

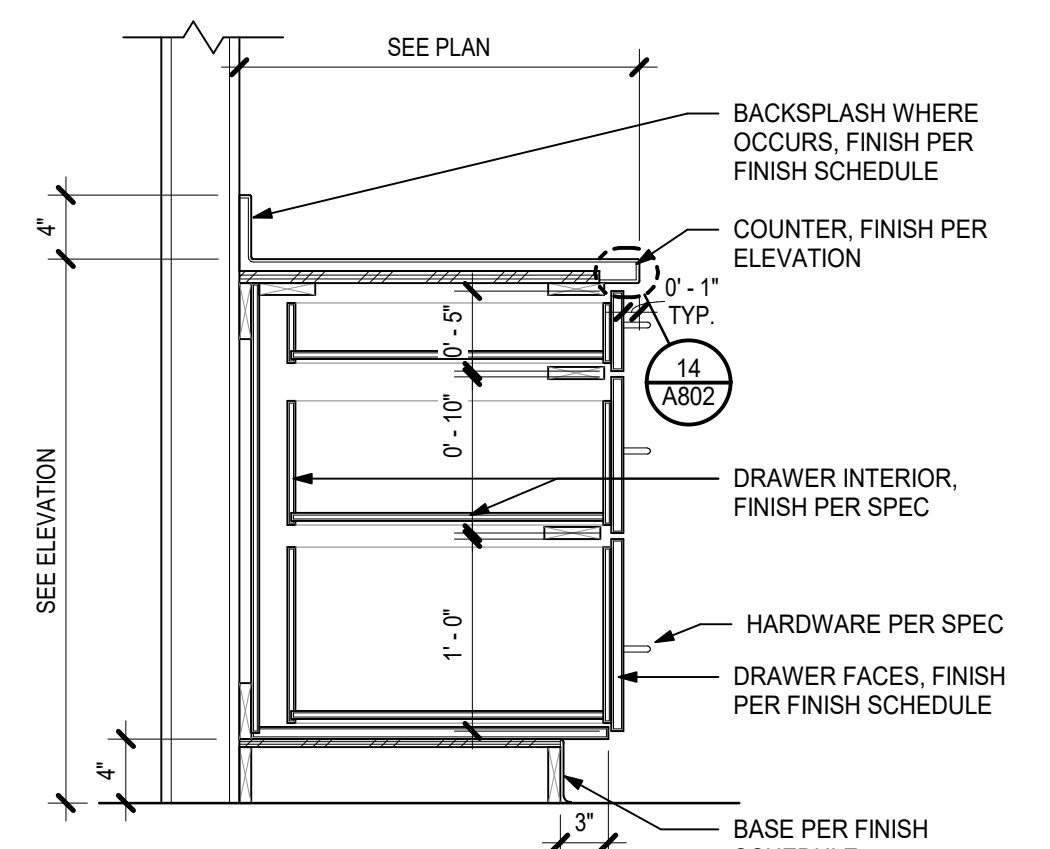


9 3 DRAWER CABINET

A802 (1" = 1'-0")

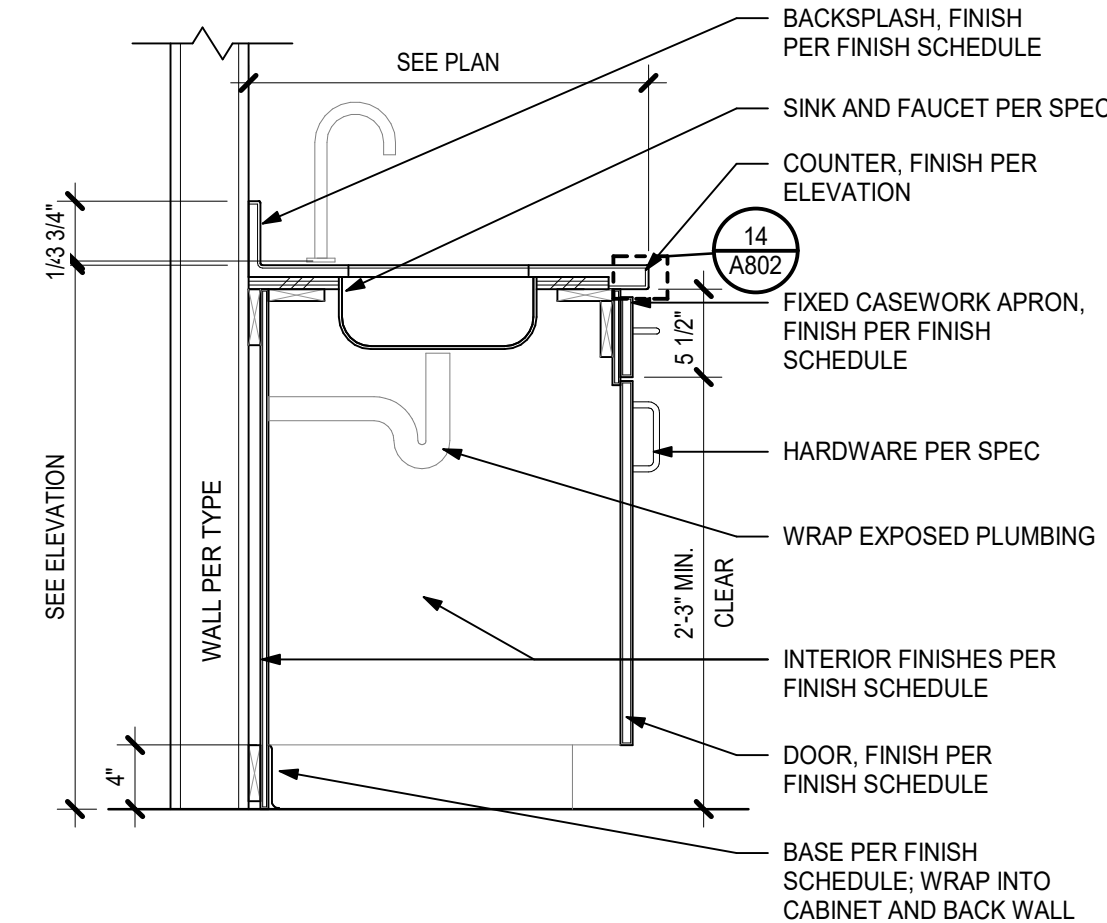


10 BASE CABINET

A802 (1" = 1'-0")

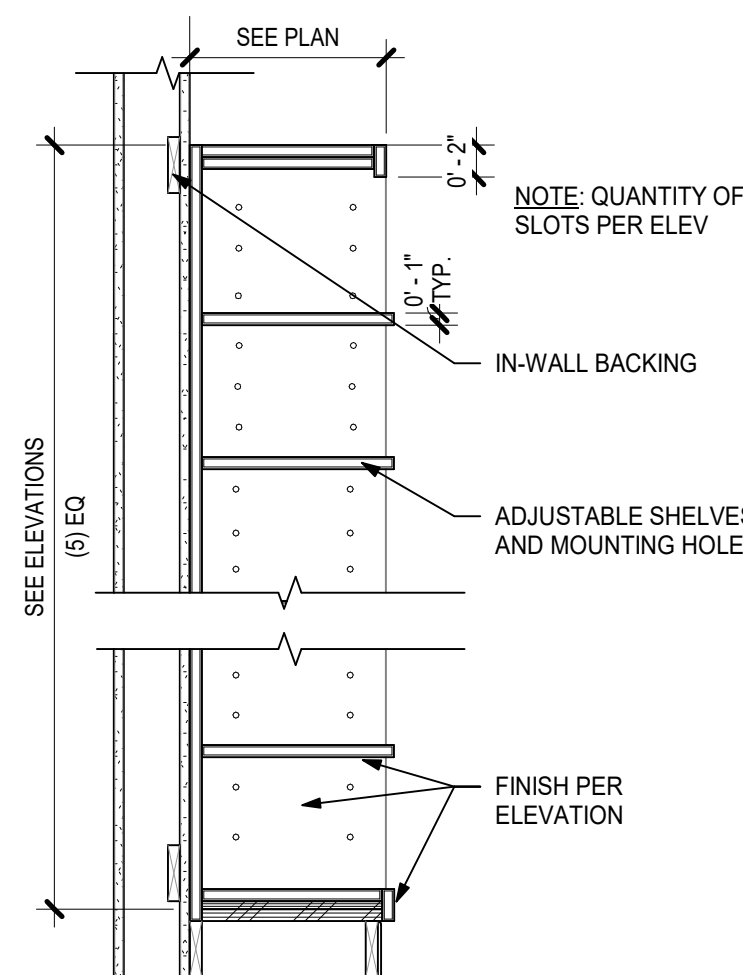


12 BOOK SHELF

A802 (1" = 1'-0")

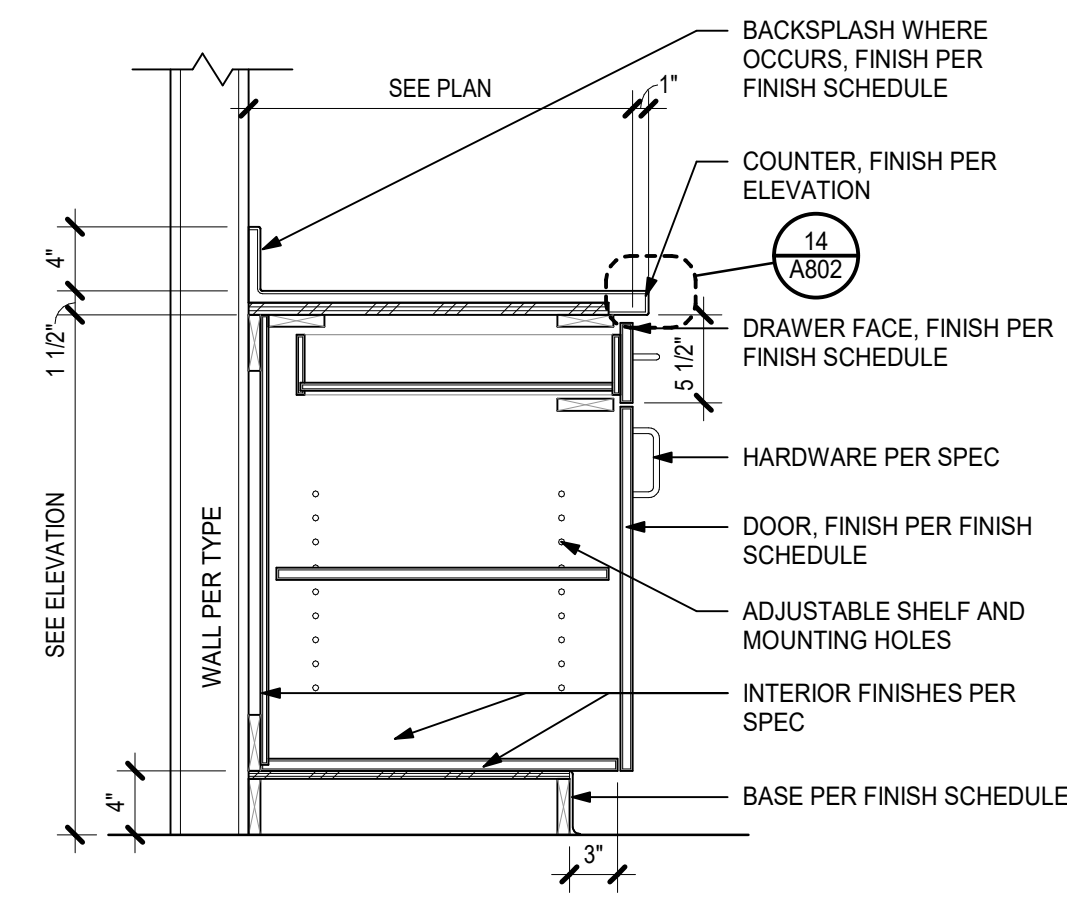

13 BASE CABINET

A802 (1" = 1'-0")

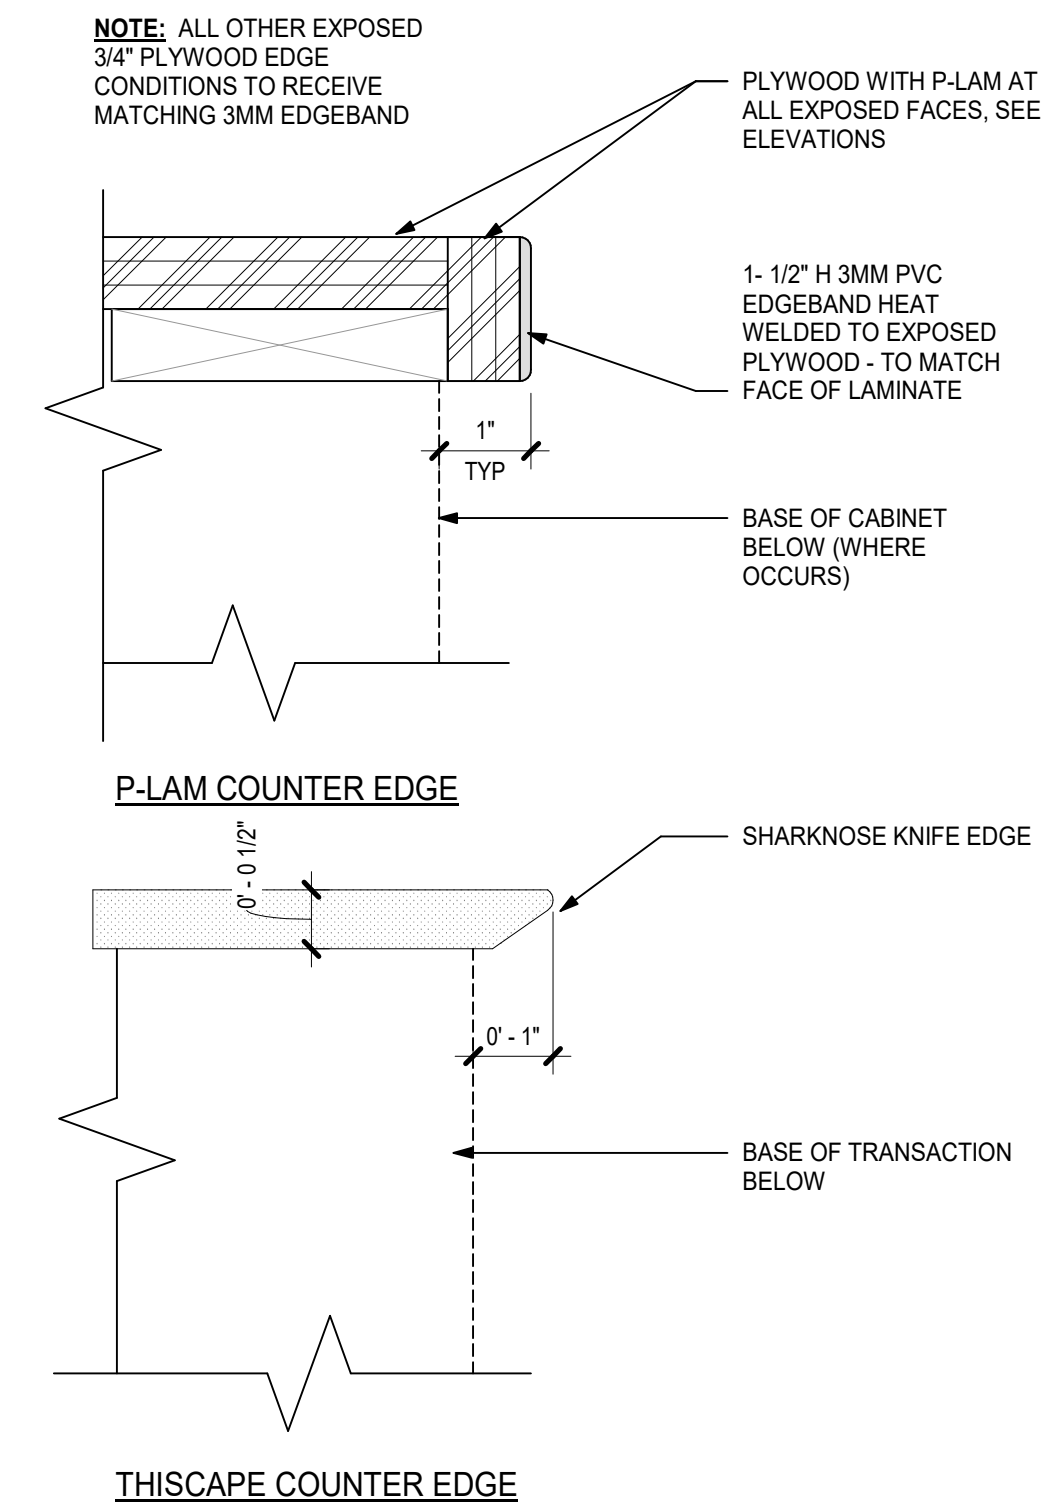

14 COUNTER DETAIL

A802 (6" = 1'-0")

