


SITE PLAN AND VICINITY MAP

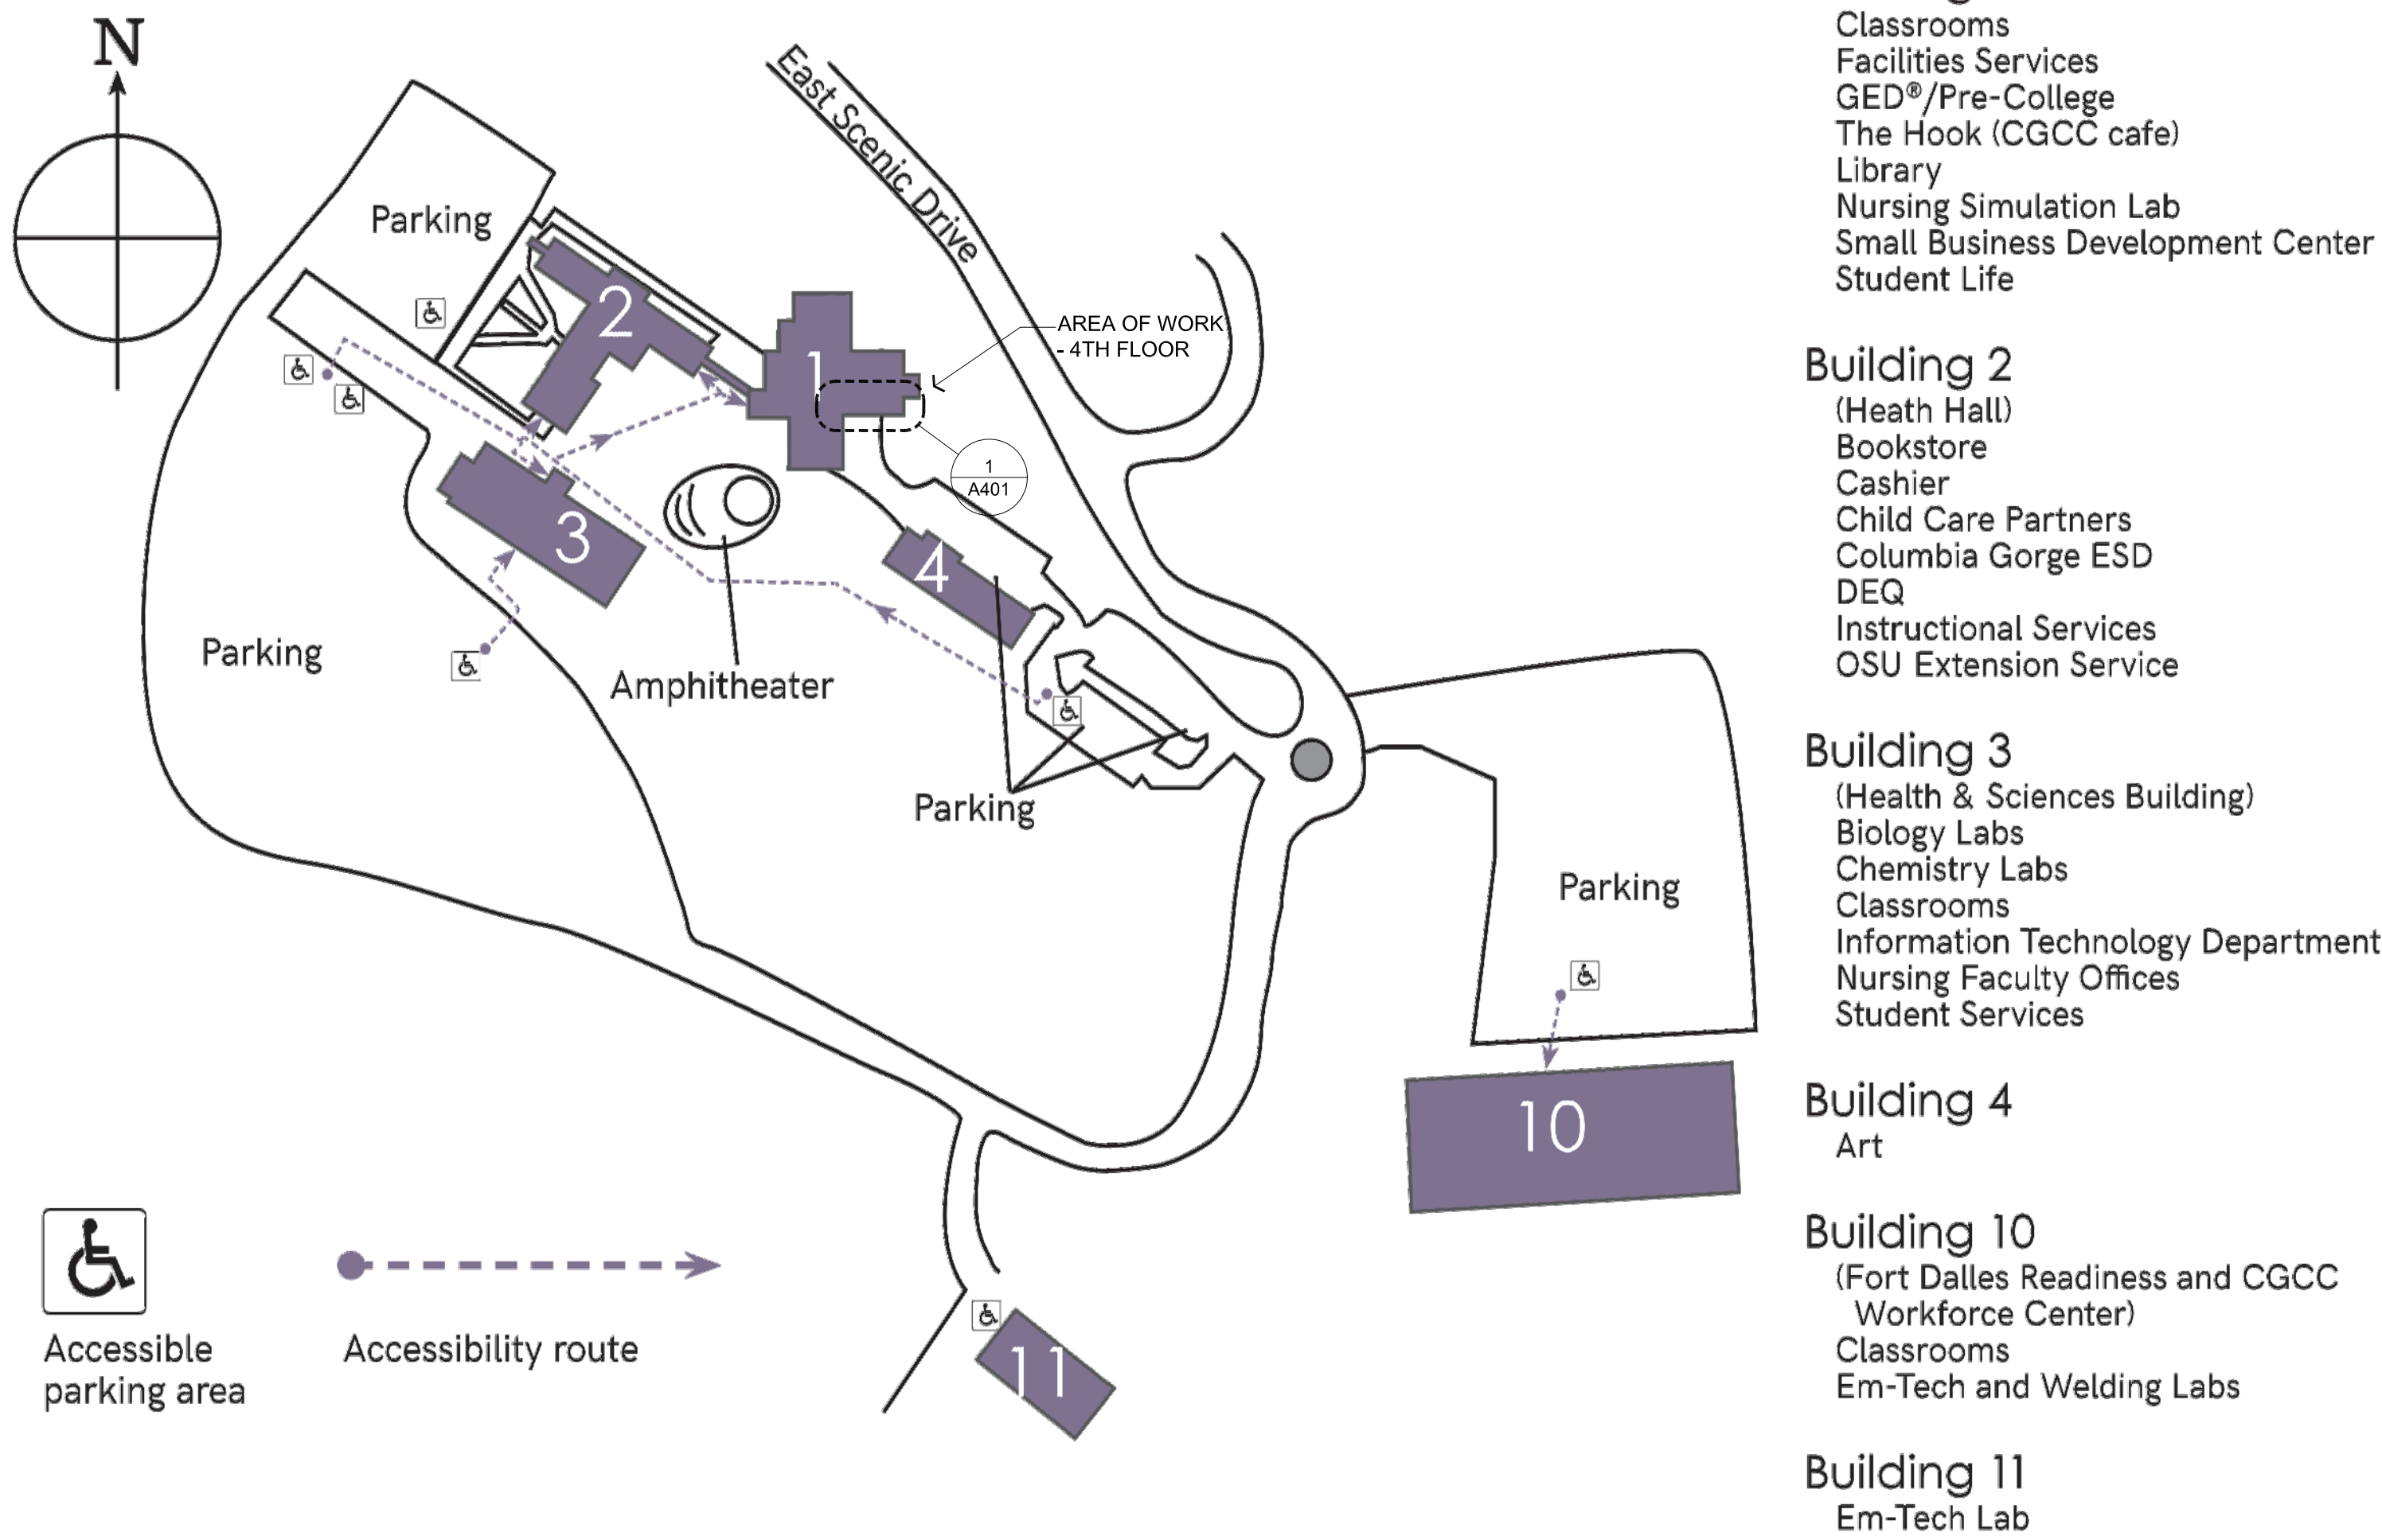

Building 1
Classrooms
Facilities Services
GED®/Pre-College
The Hook (CGCC cafe)
Library
Nursing Simulation Lab
Small Business Development Center
Student Life

Building 2
(Heath Hall)
Bookstore
Cashier
Child Care Partners
Columbia Gorge ESD
DEQ
Instructional Services
OSU Extension Service

Building 3
(Health & Sciences Building)
Biology Labs
Chemistry Labs
Classrooms
Information Technology Department
Nursing Faculty Offices
Student Services

Building 4
Art

Building 10
(Fort Dalles Readiness and CGCC
Workforce Center)
Classrooms
Em-Tech and Welding Labs

Building 11
Em-Tech Lab

DRAWING INDEX

DWG #	NAME	SD	DD	CD
	GENERAL			
G000	COVER, SITE PLAN, VICINITY MAP	X	X	X
	PROJECT TEAM, DRAWING INDEX			
A201	OVERALL FLOOR PLAN & CODE ANALYSIS	X	X	X
A401	ENLARGED DEMO & FLOOR PLANS	X	X	X
A501	INTERIOR ELEVATIONS	X	X	X
A601	REFLECTED CEILING PLAN & DETAILS	X	X	X
A801	SCHEDULES & DETAILS	X	X	X
A802	DETAILS	X	X	X
A901	FINISH FLOOR PLAN	X	X	X
A902	INTERIOR DETAILS			X
	MECHANICAL			
M001	GENERAL NOTES, ABBREVIATIONS		X	X
M401	PARTIAL MECHANICAL FLOOR PLAN		X	X
M402	PARTIAL MECHANICAL DEMO PLAN		X	X
P001	PLUMBING COVER SHEET		X	X
P401	PARTIAL PLUMBING FLOOR PLAN		X	X
P402	PARTIAL PLUMBING DEMO PLAN		X	X
	ELECTRICAL			
E001	ELECTRICAL ABBREVIATIONS & SYMBOLS LEGEND		X	X
E002	LUMINAIRE SCHEDULE		X	X
ED201	DEMOLITION ELECTRICAL CEILING PLAN		X	X
ED202	DEMOLITION ELECTRICAL FLOOR PLAN		X	X
E201	LIGHTING PLAN		X	X
E202	POWER FLOOR PLAN		X	X
E203	LOW VOLTAGE FLOOR PLAN		X	X
E204	FIRE ALARM FLOOR PLAN		X	X
E300	PANEL SCHEDULES		X	X

GENERAL NOTES:

- PROJECT CONSISTS OF A 1785 SF INTERIOR REMODEL ON THE 4TH FLOOR CONVERTING CLASSROOM SPACE INTO NURSING SIMULATION LABS.
- WORK INCLUDES FINISHES, NEW PARTITIONS, DOORS, CEILINGS, LIGHTING & POWER, WITH ALTERED LOCATIONS OF HVAC GRILLES AND SPRINKLER HEADS

PLANNING INFORMATION

LEGAL DESCRIPTION: LOT 1 OF MINOR PARTITION PLAT FILED DECEMBER 31, 1990 AS FILE NO. MP 900022, LOCATED IN A PORTION OF SECTIONS 4, 9 AND 10 IN TOWNSHIP 1 NORTH, RANGE 13 EAST OF THE WILLAMETTE MERIDIAN, WASCO COUNTY, STATE OF OREGON.

ZONING:

APPLICABLE CODES

2022 OREGON STRUCTURAL SPECIALTY CODE
2022 OREGON MECHANICAL SPECIALTY CODE
2021 OREGON ELECTRICAL SPECIALTY CODE
2021 OREGON PLUMBING SPECIALTY CODE
2021 OREGON ENERGY EFFICIENCY SPECIALTY CODE
2022 OREGON FIRE CODE

DEFERRED SUBMITTALS

- FIRE PROTECTION
- FIRE ALARM SYSTEM
- PLUMBING & MECHANICAL PERMIT APPLICATIONS TO BE MADE BY PLUMBING & MECHANICAL CONTRACTORS

CODE SUMMARY

CONSTRUCTION TYPE 1
OCCUPANCY: B

PROJECT TEAM

OWNER

Columbia Gorge Community College
400 E. Scenic Drive
The Dalles, OR 97058
Contact: Danny Dehaze
dkehaze@cgcc.edu

ARCHITECT

Soderstrom Architects, Ltd
11331 NW Lovejoy St, Suite 775
Portland, Oregon 97209
Contact: Mike Shea
(503) 964-4329
michaels@sdra.com

MECHANICAL ENGINEER

Arris Consulting
2622 SE 25th Ave, Suite A
Portland, OR 97202
(503) 309-6335
Contact: Brian Butler
brian@arris-consulting.com

ELECTRICAL ENGINEER

Landis Consulting
5335 Meadows Rd, #388
Lake Oswego, OR 97035
Contact: Michael Henning
(503) 413-0658
michael_henning@landisconsulting.com

Soderstrom
Architects

1331 NW Lovejoy St., Suite 775
Portland, OR 97209

T 503-228-5617
F 503-227-8584

sdra.com

Nursing Simulation Lab
Building 1 - Columbia Gorge Community College
400 East Scenic Drive
The Dalles, OR 97058



Project

Consultant

Revisions

No. Description Date

Stamp



Issuance

100% CD

Date

7.28.23

Project Number

22093
EDA Award Number 07-79-07767
URI 116720

Drawing Title

GENERAL
INFORMATION

Sheet No

G000



Consultant

Revisions		
No.	Description	Date



Issuance
100% CD


Date
7.28.23

Project Number
22093
EDA Award Number 07-79-07767
URI 116720

Drawing Title
**OVERALL FLOOR
PLAN & CODE
ANALYSIS**

Sheet No
A201

LEGEND

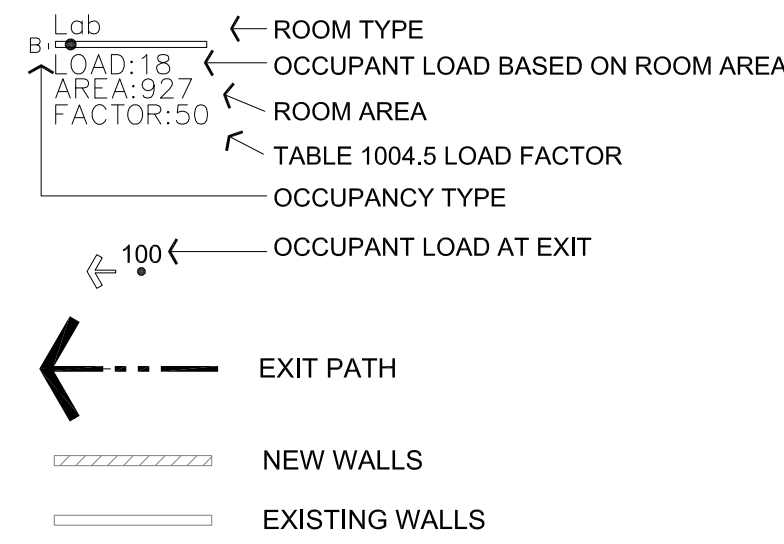


CODE ANALYSIS

2022 OREGON STRUCTURAL SPECIALTY CODE
2022 OREGON MECHANICAL SPECIALTY CODE
2021 OREGON ELECTRICAL SPECIALTY CODE
2021 OREGON PLUMBING SPECIALTY CODE
2021 OREGON ENERGY EFFICIENCY SPECIALTY CODE
2022 OREGON FIRE CODE


- FOURTH FLOOR BUILDING AREA: 138,762 SF
- AREA OF WORK FOR THIS TENANT IMPROVEMENT PROJECT IS 1785 SF
- CONSTRUCTION TYPE: I (ASSUMED DUE TO CONCRETE CONSTRUCTION)
- FULL SPRINKLER SYSTEM PROVIDED
- B OCCUPANCY

GENERAL NOTES:

- PROJECT CONSISTS OF A 1785 SF INTERIOR REMODEL ON THE 4TH FLOOR CONVERTING CLASSROOM SPACE INTO NURSING SIMULATION LABS.
- WORK INCLUDES FINISHES, NEW PARTITIONS, DOORS, CEILINGS, LIGHTING & POWER, WITH ALTERED LOCATIONS OF HVAC GRILLES AND SPRINKLER HEADS

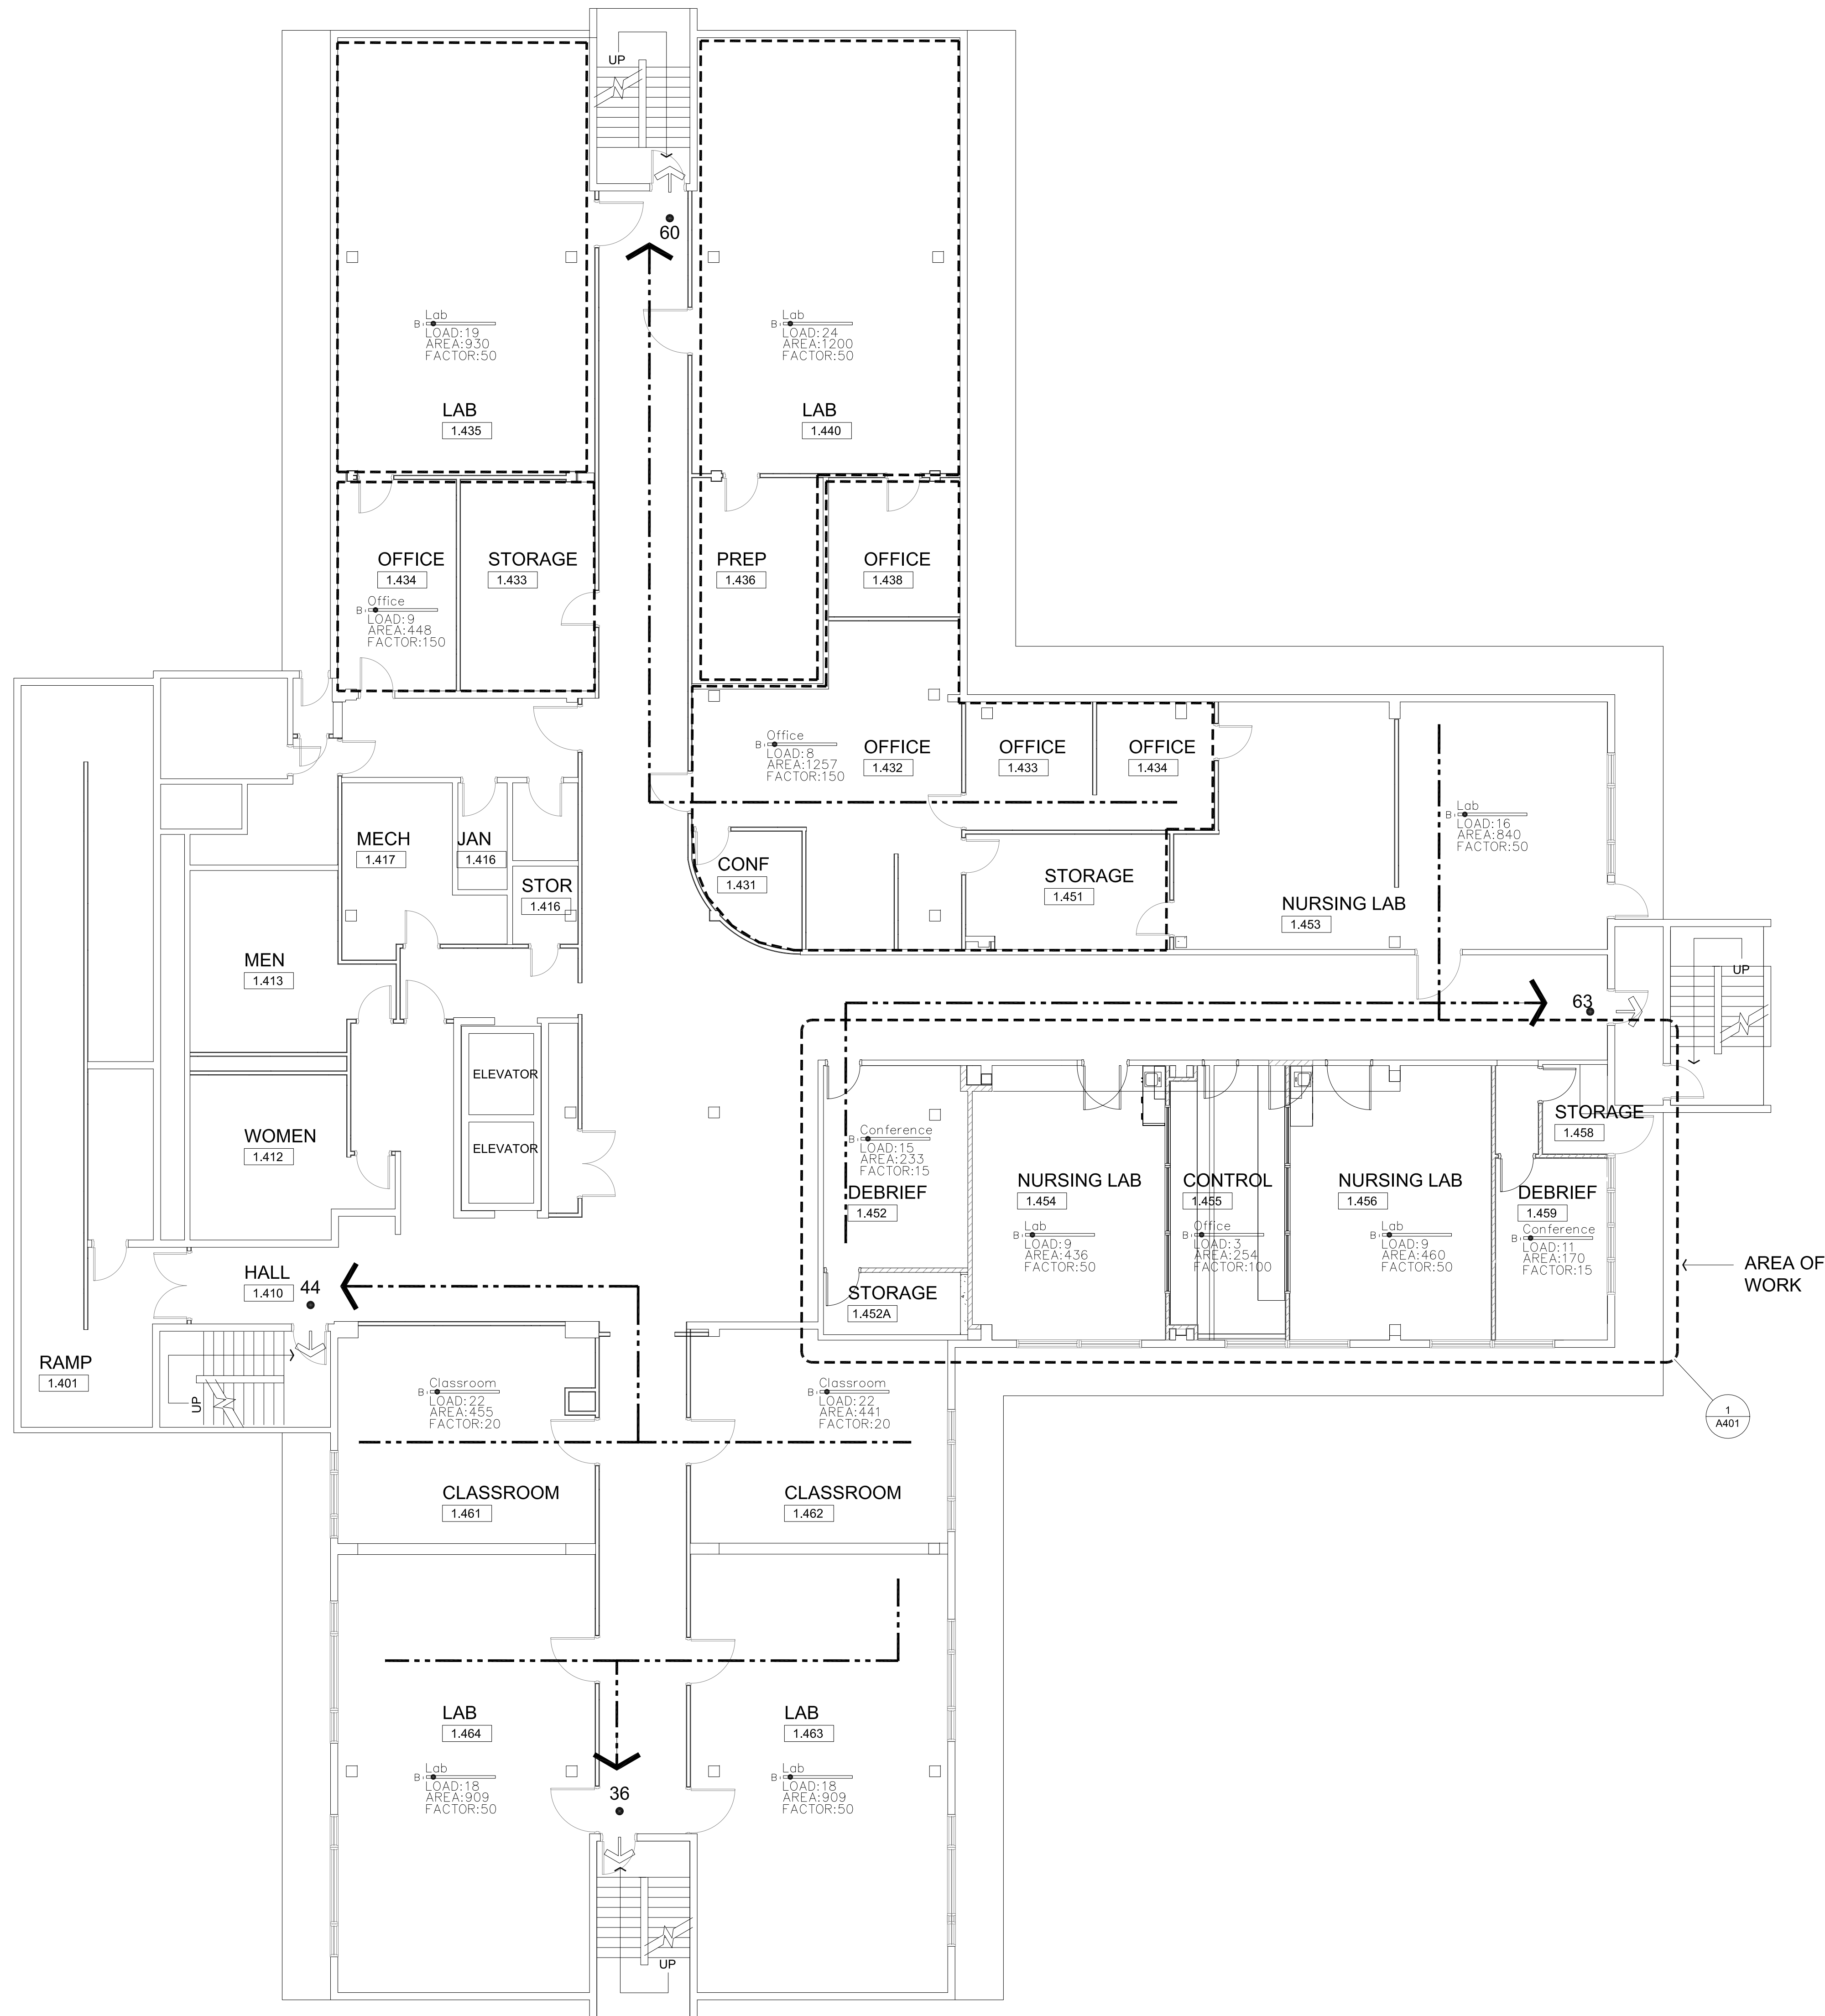

1 OVERALL FOURTH FLOOR PLAN
1/8" = 1'-0"

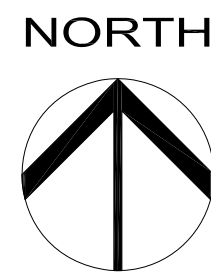



Project

Consultant

Revisions

No. Description

Date

Stamp



Issuance

100% CD

Date

07.28.23

Project Number

22093

EDA Award Number 07-79-07767

URI 116720

Drawing Title

FLOOR PLAN /
DEMOLITION PLAN

Sheet No

A401

FLOOR PLAN NOTES

1. ALL WALLS EXTEND TO CONCRETE STRUCTURE ABOVE.
2. ALL WALLS ARE TYPE 1, U.O.N. SEE A901.
3. VERIFY DIMENSION IN THE FIELD PRIOR TO CONSTRUCTION.
4. PRIOR TO EQUIPMENT / MATERIAL INSTALLATION PREP WALLS PER MANF. RECOMMENDATIONS.
5. PROVIDE BACKING @ ALL EQUIPMENT AND FIXTURES TO BE WALL MOUNTED.
6. REMOVE / RELOCATE, THERMOSTATS, SWITCHES, HVAC GRILLS ETC PER NEW CONSTRUCTION.

LEGEND

- SIM**
1=SECTION NO.
A101= SHEET NO.
- #1.XXX**
DOOR TAG
- FRAMED WALL**
- EXISTING WALL TO REMAIN**
- WALL TO BE DEMOLISHED**
- AREA OF NO WORK
(NOT IN CONTRACT)**
- EQUIPMENT**
- RS**
ROLLER SHADE
- #**
WALL TYPE
- WINDOW TYPE**

LEGEND - KEYNOTES

MARK	DESCRIPTION
1502	REMOVE EXISTING FLOOR/BASE MATERIALS. PREP FLOOR FOR NEW FINISHES
1503	DEMOLISH DOOR, FILL WALL, REFINISH EXISTING SURFACE
1505	DEMOLISH WALL, PREP FOR NEW DOOR
1506	REMOVE BASE
1508	PREP WALL FOR NEW PAINT
2003	FUR WALL, BELOW WINDOW, CHANNEL ELEC. WIRES FOR CONTROL TOWER.
2005	TACKBOARD / MARKERBOARD, SEE ELEVATION
2006	EXISTING COLUMNS, P-3
2010	OBSERVATION WINDOW, ONE WAY GLASS MIRROR
2011	4L TO 3' L. SHELVES, OFOI
2012	MONITOR, SEE ELECTRICAL FOR MORE INFO.
2013	32 1/2" W.X. 6'3" H. VERTICAL HEADWALL, SEE ELECTRICAL FOR ADDITIONAL INFO.
2014	MANUEL ROLLER SHADE, SEE FINISH SUMMARY
2025	EXISTING COLUMN TO MATCH GYP SURFACE. FEATHER ALL TRANSITIONS FOR SEAMLESS EDGE.

1 FLOOR PLAN

A401 (1/4" = 1'-0")

2 DEMOLITION FLOOR PLAN

A401 (1/4" = 1'-0")



Project

Consultant

Revisions

No. Description

Date

Stamp



Issuance

100% CD

Date

07.28.23

Project Number

22093

EDA Award Number 07-79-07767

URI 116720

Drawing Title

RCP / DEMO
REFLECTED CEILING
PLAN

Sheet No

A601

SHEET NOTES


1. REFER TO ENGINEER'S DRAWINGS FOR LIGHT SWITCHING AND SPECIFICATION, EXIT SIGN LOCATIONS, AND ELECTRICAL AND MECHANICAL SYSTEMS.
2. REPORT TO ARCHITECT ANY CONFLICTS BETWEEN ELECTRICAL, MECHANICAL, OR STRUCTURAL DRAWINGS AND THIS LAYOUT.
3. ALL VISIBLE STRUCTURE, DUCTWORK, PIPES, CONDUITS, AND OTHER ASSOCIATED COMPONENTS NOT FULLY CONCEALED BEHIND A CONTINUOUS CEILING TO BE PAINTED.
4. ALL LIGHTS AND GRIDS ARE TO BE CENTERED IN ROOM, UNO.
5. GENERAL CEILING HEIGHT 9'-0" U.N.O

LEGEND

	ACOUSTIC CEILING TILE (ACT)
	OPEN TO STRUCTURE
	SUPPLY AIR GRILL
	RETURN AIR GRILL
	FRAMED WALL
	EXISTING WALL TO REMAIN
	WALL TO BE DEMOLISHED
	AREA OF NO WORK (NOT IN CONTRACT)
	SPRINKLER
	LINEAR PENDANT
	PENDANT
	DOWNLIGHT
	2X2 TROFFER
	CEILING HEIGHT TAG


LEGEND - KEYNOTES

MARK	DESCRIPTION
1505	DEMOLISH WALL, PREP FOR NEW DOOR
6006	PARTITION CURTAIN WITH TRACK
6007	REMOVE EXISTING BULKHEAD & SOFFIT
6008	REMOVE ALL LIGHTING, CONDUIT, WIRE AND DUCTWORK, BOTH ROOMS
6009	CUT OPENING PREP FOR NEW DOOR
6010	REMOVE EXISTING SPRINKLERS LINES & HEAD INSIDE ROOMS

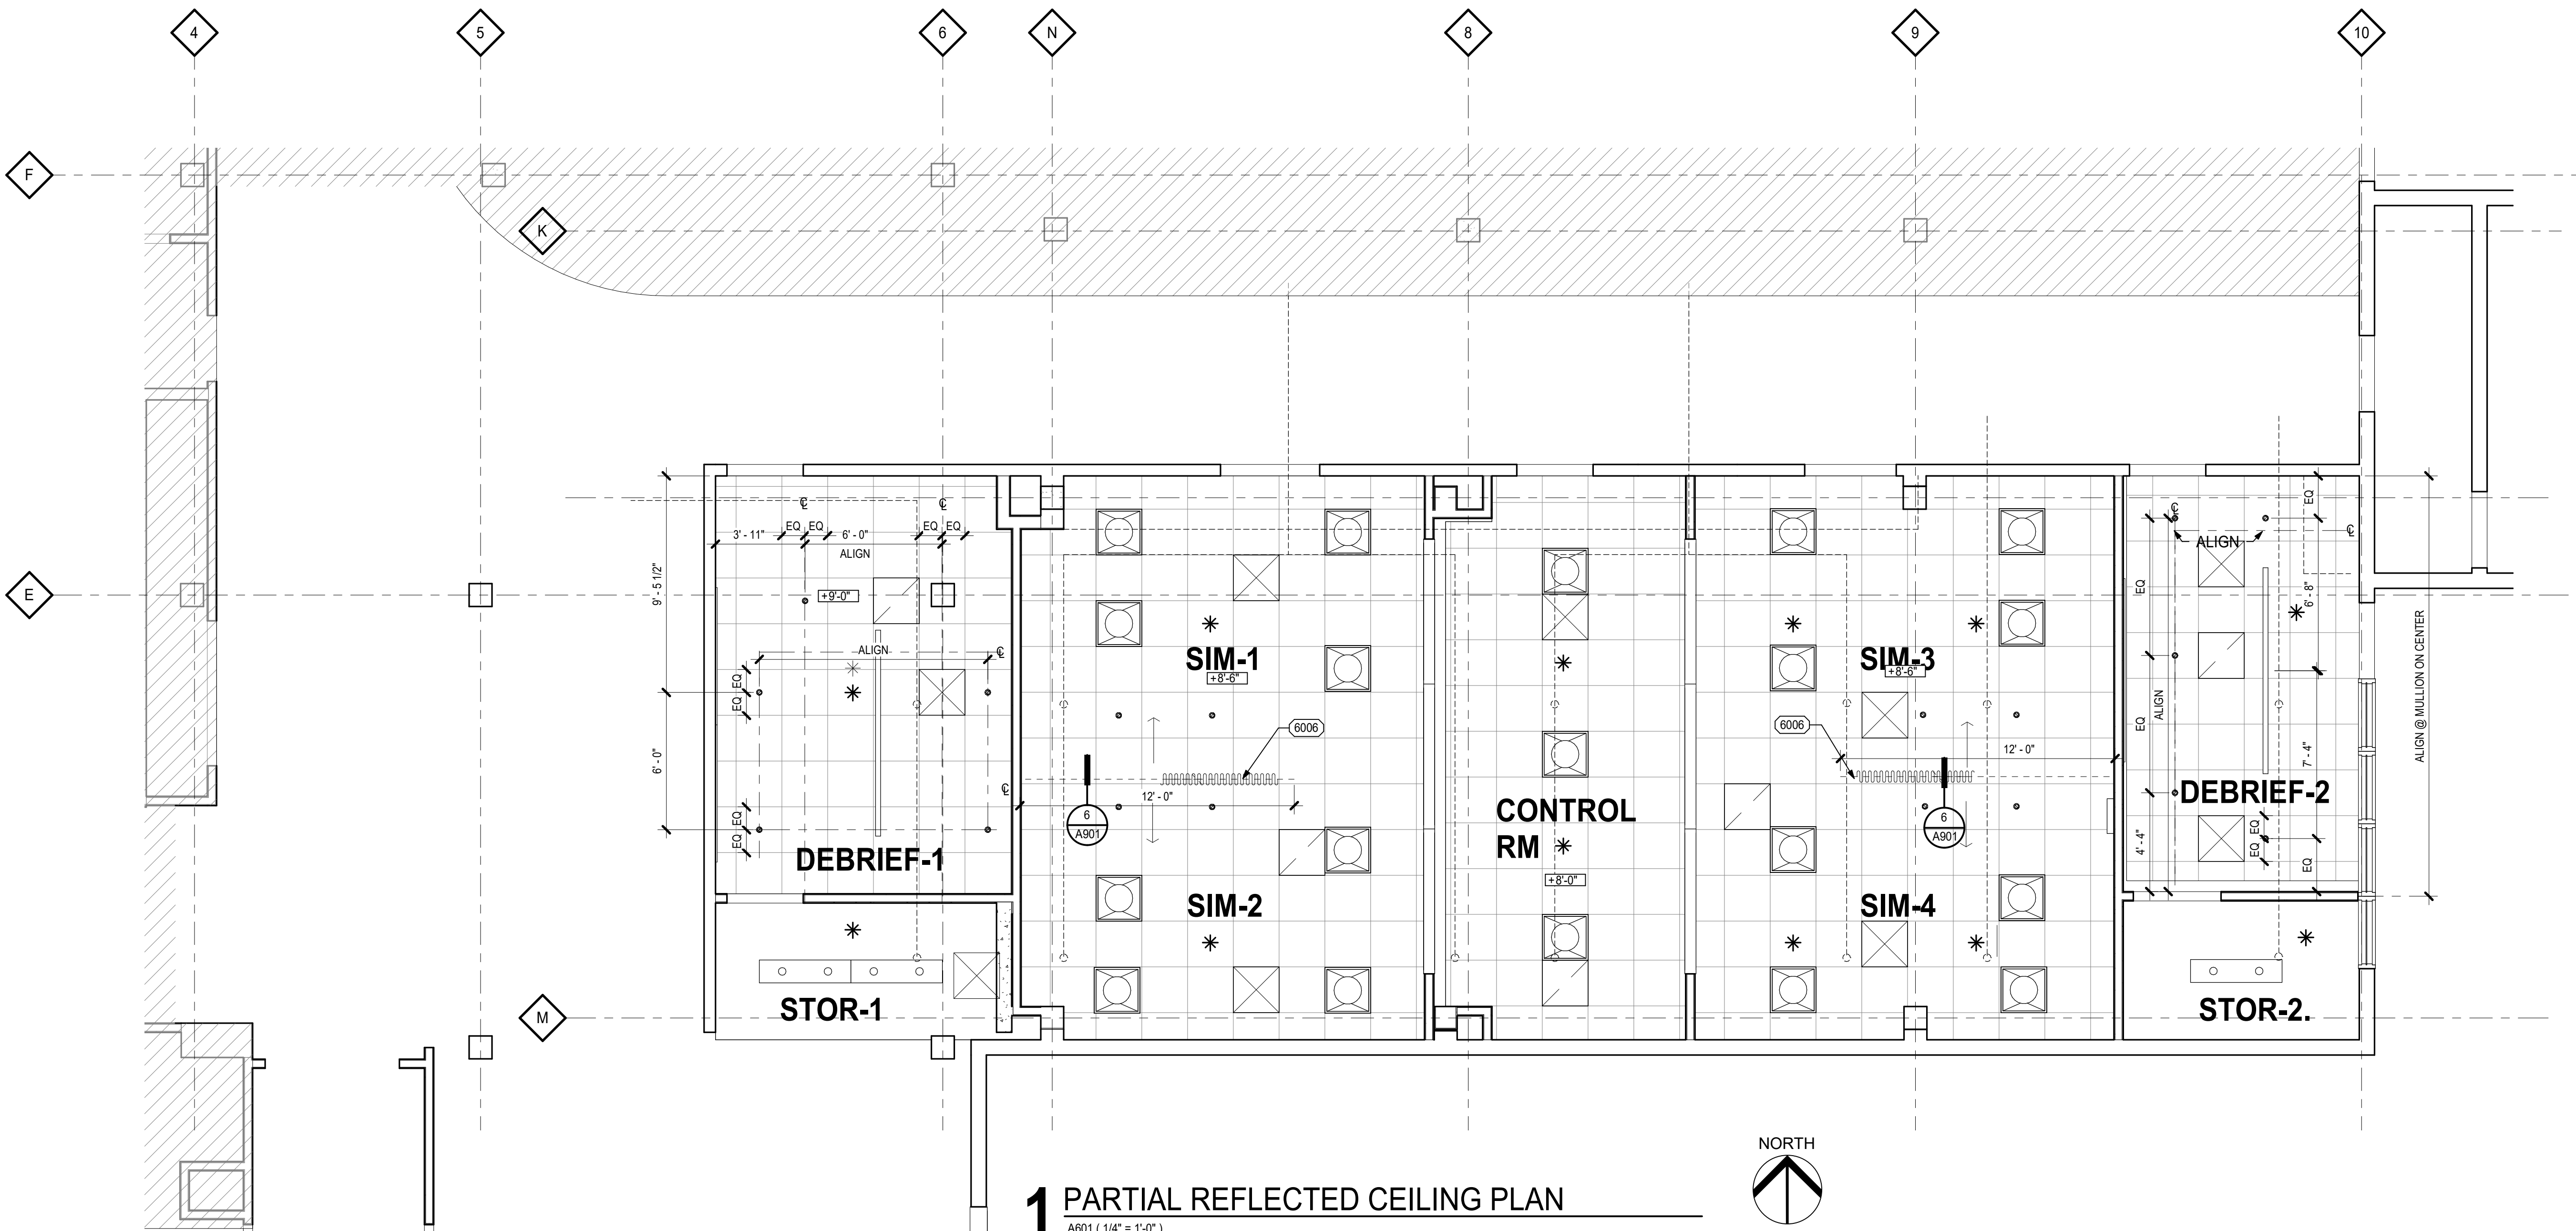

1 PARTIAL REFLECTED CEILING PLAN

A601 (1/4" = 1'-0")

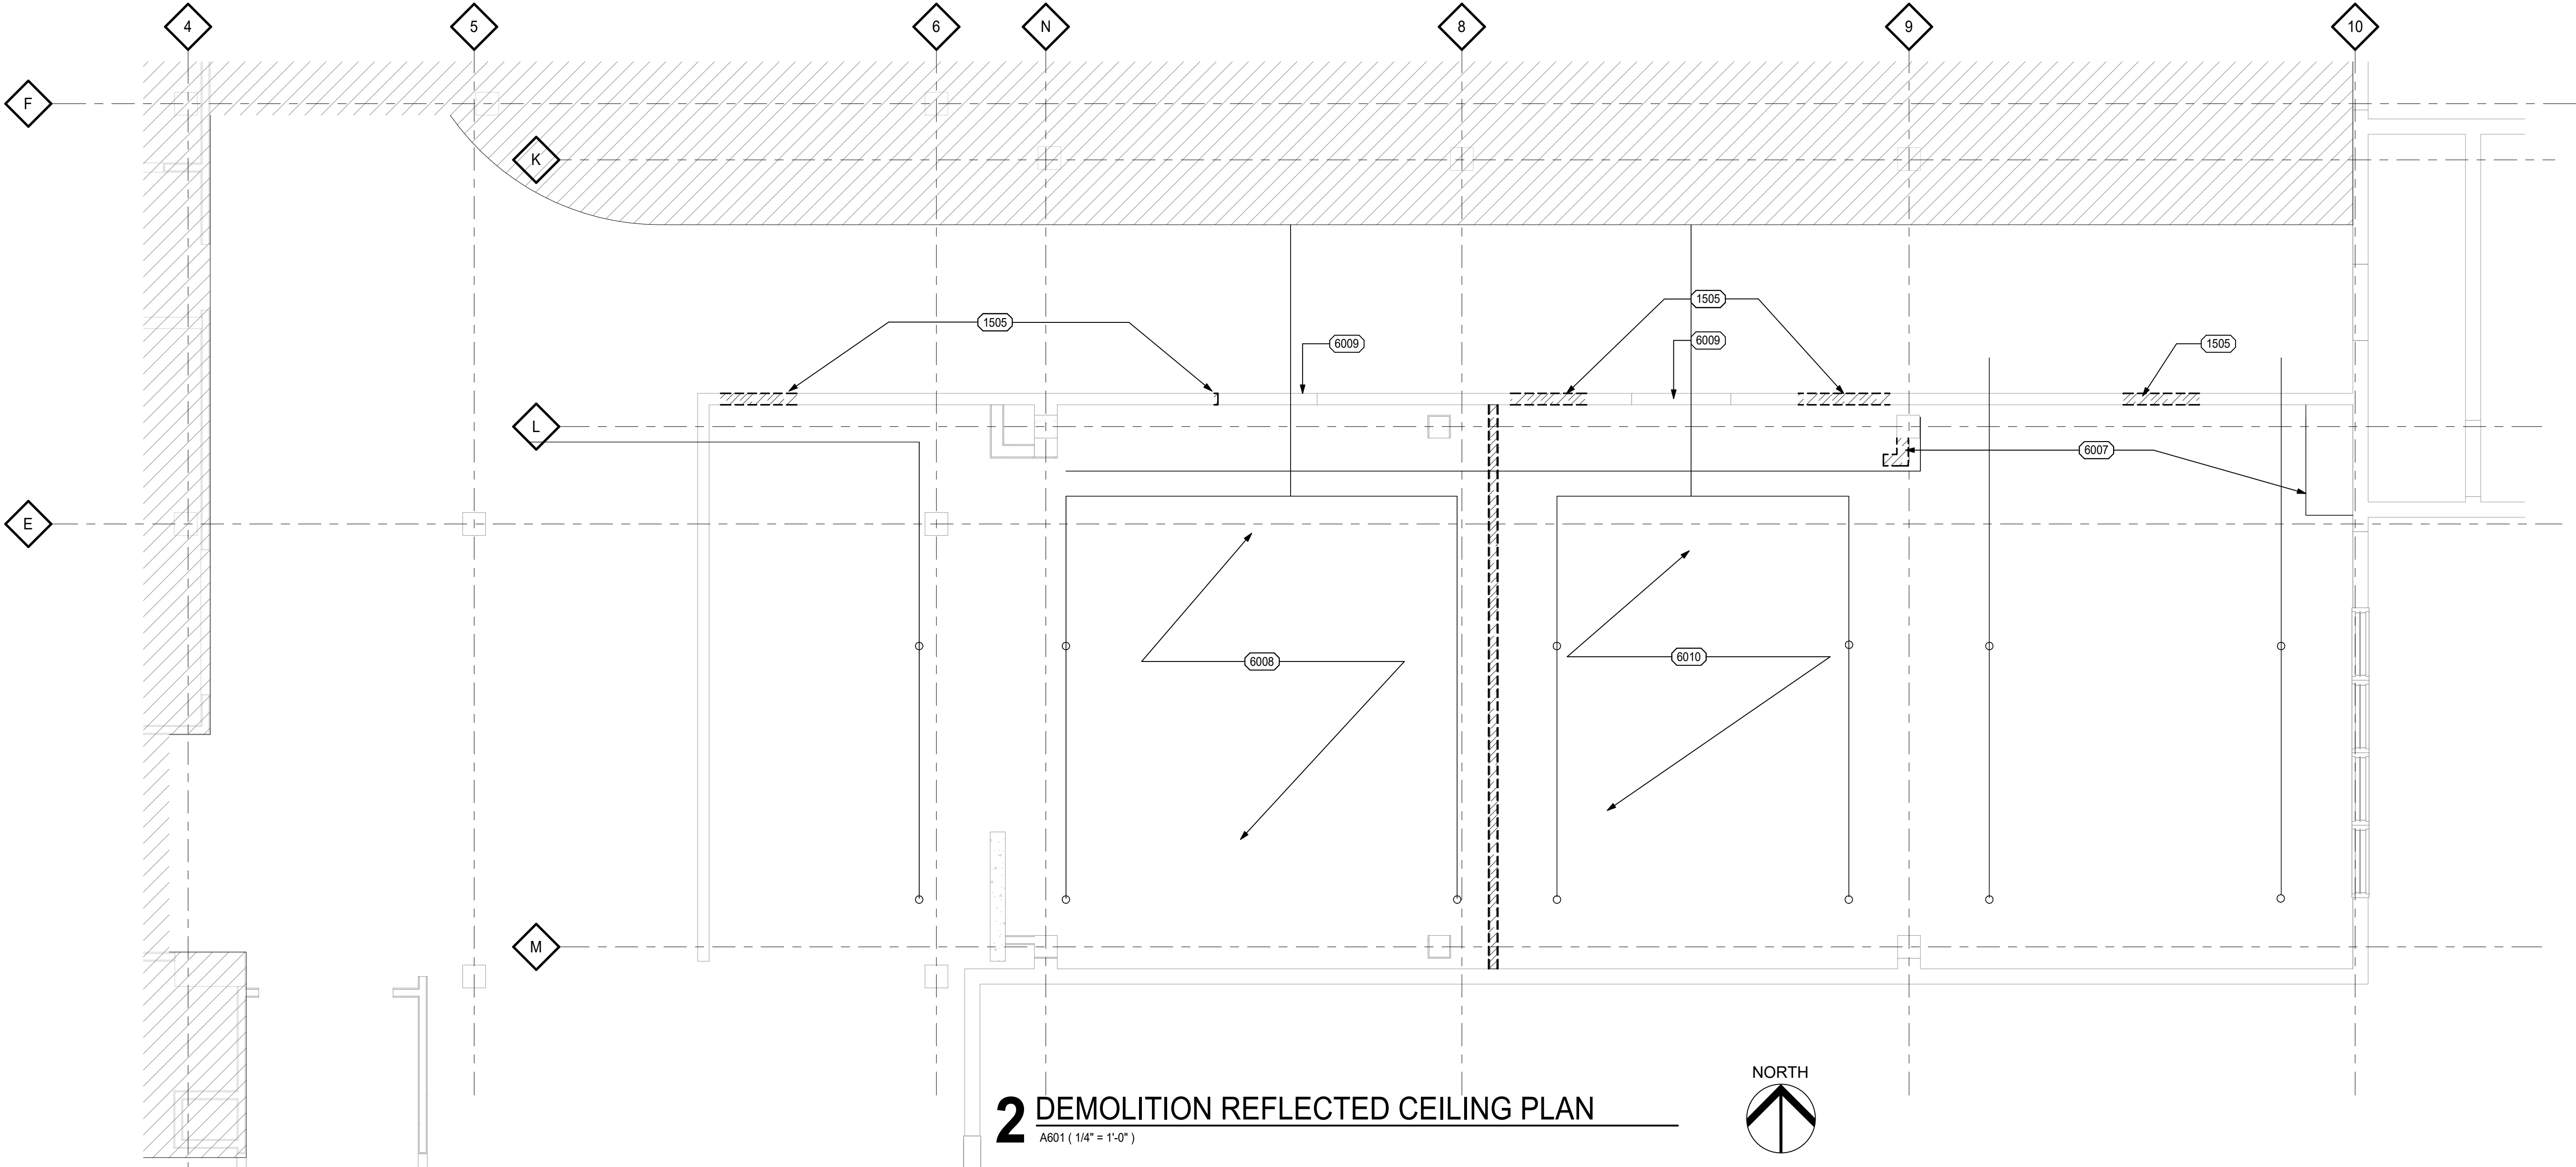

2 DEMOLITION REFLECTED CEILING PLAN

A601 (1/4" = 1'-0")

1. VERIFY IN FIELD ALL ROUGH OPENING DIMENSIONS
2. NO FLOOR TRANSITIONS WHERE FLOORING IS LEVEL, BETWEEN DISSIMILAR FLOORING
3. MATERIALS PROVIDE TRANSITION STRIP.
4. WHERE NOT INDICATED, TRANSITION IS TO OCCUR CENTERED UNDER DOOR.
5. SEE FLOOR PLAN / ELEVATIONS FOR MONITOR, TACKBOARD, AND MARKERBOARD
6. LOCATIONS.
7. PAINT ALL EXPOSED SPRINKLES, HVAC WHITE TO MATCH CEILING.
8. ALL OUTLETS, SWITCH COVERS, GRILLS FINISH COLORS WHITE.

ACT	ACQUSTIC CEILING TILE
ACP	ACQUSTIC PANEL
CP	CARPET TILE
CPT	COUNTER TOP
FR	FIBERGLASS-REINFORCED PLASTIC
G	GRAPHIC
GYP	GYPSSUM WALL BOARD
LVT	LUXURY VINYL TILE
MM	MELAMINE
P	P. PAINT
PC	POLISHED CONCRETE
PH	PHENOLIC PANEL
PLM	PLASTIC LAMINATE
PRF	POURED RESINOUS FLOORING
FLU	FLUID APPLIED FLOORING
RF	RESILIENT BASE
RF	RESILIENT FLOORING
SC	SEALED CONCRETE
SURF	SOLID SURFACE
ST	STAIR TREAD
SV	SHEET VINYL
TB	TACKBOARD
WD	WOOD GRILL
WDM	WOOD GRIND FLOORING
WO	WOOD-OFF MAT

1. PATTERN - VERTICAL INSTALL
2. OPT-1: WALLCOVERING AS PROTECTION @ FULL WALL. OPT-2: COMPARE PRICING FOR 4'H FRP W/ WALLCOVERING ABOVE.
3. 36"H FRP WALL PROTECTION
4. WINDOW COVERING @ ALL EXTERIOR WINDOWS. SEE A401 FOR LOCATION
5. REMOVE EXISTING BASE, PREP / REFINISH EXISTING WALL FOR NEW FINISH.

	ORIENTATION OF FLOOR PLANK OR TILE IN ROOM
	CORNER GUARD
	FLOOR TRANSITION
	FLOOR FINISH TAG
	PAINT LINE
	NOT IN SCOPE
	CPT-1
	CPT-2
	EXISTING
	RF-1
	RF-2
	RF-3

[illegible]

DOOR AND FRAME SCHEDULE													
TO ROOM NUMBER	MARK	DOORS				FRAMES				HARDWARE SET	Dr-Ja mb	NOTES	
		OPENING SIZE		TYPE	MAT	P-X	FIN	TYPE	MAT				FIN
		WIDTH	HGT.										
1.452	1.452a	3'-0"	7'-0"	G	WD	P-X	HM	HM	P-X	A	FULL GLAZE		
1.452a	1.452a	3'-0"	7'-0"	N	WD	P-X	HM	HM	P-X	D	6" W LITE		
1.454a	1.454	4'-0"	7'-0"	G	WD	P-X	HM	HM	P-X	B	8" W LITE		
1.455	1.455	3'-0"	7'-0"	F	WD	P-X	HM	HM	P-X	A	SOLID		
1.456a	1.456	3'-8"	7'-0"	NL	WD	P-X	HM	HM	P-X	C	6" W LITE/ W SIDE LEAF		
1.457	1.457	3'-0"	7'-0"	G	WD	P-X	HM	HM	P-X	A	FULL GLAZE		
1.457	1.457a	3'-6"	7'-0"	N	WD	P-X	HM	HM	P-X	D	6" W LITE		

ROOM FINISH SCHEDULE												
ROOM #	ROOM NAME	FLOOR	BASE	WALLS				CEILING	CASEWORK FINISH CODE* (SEE NOTES)	MISC		
				NORTH	EAST	SOUTH	WEST					
1.452	DEBRIEF-1	CPT-1	RB-1	P-3	P-3	P-4	P-4	ACT-1				
1.452a	STOR-1	RF-2	RB-1	P-1, FRP-1	P-1, FRP-1	P-1, FRP-1	P-1	OTS		3		
1.454a	SIM-1	RF-1	RB-2	P-2	P-2	P-2	WC-2 P-2	ACT-1	PL-2, PL-3, CT-1	1.2		
1.454b	SIM-2	RF-1	RB-2	P-2	P-2	P-2	WC-2 P-2	ACT-1		1.2, 4		
1.455	CONTROL RM	RF-2	RB-1	P-1	P-1	P-1	P-1	ACT-1	CT-1, PL-2	4		
1.455a	SIM-3	RF-1	RB-2	P-2	P-2	P-2	WC-1	ACT-1	PL-1, PL-2, CT-1	1.2		
1.456b	SIM-4	RF-1	RB-2	P-2	P-2	P-2	WC-1	ACT-1		1.2, 4		
1.457	DEBRIEF-2	CPT-2	RB-1	P-5	P-5	P-6	P-6	ACT-1	PL-3, PL-4	3		
1.457a	STOR-2	RF-2	RB-1	P-1, FRP-1	P-1, FRP-1	P-1, FRP-1	P-1, FRP-1	OTS		4		
A178	EXISTING	NOT IN SCOPE	RB-2	P-8	P-8	P-8	P-8	NOT IN SCOPE		5		

A801 (1/4" = 1'-0")

FURNISH CARPENTRY WINDOW SILLS	SECTION 06 2000
WD-1	MANUFACTURER: REFER TO SPEC FOR ACCEPTABLE SPECIES NOTE: SEE PLASTIC LAMINATE / COUNTERTOPS FOR FINISHES
PLASTIC LAMINATE	SECTION 06 4100
PL-1	MANUFACTURER: FORMICA PRODUCT: GENERAL PURPOSE GRADE LAMINATE (HGS) PATTERN: FOSSIL FINISH: MATTE NOTE: WHITE MELAMINE INTERIOR AT ALL EXPOSED SURFACES LOCATION: LOWER VERTICAL CASEWORK
PL- 2	MANUFACTURER: FORMICA PRODUCT: GENERAL PURPOSE GRADE LAMINATE (HGS) PATTERN: FOSSIL FINISH: PLEX FINISH NOTE: WHITE MELAMINE INTERIOR AT ALL EXPOSED SURFACES LOCATION: UPPER VERTICAL CASEWORK
PL- 3	MANUFACTURER: FORMICA PRODUCT: GENERAL PURPOSE GRADE LAMINATE (HGS) PATTERN: PORTICO MARBLE FINISH: MATTE NOTE: COUNTERTOP LOCATION: SEE ELEVATIONS
PL- 4	MANUFACTURER: FORMICA PRODUCT: GENERAL PURPOSE GRADE LAMINATE (HGS) PATTERN: FOG FINISH: MATTE LOCATION: SEE ELEVATIONS
WALL PROTECTION	SECTION 10 2600
WC-1	MANUFACTURER: CARNEGIE PRODUCT: XOREL WALL PROTECTION PATTERN: DOVER 8123 -11 BACKING: X-PROTECT WALL BACKING SIZE: 54" W SEE ELEVATIONS LOCATION: SIM LABS
WC-2	MANUFACTURER: CARNEGIE PRODUCT: XOREL WALL PROTECTION PATTERN: DOVER 8123 -12 BACKING: X-PROTECT WALL BACKING SIZE: 54" W SEE ELEVATIONS LOCATION: SIM LABS
COUNTERTOPS	SECTION 12 3600
CT-1	MANUFACTURER: WILSONART PRODUCT: THINSCAPE - COMPOSITE COUNTERTOP GAUGE: 1/2 THICK EDGE: KNIFE EDGE COLOR: SPANISH LIMESTONE CORE COLOR: GRAY FINISH: SB (GANDBLAST) SIZE: 5X12 SLAB NOTE: CUT SLAB INTO TWO COUNTERTOPS AND BACKSLASH FOR SIM LABS LOCATION: SIM LABS

CARPET	SECTION 09 6813
CPT-1	MANUFACTURER: PATCRAFT PRODUCT: CARPET TILE COLLECTION: COLOUR & TEXTURE FUSION STYLE: 10625 IMMERSIVE COLOR: 00100 MIST SIZE: 24X24 PATTERN: ASHLAR PATTERN LOCATION: DEBRIEF RM NOTE: TRANSITION STRIP - PROFILITEC; SELF ADHESIVE MS
CPT-2	MANUFACTURER: PATCRAFT PRODUCT: CARPET TILE COLLECTION: COLOUR & TEXTURE FUSION STYLE: 10625 IMMERSIVE COLOR: 00120 GLAZE SIZE: 24X24 PATTERN: ASHLAR PATTERN LOCATION: DEBRIEF RM NOTE: TRANSITION STRIP - PROFILITEC; SELF ADHESIVE MS
RESILIENT FLOORING	SECTION 09 6500
RF-1	MANUFACTURER: INTERFACE PRODUCT: NORA STYLE: NORAMENT 926 PADO COLOR: 3501 NATURAL SIZE: 40X60 TILE THICKNESS: 3.5MM NOTE: COLD WELD 3501 PATTERN: QUARTER TURN LOCATION: SLM LAB
RF-2	MANUFACTURER: INTERFACE PRODUCT: NORA STYLE: NORAPLAN CONVIA COLOR: 7300 STONE KHAKI SIZE: SHEET THICKNESS: 2.0 MM NOTE: COLD WELDING 7053 / HEAT WELD ROD COLOR 7053 LOCATION: STORAGE ROOMS, CONTROL ROOMS
RUBBER BASE AND TREADS	SECTION 09 6500
RB-1	MANUFACTURER: NORA PRODUCT: WALL BASE (THERMOPLASTIC RUBBER) PROFILE: COVE COLOR: DOVE GRAY 6233 SIZE: 4"
RB-2	MANUFACTURER: NORA PRODUCT: WALL BASE (THERMOPLASTIC RUBBER) PROFILE: COVE COLOR: SILVER SIZE: 4"
ACOUSTIC CEILING TILE	SECTION 09 5100
ACT-1	MANUFACTURER: ARMSTRONG PRODUCT: ULTIMA SQUARE LAY IN #1943 NRC: 0.75 & CAC 35 FINISH: FINE TEXTURE SIZE: 24X24 SUSPENSION SYSTEM: PRELUDE XL 5/16" WHITE LOCATION: SEE RCP
FIBER REINFORCED PLASTIC	SECTION 09 8316

FORM 2 (ALTER FOR WCO)	MANUFACTURER: INPRO PRODUCT: FRP WALL PANEL STYLE: SMOOTH RATING: CLASS A THICKNESS: 0.075" COLOR: SEA SALT 0279 SIZE: 48"W X 50' (CUT TO FIT HEADBOARD WALL, SEE ELEVATION) PROVIDE MATCHING TOP VINYL TRIM, ADHESIVE TO MATCH AT VERTICAL SEAMS LOCATION: SIM LAB - 5'H AT WALLCOVERING
CORNER GUARDS	
CG- (TYP-1)	MANUFACTURER: INPRO MODEL: SURFACE MOUNT STAINLESS STEEL CORNER GUARD MOUNTING: CEMENT-ON GAUGE: 18 GA LEGS: 1 1/2" OVERALL HEIGHT: 5' UNO, INSTALL ABOVE BASE NOTE: BASE OF DESIGN
WINDOW SHADES	SECTION 12 2400
RS-1	MANUFACTURER: MECHOSYSTEMS PRODUCT: MECHO S- SINGLE SHADE ROLLER FABRIC: SONO 1600 SERIES OPENNESS: 3% COLOR: LIGHT GRAY
PAINT AND COATINGS	SECTION 09 9123
P-1	MANUFACTURER: BENJAMIN MOORE TYPE: LATEX COLOR: CASCADE MOUNTAINS FINISH: SATIN LOCATION: GENERAL PAINT COLOR
P-2	MANUFACTURER: BENJAMIN MOORE TYPE: LATEX COLOR: BLUE VEIL FINISH: SATIN LOCATION: SIM LABS
P-3	MANUFACTURER: BENJAMIN MOORE TYPE: LATEX COLOR: ICEBERG FINISH: SATIN LOCATION: DEBRIEF RM 1
P-4	MANUFACTURER: BENJAMIN MOORE TYPE: LATEX COLOR: BURTON BLUE FINISH: SATIN NOTE: ACCENT PAINT LOCATION: DEBRIEF RM 1
P-5	MANUFACTURER: BENJAMIN MOORE TYPE: LATEX COLOR: SMOKY GREEN FINISH: SATIN LOCATION: DEBRIEF RM 2
P-6	MANUFACTURER: BENJAMIN MOORE TYPE: LATEX COLOR: GRENADEIR POND FINISH: SATIN LOCATIONS: DEBRIEF RM 2
P-7	MANUFACTURER: BENJAMIN MOORE TYPE: LATEX COLOR: TO MATCH WALL PAINT COLOR

L A801 (3" = 1'-0")

5 A801 (3" = 1'-0")

T A801 (3" = 1'-0")

NOTE: FURNITURE FOR REFERENCE ONLY

TYPICAL HOLLOW METAL FRAME INFORMATION:

1. SEE WALL TYPE FOR STUD WIDTH
2. FRAME THROAT IS TO BE SIZED TO RECEIVE FULL PARTITION THICKNESS UNLESS DETAILED OTHERWISE.

Diagram illustrating the cross-section of a window jamb assembly, showing various components and dimensions:

- REFER TO PARTITION TYPE
- STL STUD FRAMING HEADER
- SEALANT EACH SIDE
- 1/2"
- 12"
- 80
- FACE OF ADJACENT WALL AT JAMB CONDITION (WHERE OCCURS)
- INSULATION AT ACOUSTIC WALLS
- APPLY H.M. STOP WITH COUNTER SUNK SCREWS (TYP)
- SEALANT TAPE EACH SIDE
- GLAZING - SEE ELEVATION FOR GLAZING TYPE
- 2"
- VARIES
- 2"
- IMCOMPRESSIBLE GASKET

A detailed cross-section diagram of a roof assembly. The diagram shows a sloped roof structure with the following components and dimensions:

- Dimensions:**
 - Two horizontal dimensions of $2'$ are shown at the top, with the word "VARIES" between them.
 - Three vertical dimensions on the right side are $1\frac{1}{2}"$, $2"$, and $1\frac{1}{2}"$ (with "or 2" below it).
- Labels and Components:**
 - LAZING SEE ELEVATIONS:** Points to the sloped roof surface.
 - SEALANT TAPE EACH SIDE:** Points to the tape on either side of the central joint.
 - APPLY H.M. STOP WITH COUNTER SUNK SCREWS (TYP):** Points to the metal flashing at the joint.
 - COMPRESSIBLE GASKET:** Points to the gasket at the base of the joint.
 - FOLLOW METAL FRAME:** Points to the metal structure below the roof deck.


DOOR AND FRAME

1.455	3'-0"	7'-0"	F	WD
1.456	3'-8"	7'-0"	NL	WD
1.457	3'-0"	7'-0"	G	WD
1.457a	3'-6"	7'-0"	N	WD

ROOM NAME	FLOOR	BASE	NORTH	
-1	CPT-1	RB-1	P-3	P-3
	RF-2	RB-1	P-1, FRP-1	P-1,
	RF-1	RB-2	P-2	P-2


	RF-1	RB-2	P-2	P-2
-2	CPT-2	RB-1	P-5	P-5
	RF-2	RB-1	P-1 _i	P-1 _i
6	NOT IN SCOPE	RB-2	---	P-8

FILE PATH:C:\Users\elizabethg\Documents\23.07.30 CGCC-SDRA ver 2022.Central.rte_detached_elizabethg\PSBNH.M
copyright © 2018

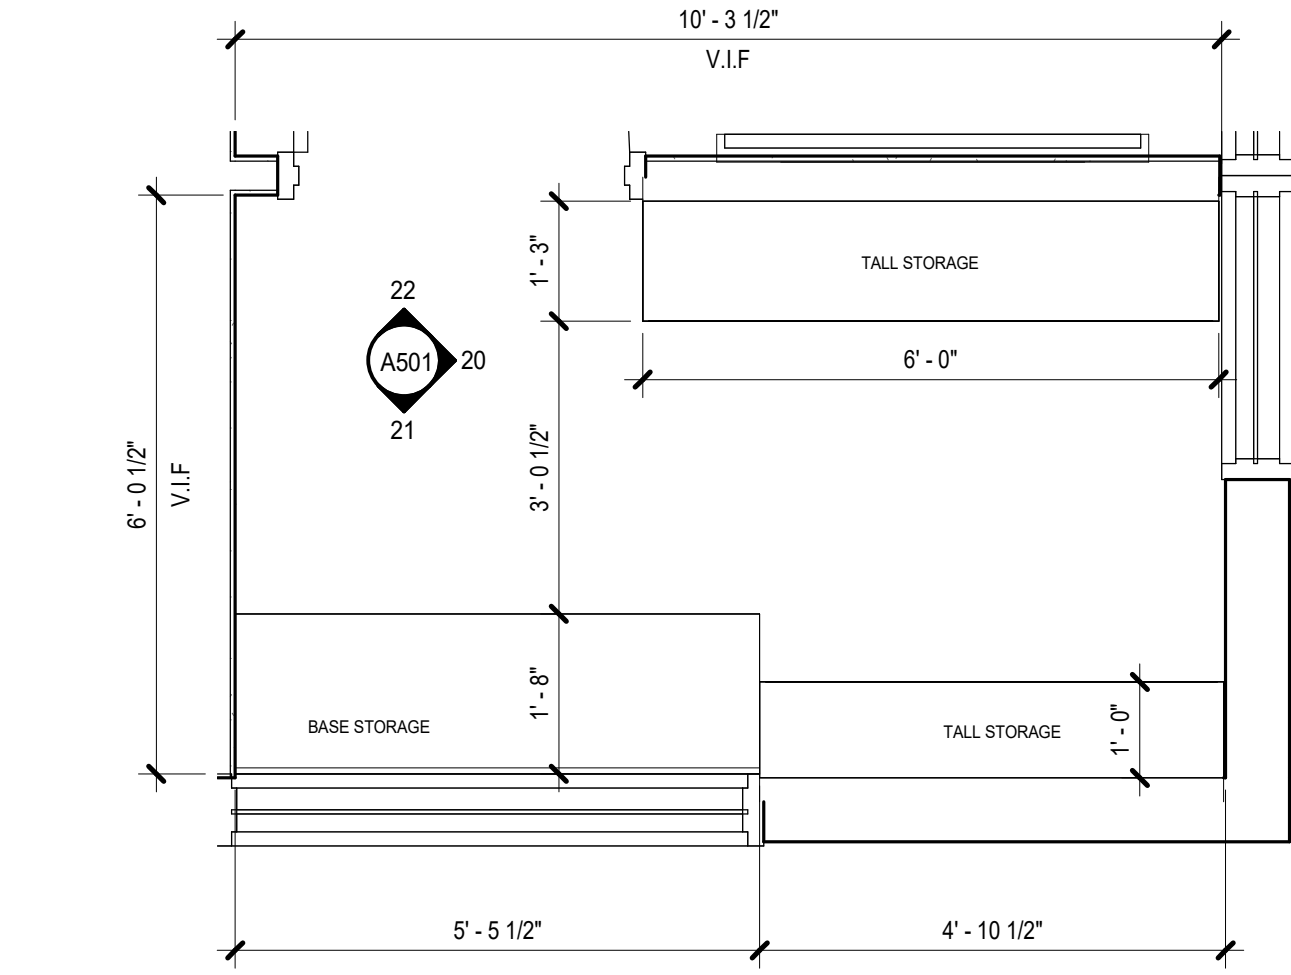


1 STORAGE RM - MED CASEWORK

A802 (1 1/2" = 1'-0")

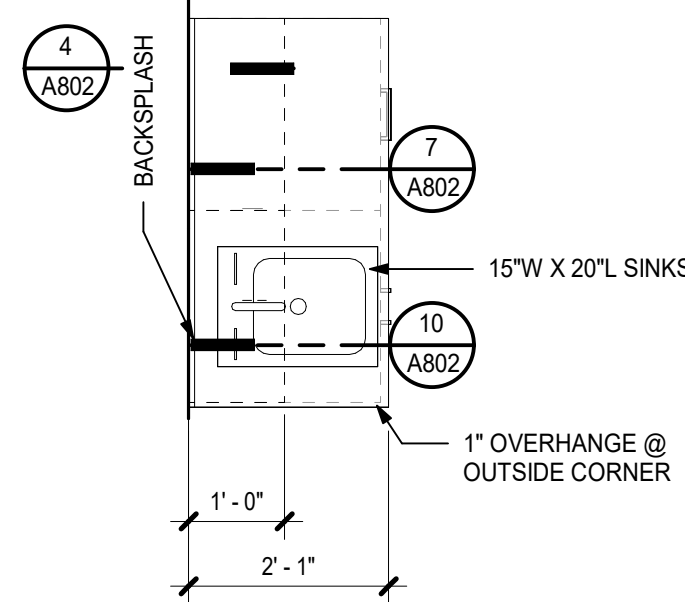


3 TYPICAL CASEWORK PLAN

A802 (1 1/2" = 1'-0")

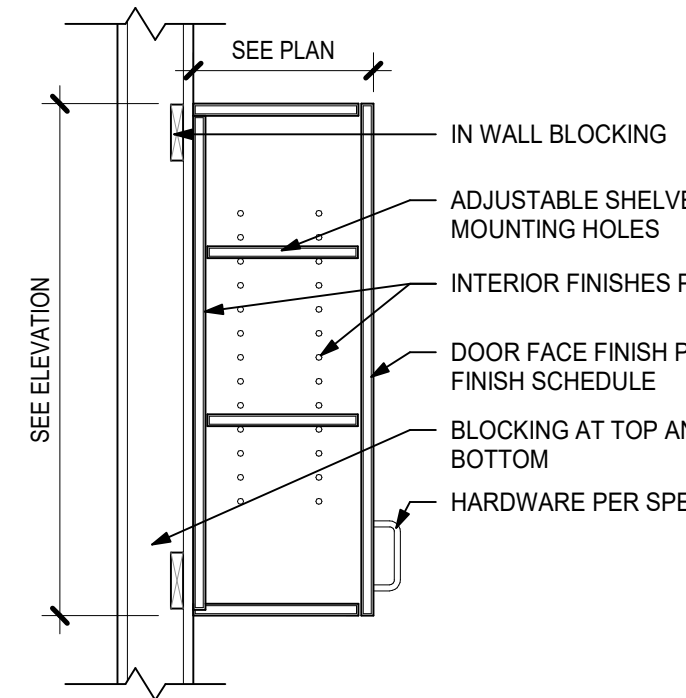


4 WALL CABINET

A802 (1" = 1'-0")

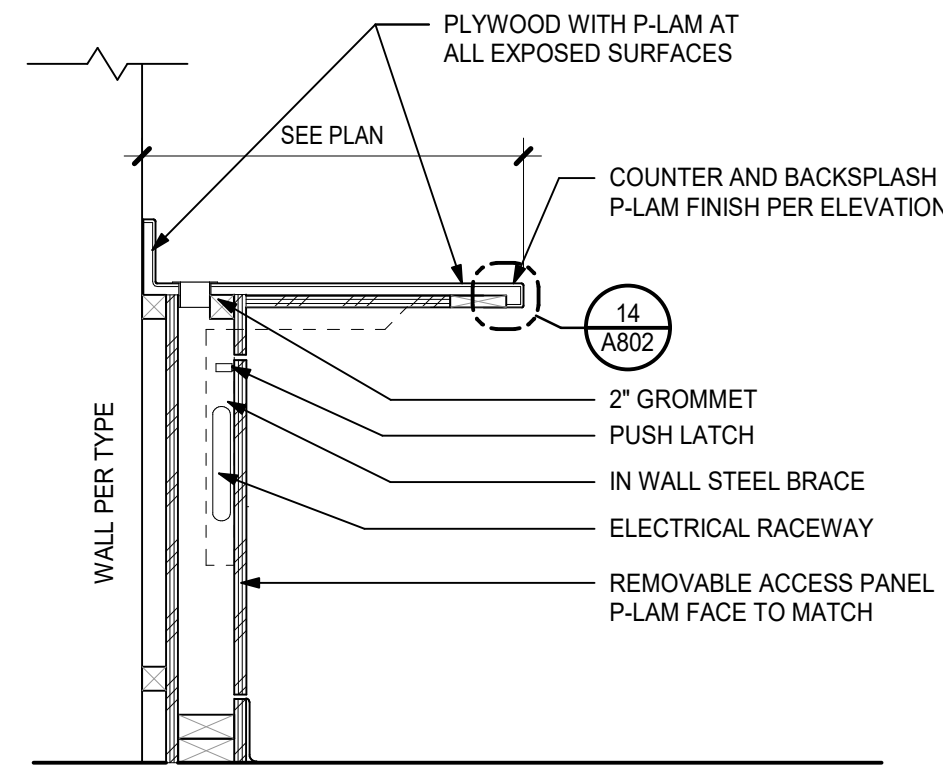


5 OPEN COUNTER

A802 (1" = 1'-0")

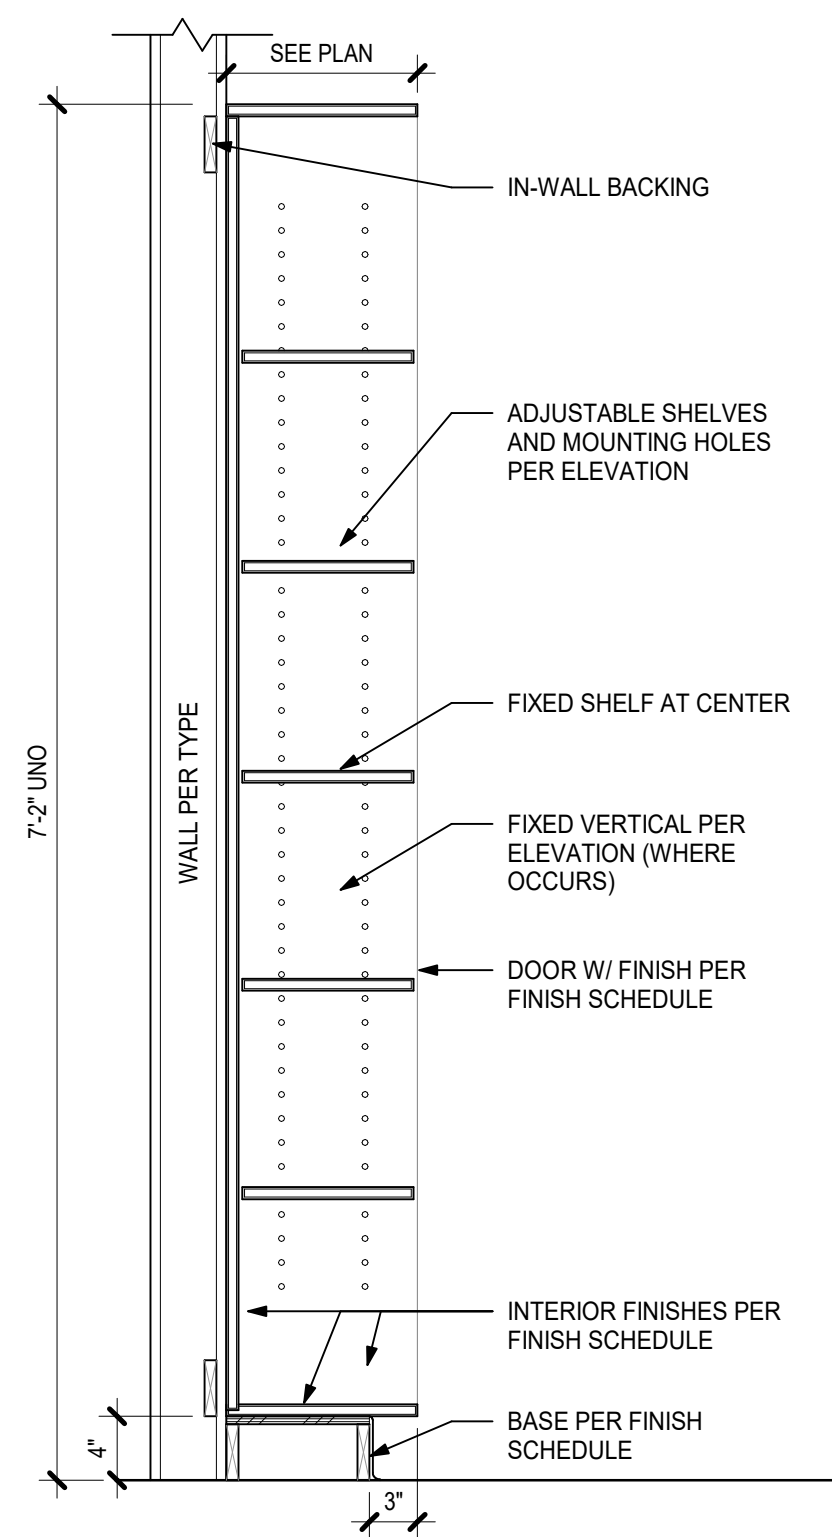


8 TALL CABINET

A802 (1" = 1'-0")

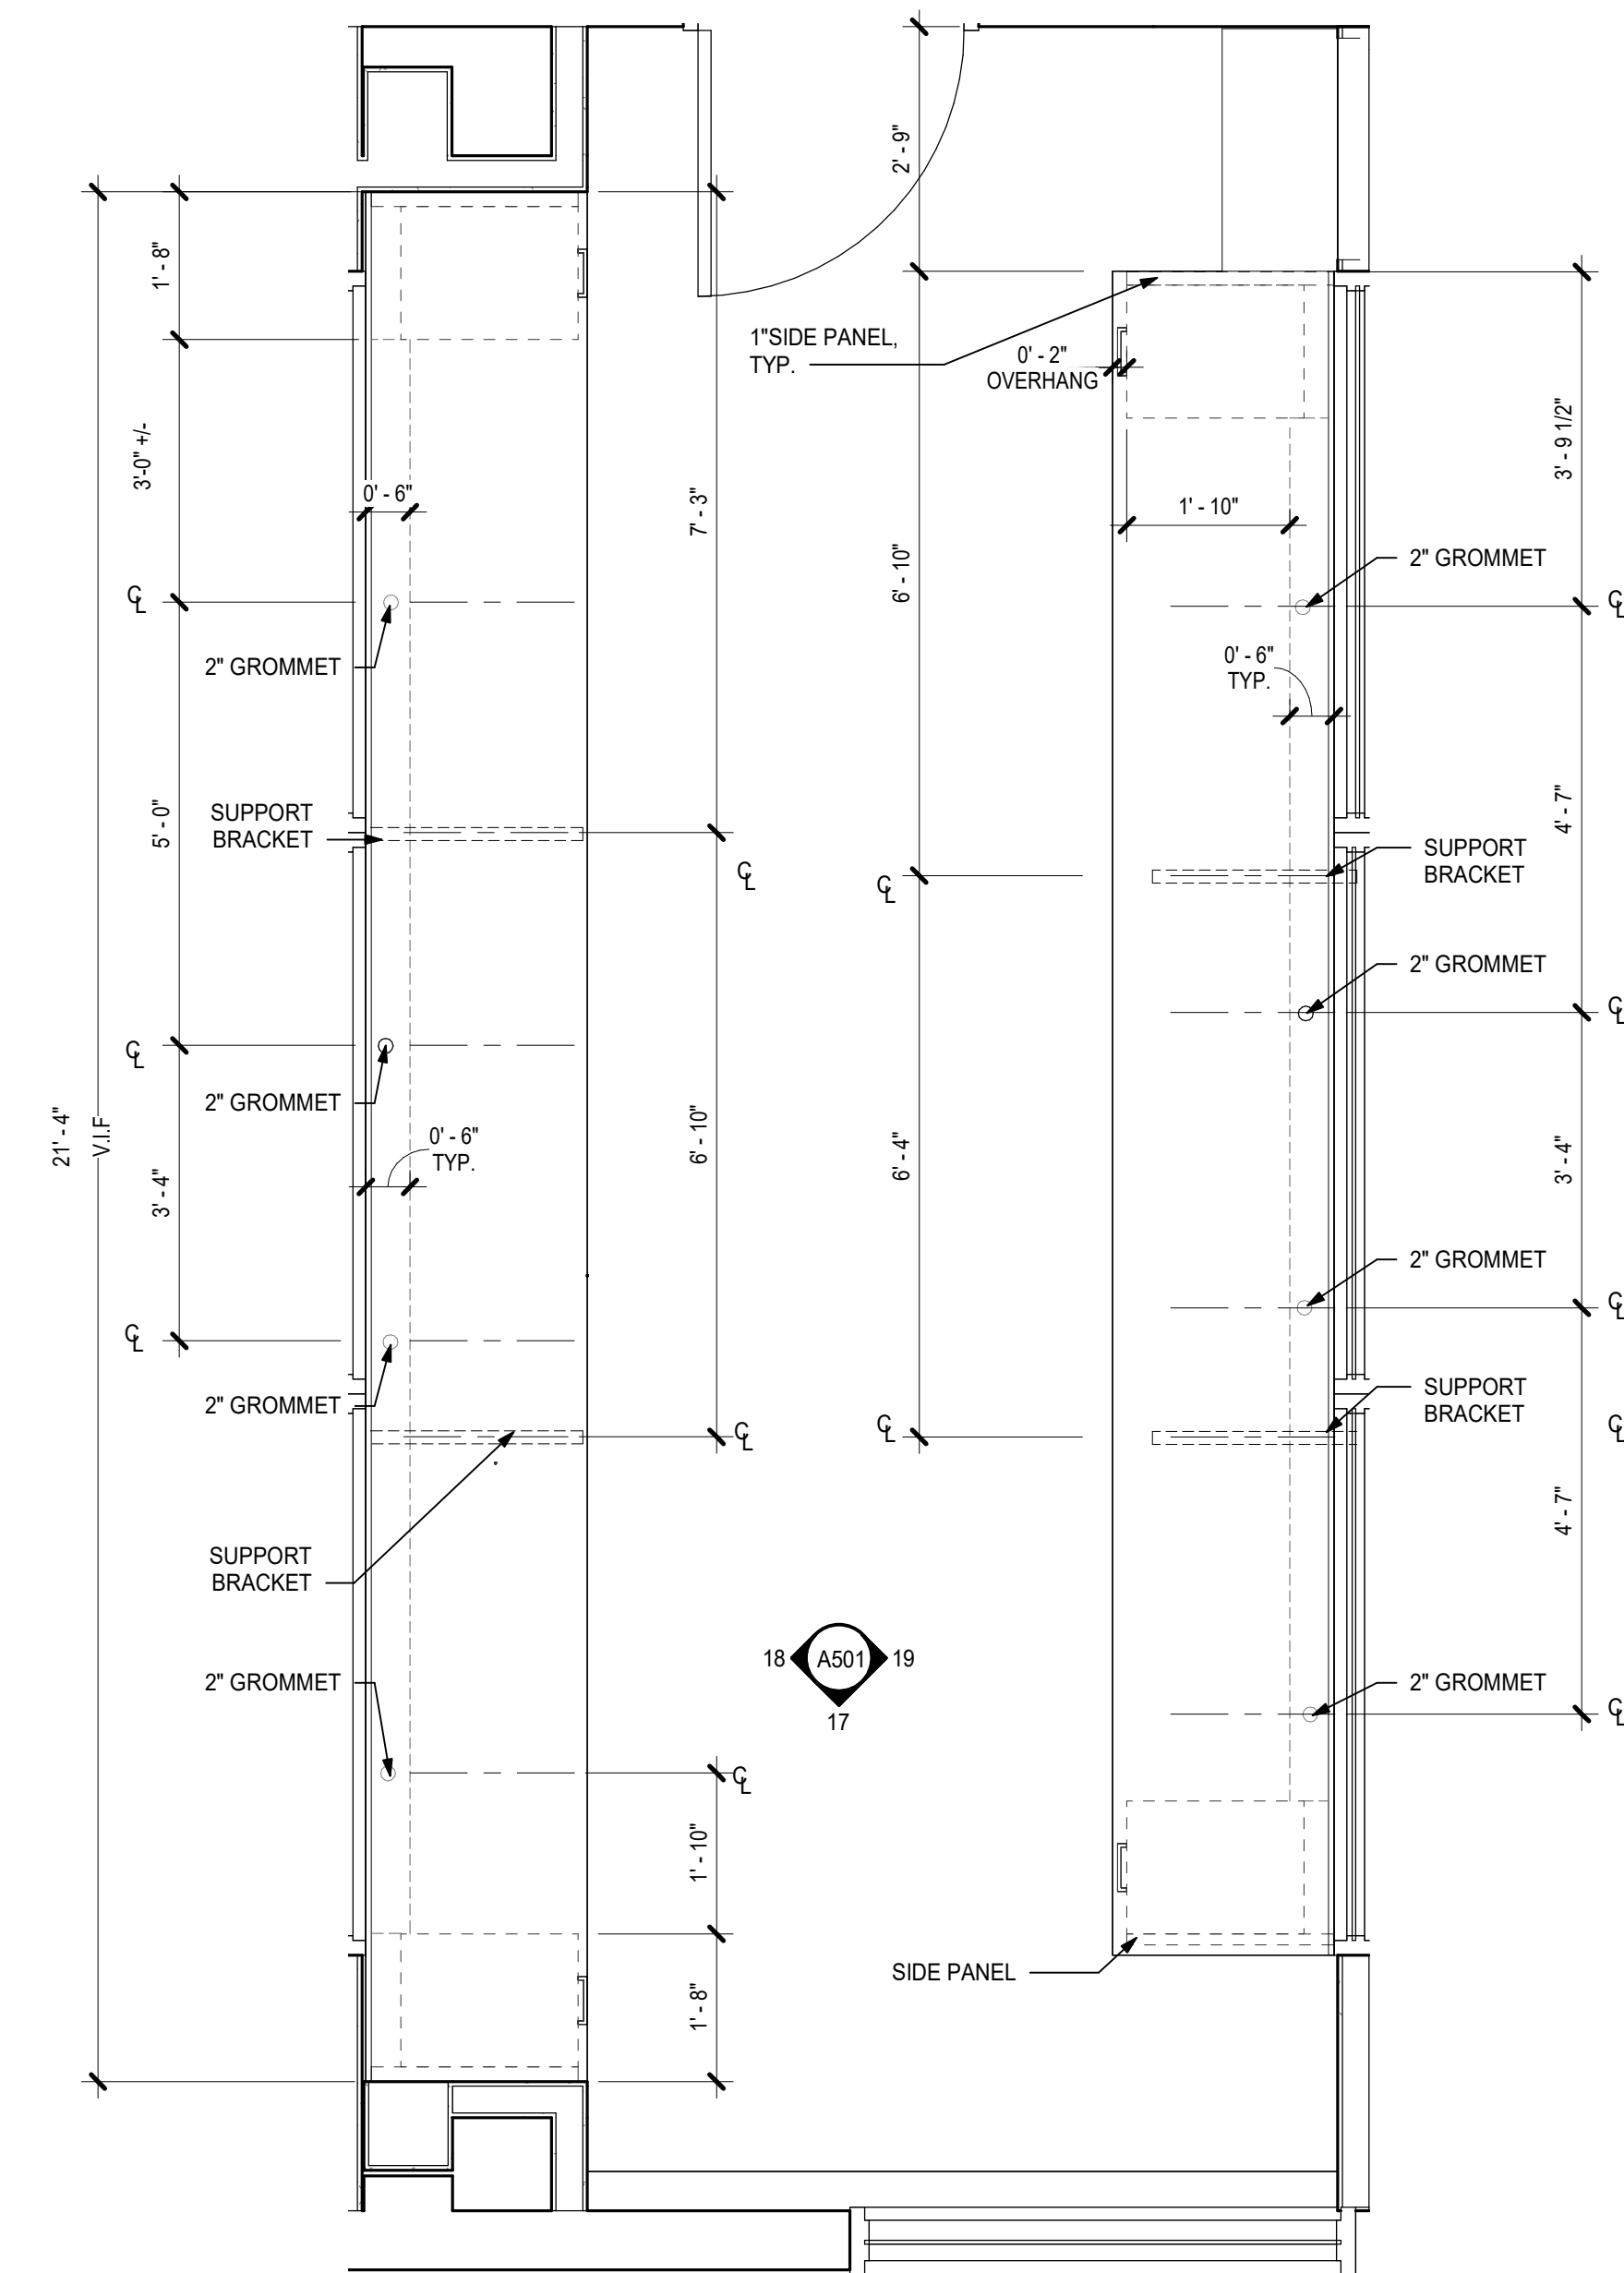


2 CONTROL RM CASEWORK

A802 (1 1/2" = 1'-0")

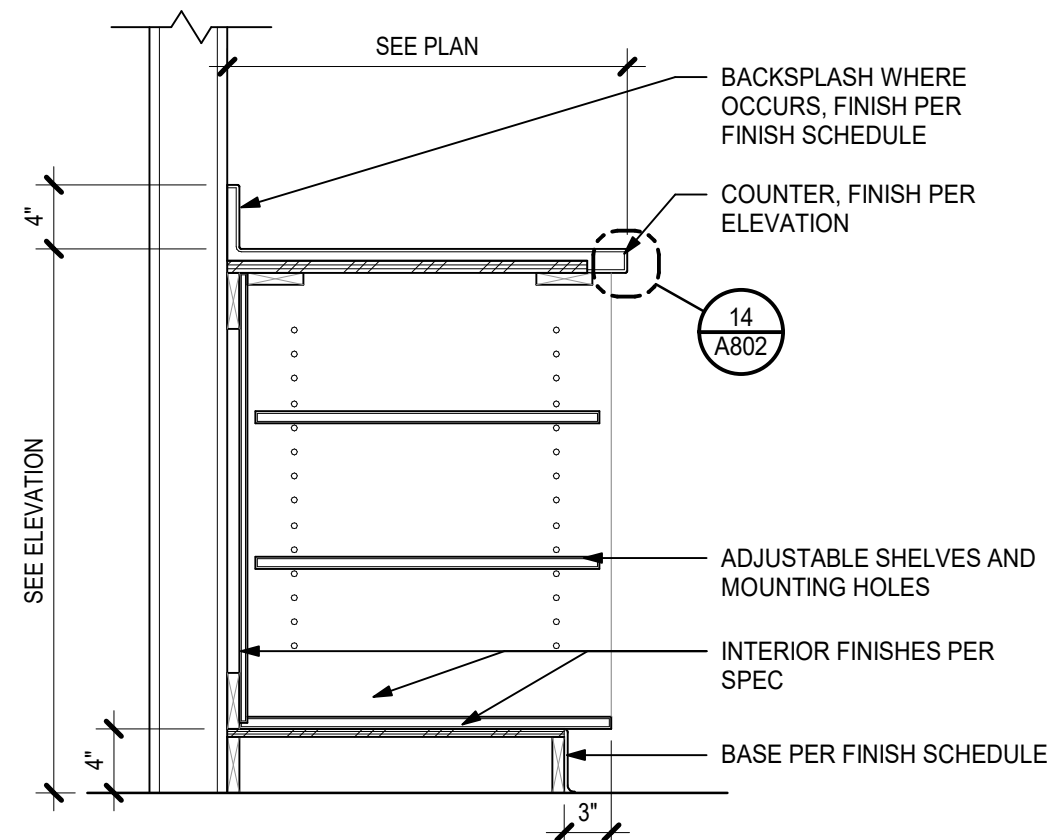


6 OPEN CABINET

A802 (1" = 1'-0")

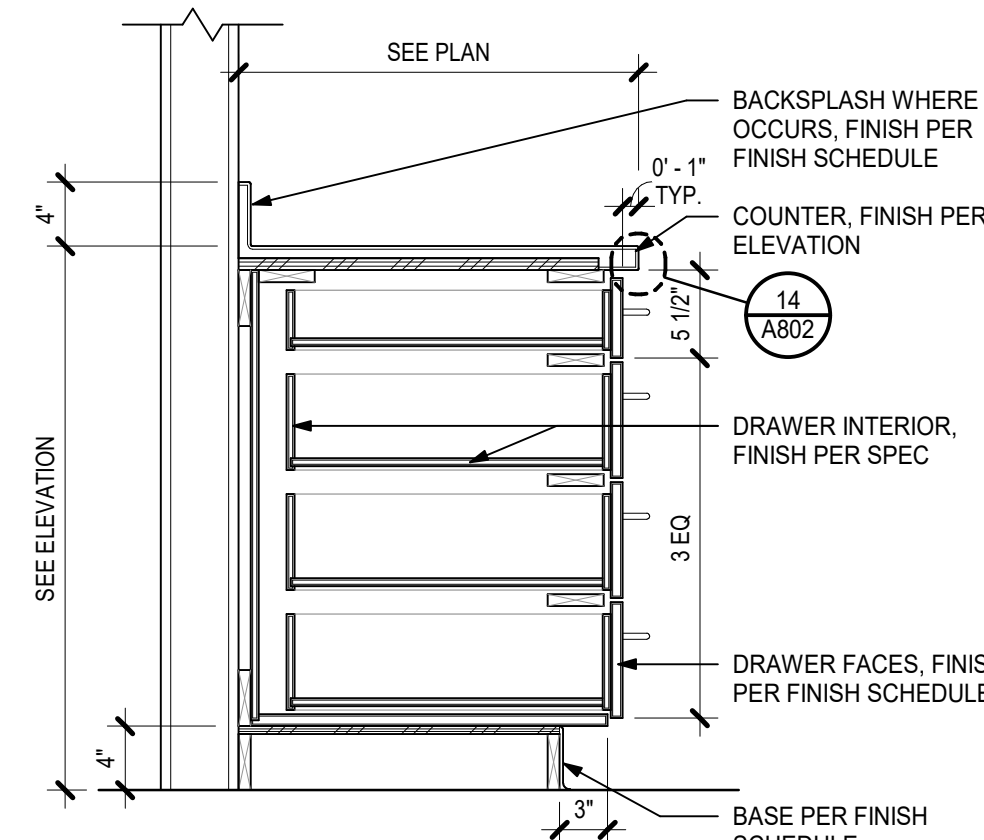


7 4 DRAWER CABINET

A802 (1" = 1'-0")

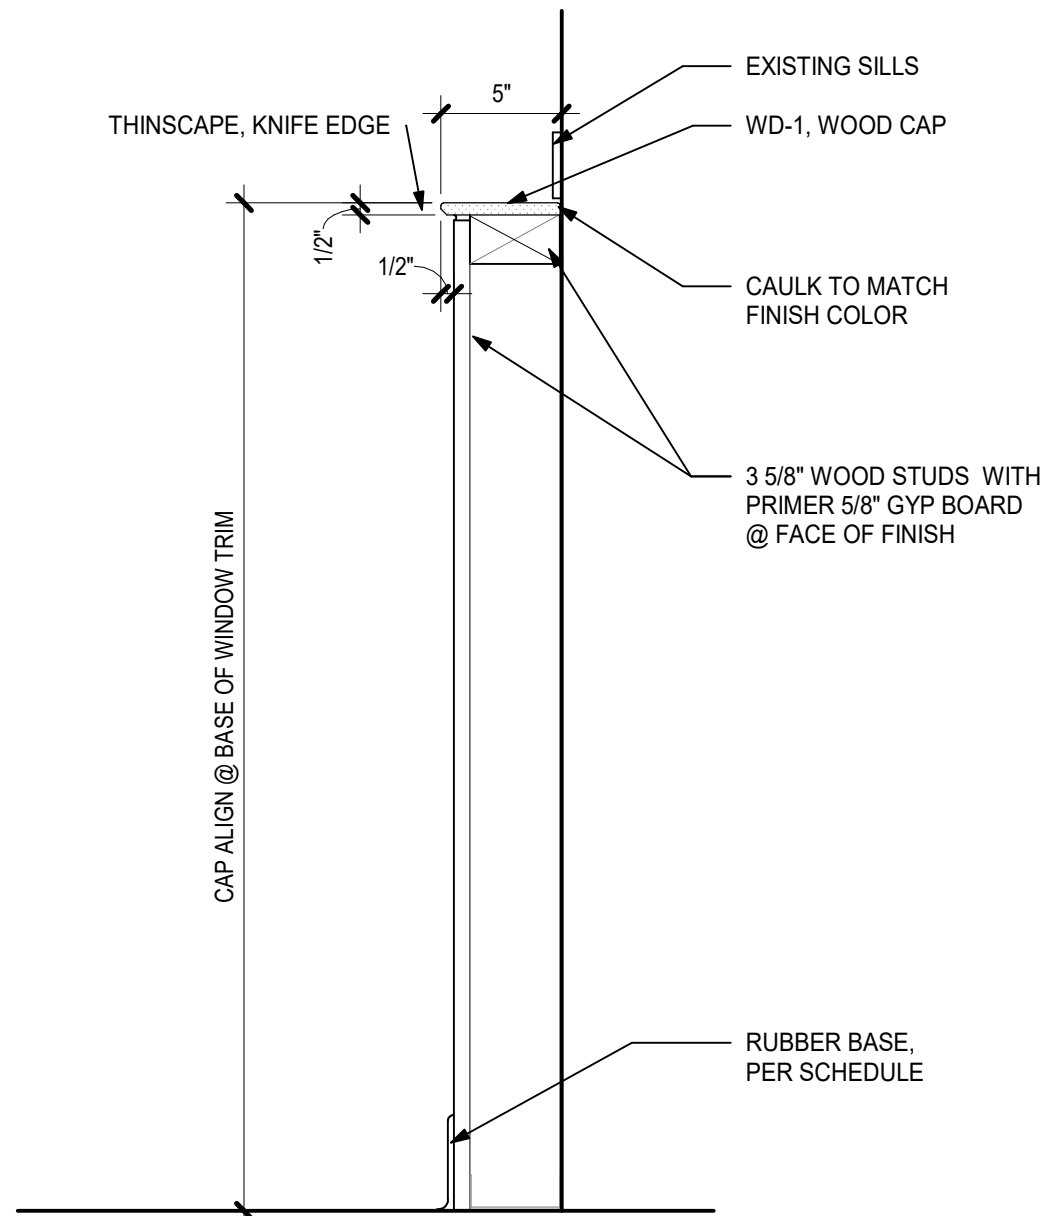


11 WALL CAP

A802 (1 1/2" = 1'-0")

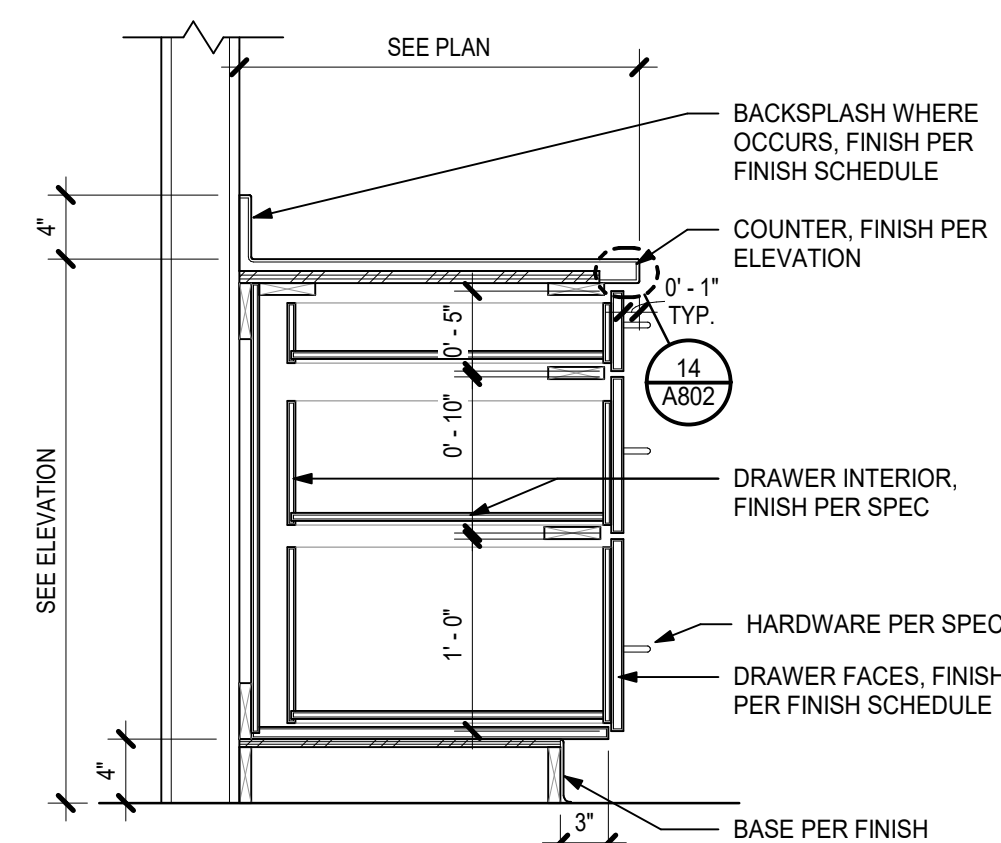


9 3 DRAWER CABINET

A802 (1" = 1'-0")

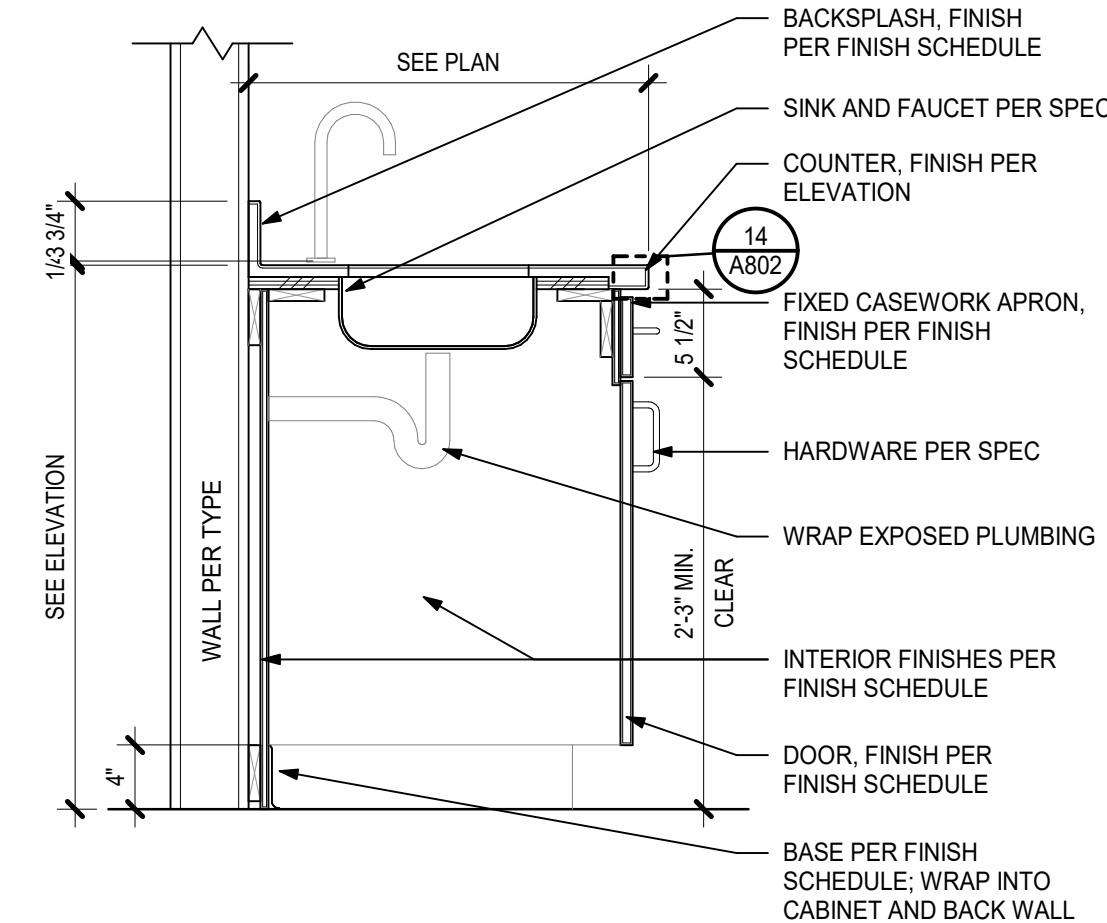


10 BASE CABINET

A802 (1" = 1'-0")

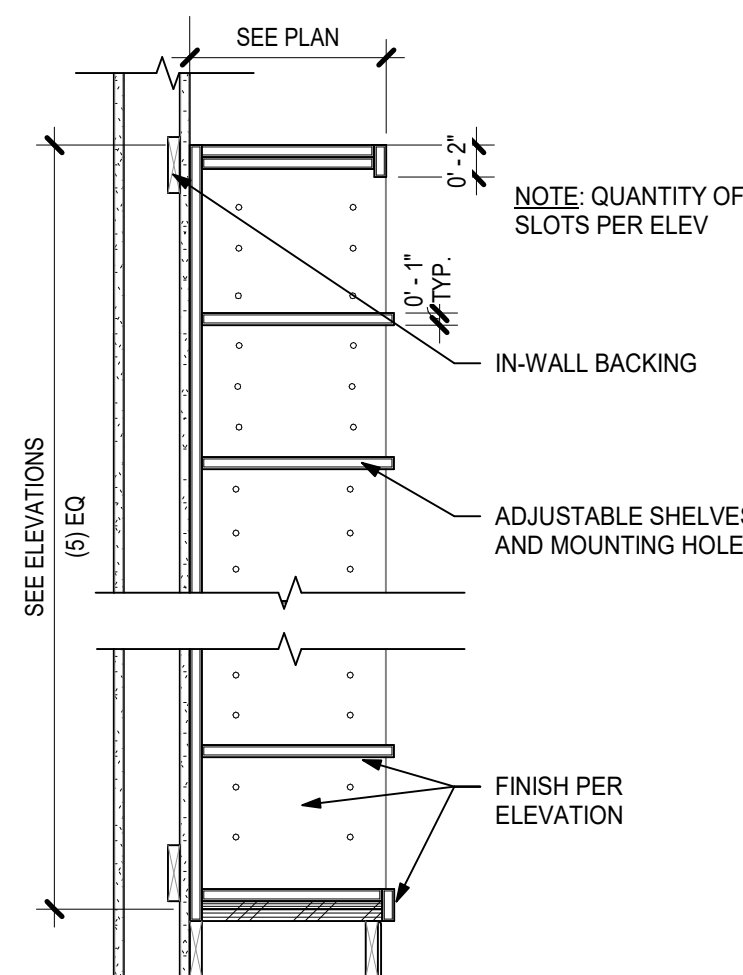


12 BOOK SHELF

A802 (1" = 1'-0")

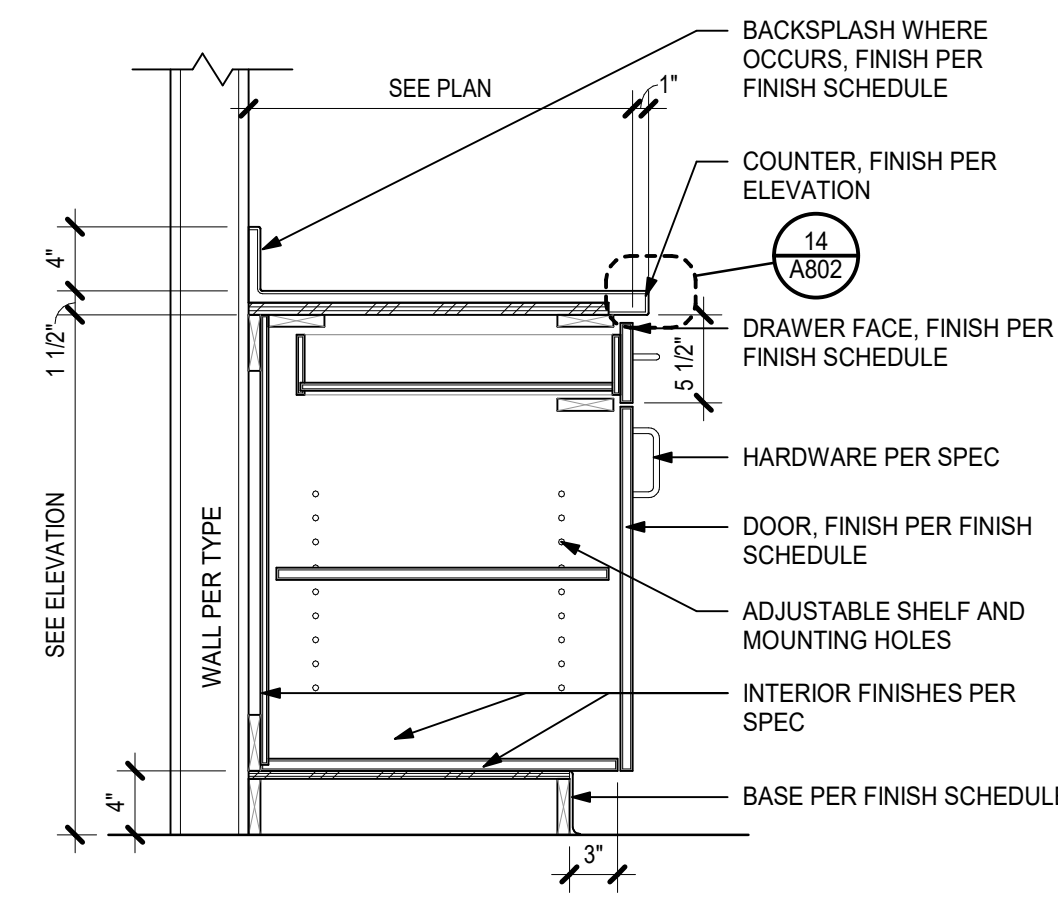


13 BASE CABINET

A802 (1" = 1'-0")

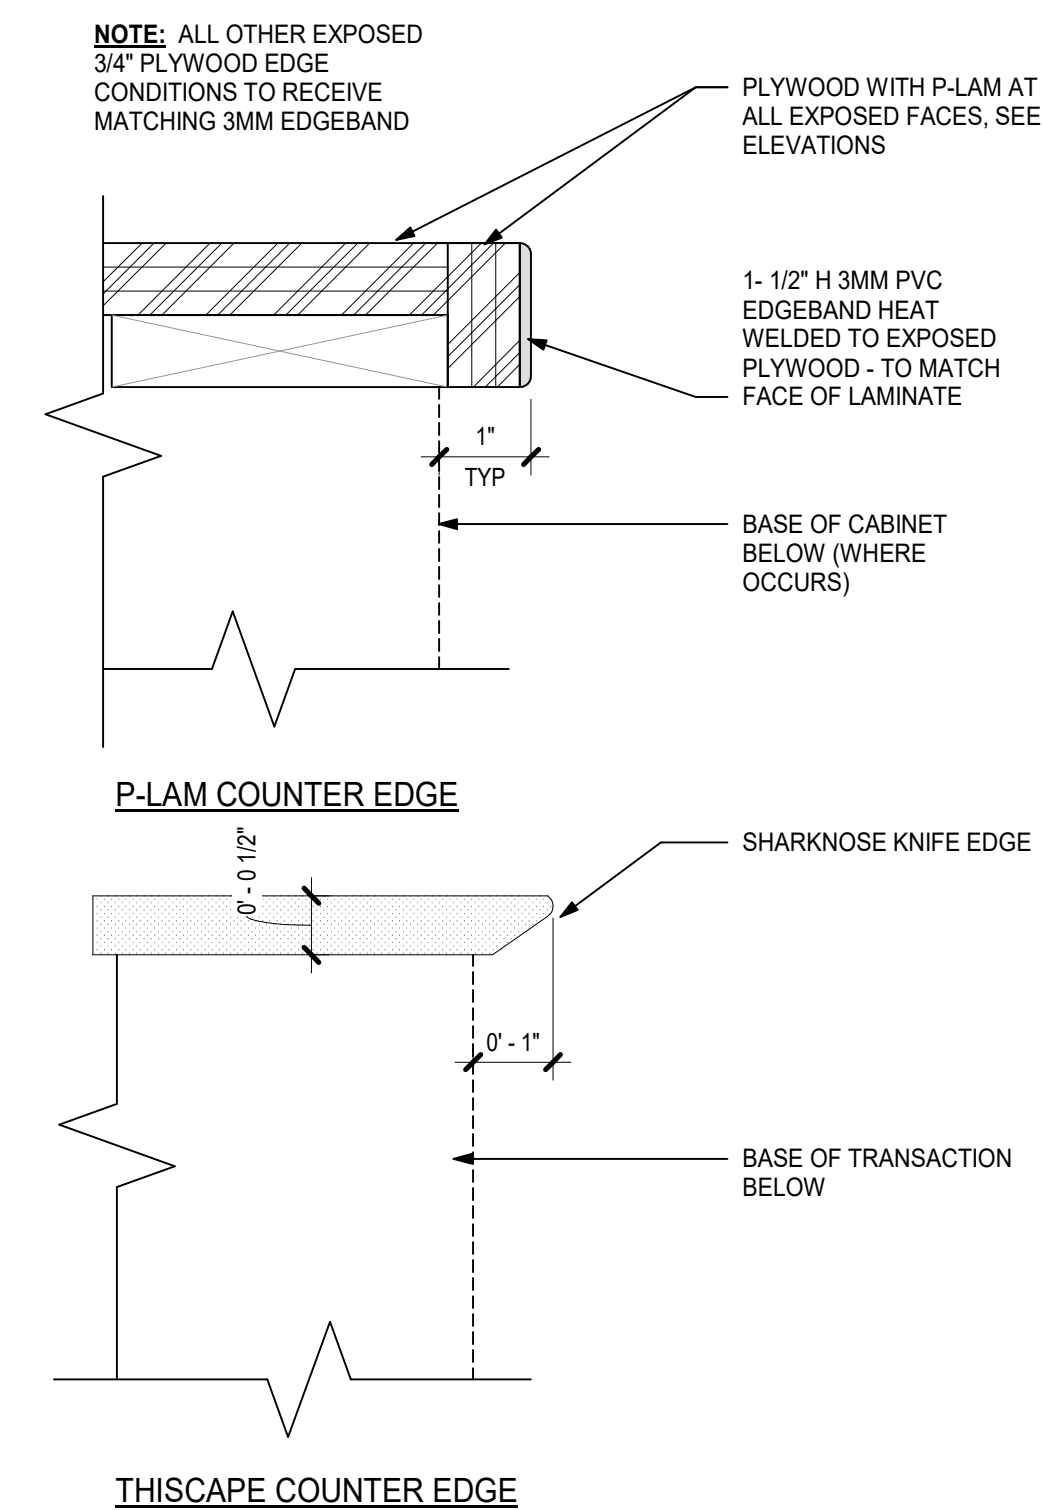


14 COUNTER DETAIL


A802 (6" = 1'-0")

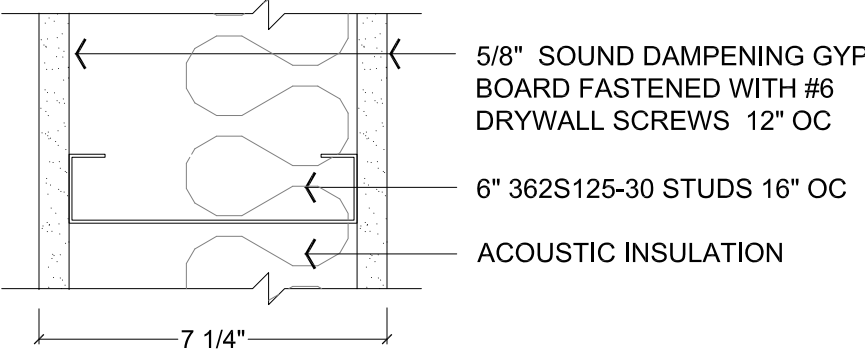


1 WALL TYPE 1
3" = 1' - 0"

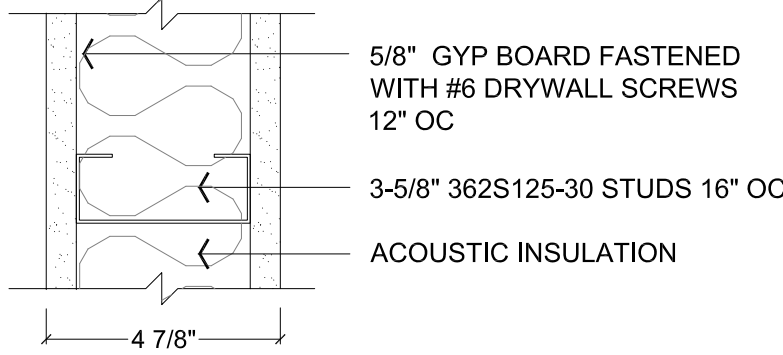


2 WALL TYPE 2
3" = 1' - 0"

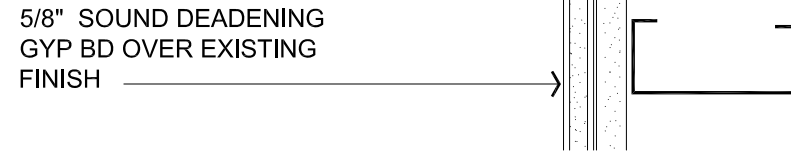


3 WALL TYPE 3
3" = 1' - 0"

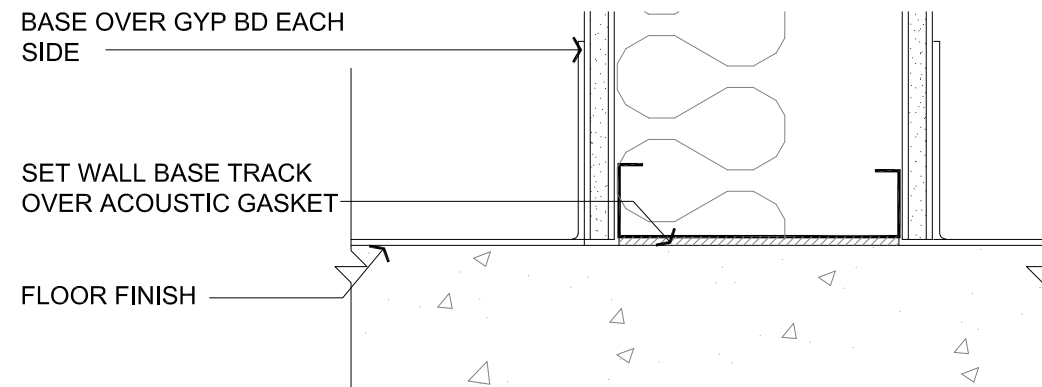


4 WALL BASE
3" = 1' - 0"

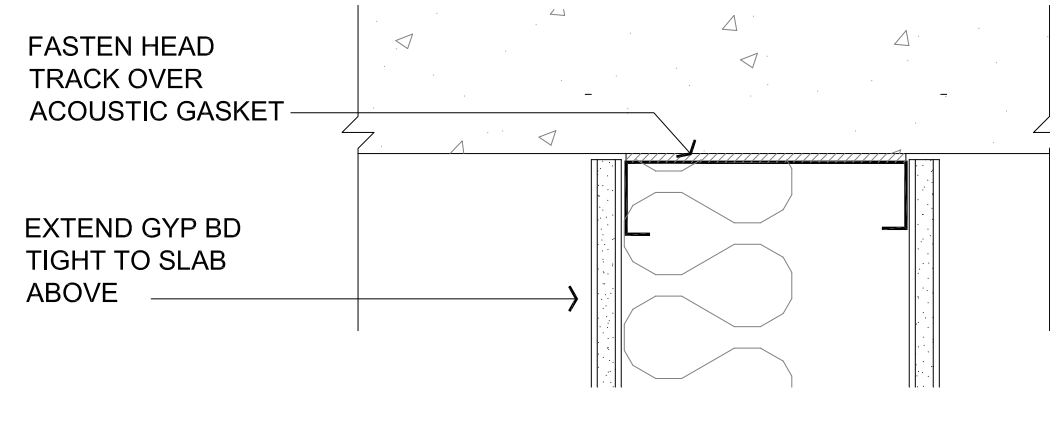

5 WALL HEAD
3" = 1' - 0"

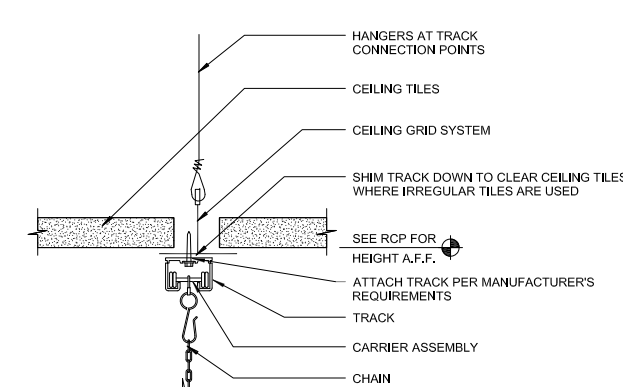


6 CURTAIN TRACK
3" = 1' - 0"

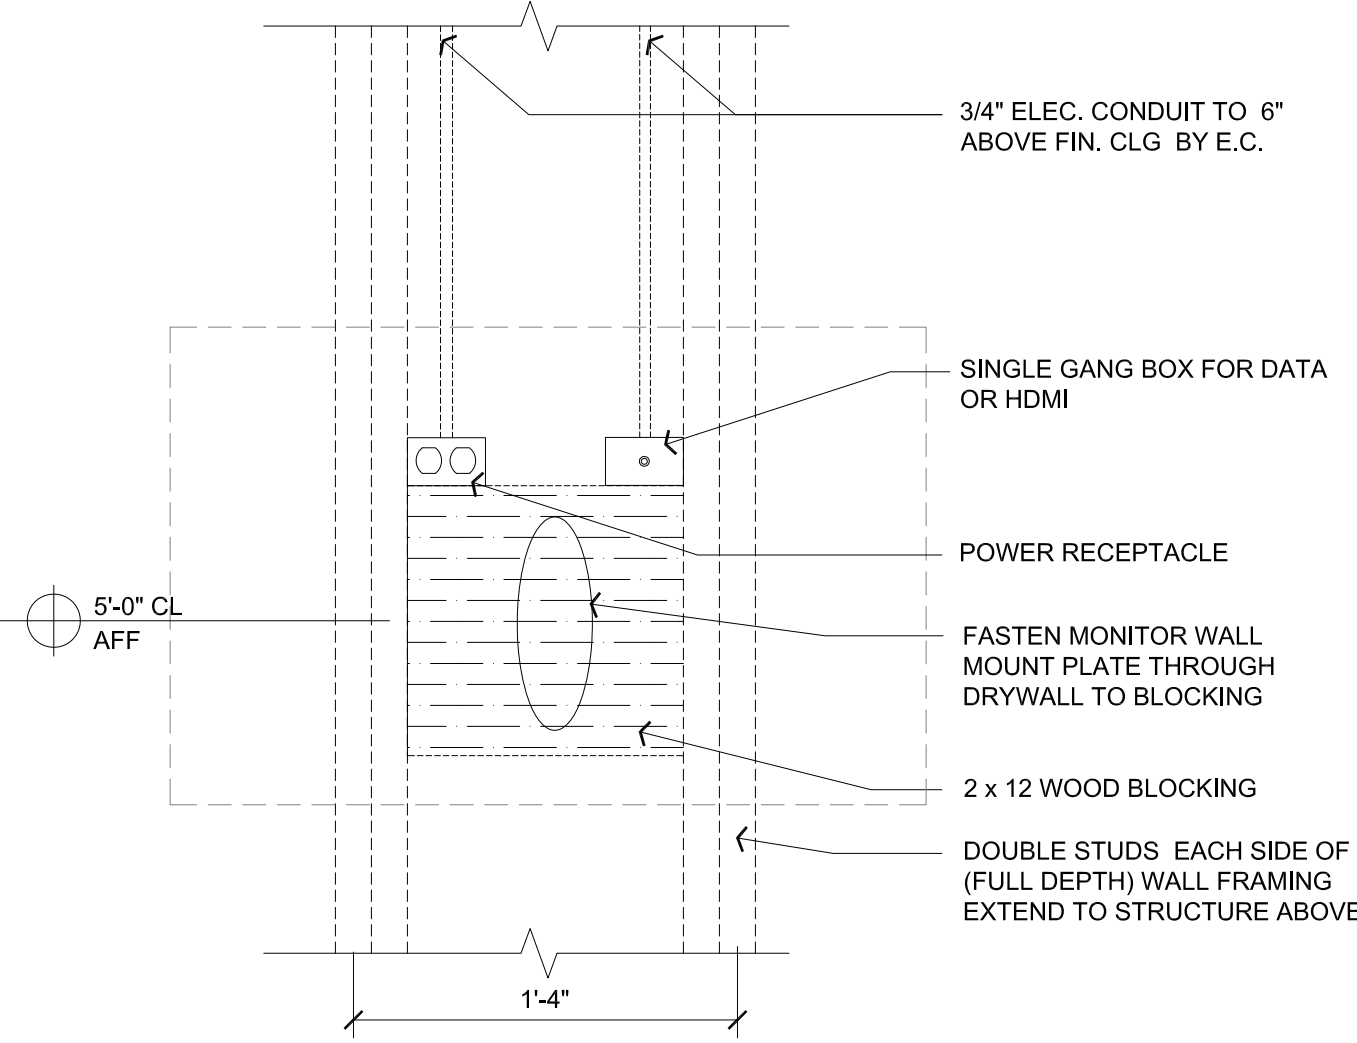

7 MONITOR WALL MOUNT
1 1/2" = 1' - 0"

Space Name	As-Designed Level	Target Level	Mitigation Recommendations
Control Room	NC 43		
SIM-1/SIM-2	NC 45	NC 30	
Debrief-1	NC 31		
SIM-3/SIM-4	NC 49	NC 30	
Debrief-2	NC 31		

8 DUCT SILENCER SCHEDULE

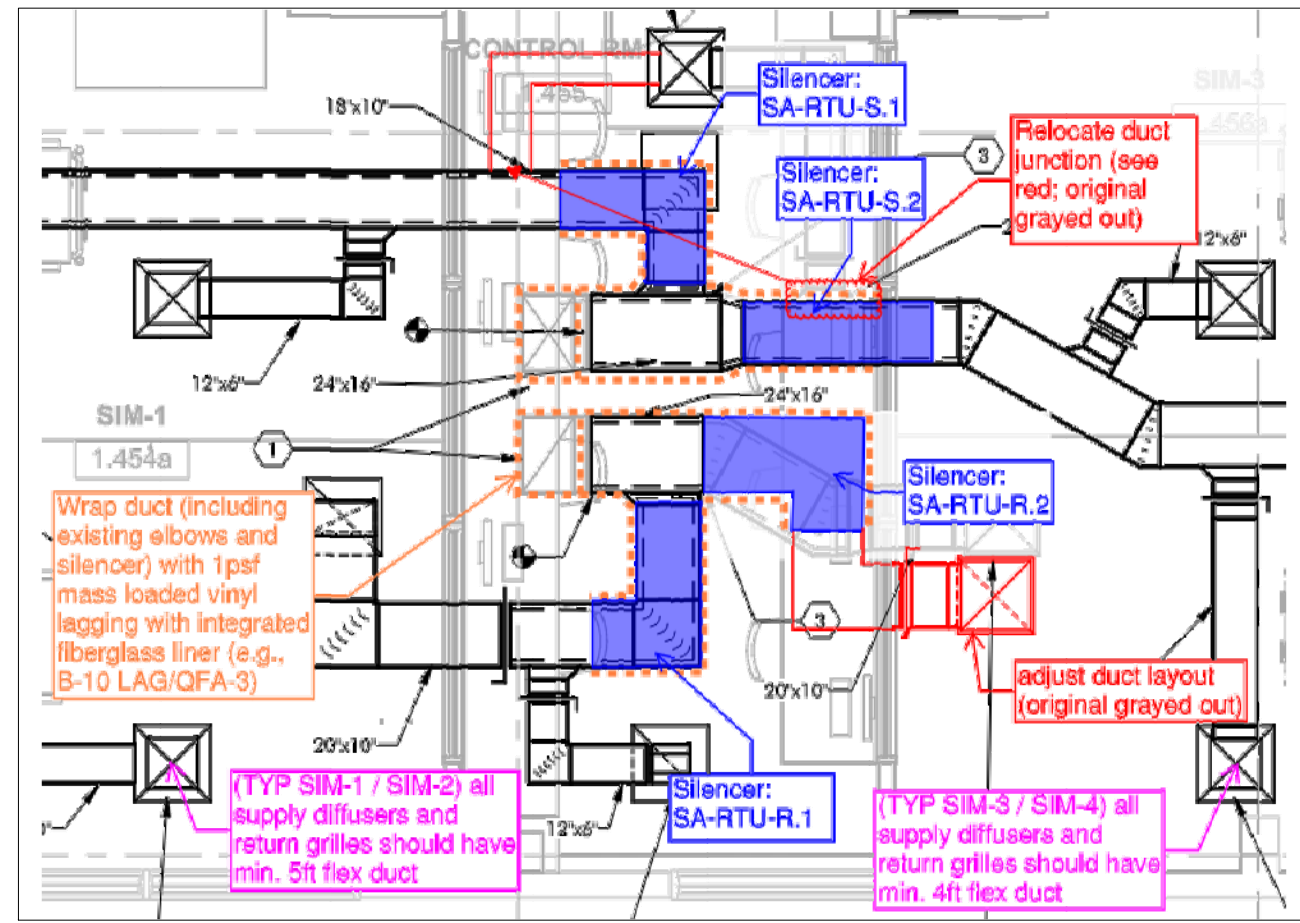

9 DUCT SILENCER LOCATIONS